

**CHHATTISGARH MEDICAL SERVICES CORPORATION
LIMITED,**

(Government of Chhattisgarh)

Tender

For

**Construction of 50 bedded MCH wing at Balodabazar (C.G.),
under National Rural Health Mission scheme**

Tender Drawings

VOLUME-VI

APRIL' 2013




**HSCC (INDIA) LTD.
(CONSULTANTS & ENGINEERS FOR MEGA HOSPITALS & LABORATORIES)
E-6(A), sector-1, NOIDA(U.P) 201301 (India)**

Phone : 0120-2542436-40

Fax : 0120-2542447

Tender No. HSCC/NRHM/CG./2013 /10

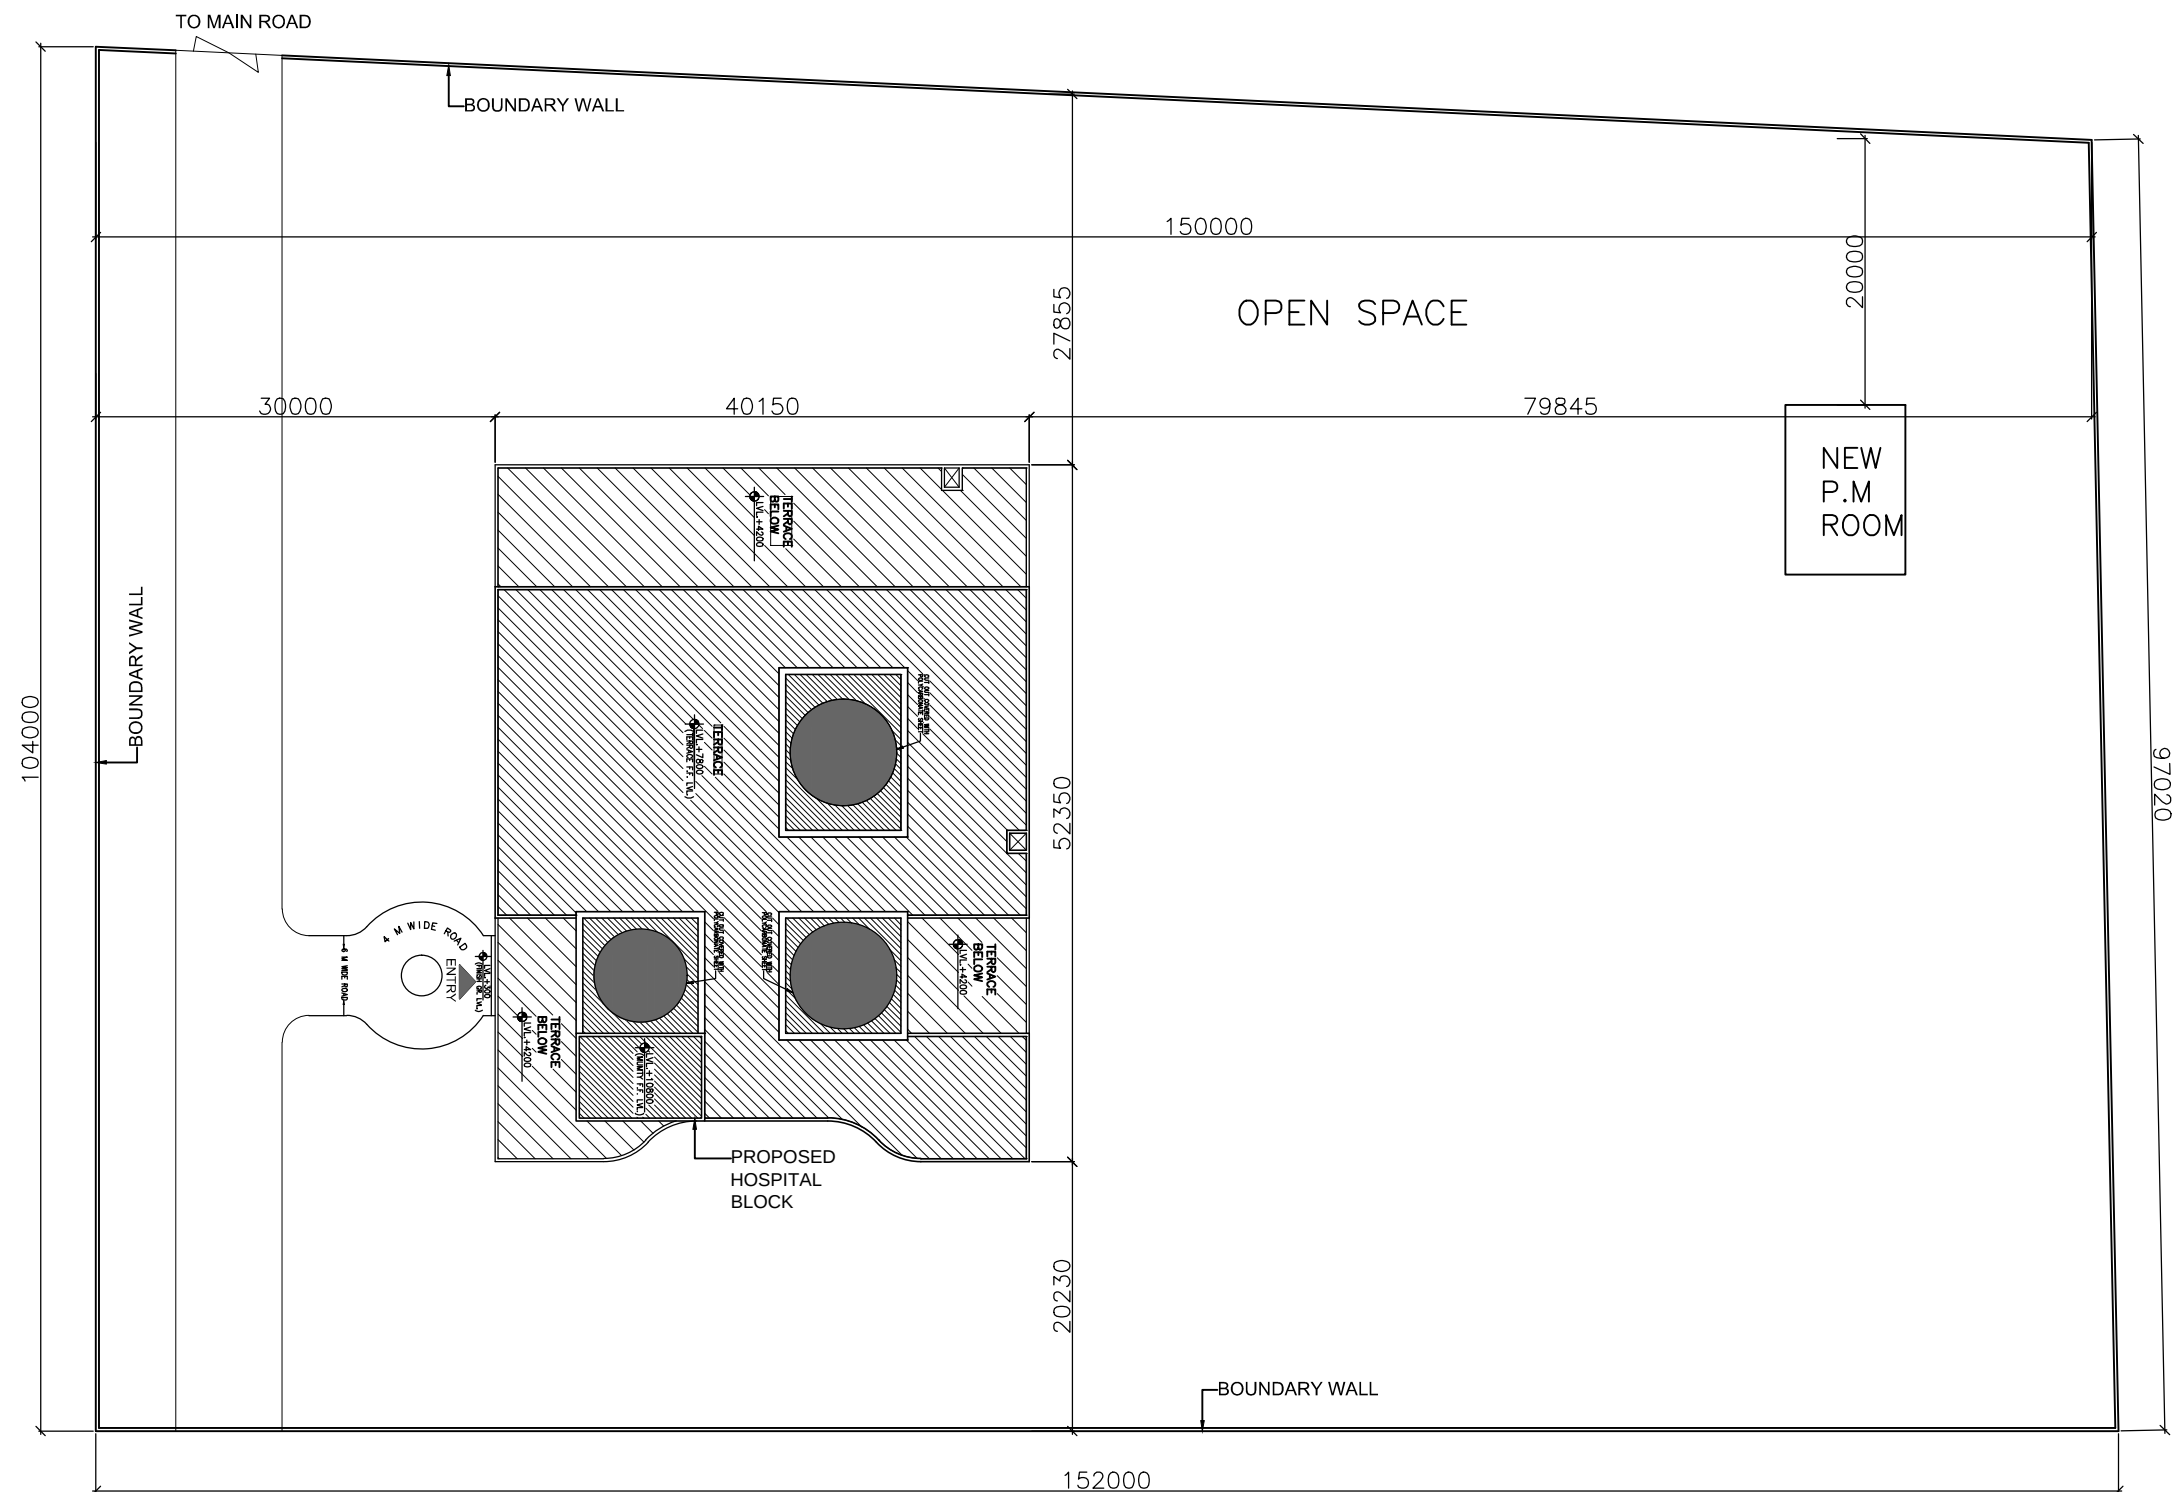

This drawing with all its contents is the sole intellectual property of the Hospital Services Consultancy Corporation (India) Ltd. Copying of this drawing or part thereof or its use in any form whatsoever without the written permission of HSCC is prohibited.

NOTES

REV	DATE	DESCRIPTION
REVISION		

PROJECT

RMNCH PROJECT
Proposed
50 Bedded Hospital
at PANDARIYA
CHATTISGARH

TITLE

SITE PLAN


TENDER DRAWING

HSCC/PANDARIYA/TD/001 R-0
Drawing No. Rev.

HSCC/- 1:250 12-04-2013
Job No. Scale Date

App by Rev. by Prep. by

HSCC (INDIA) LIMITED
(A GOVERNMENT OF INDIA ENTERPRISES)
HSCC
NEW DELHI INDIA

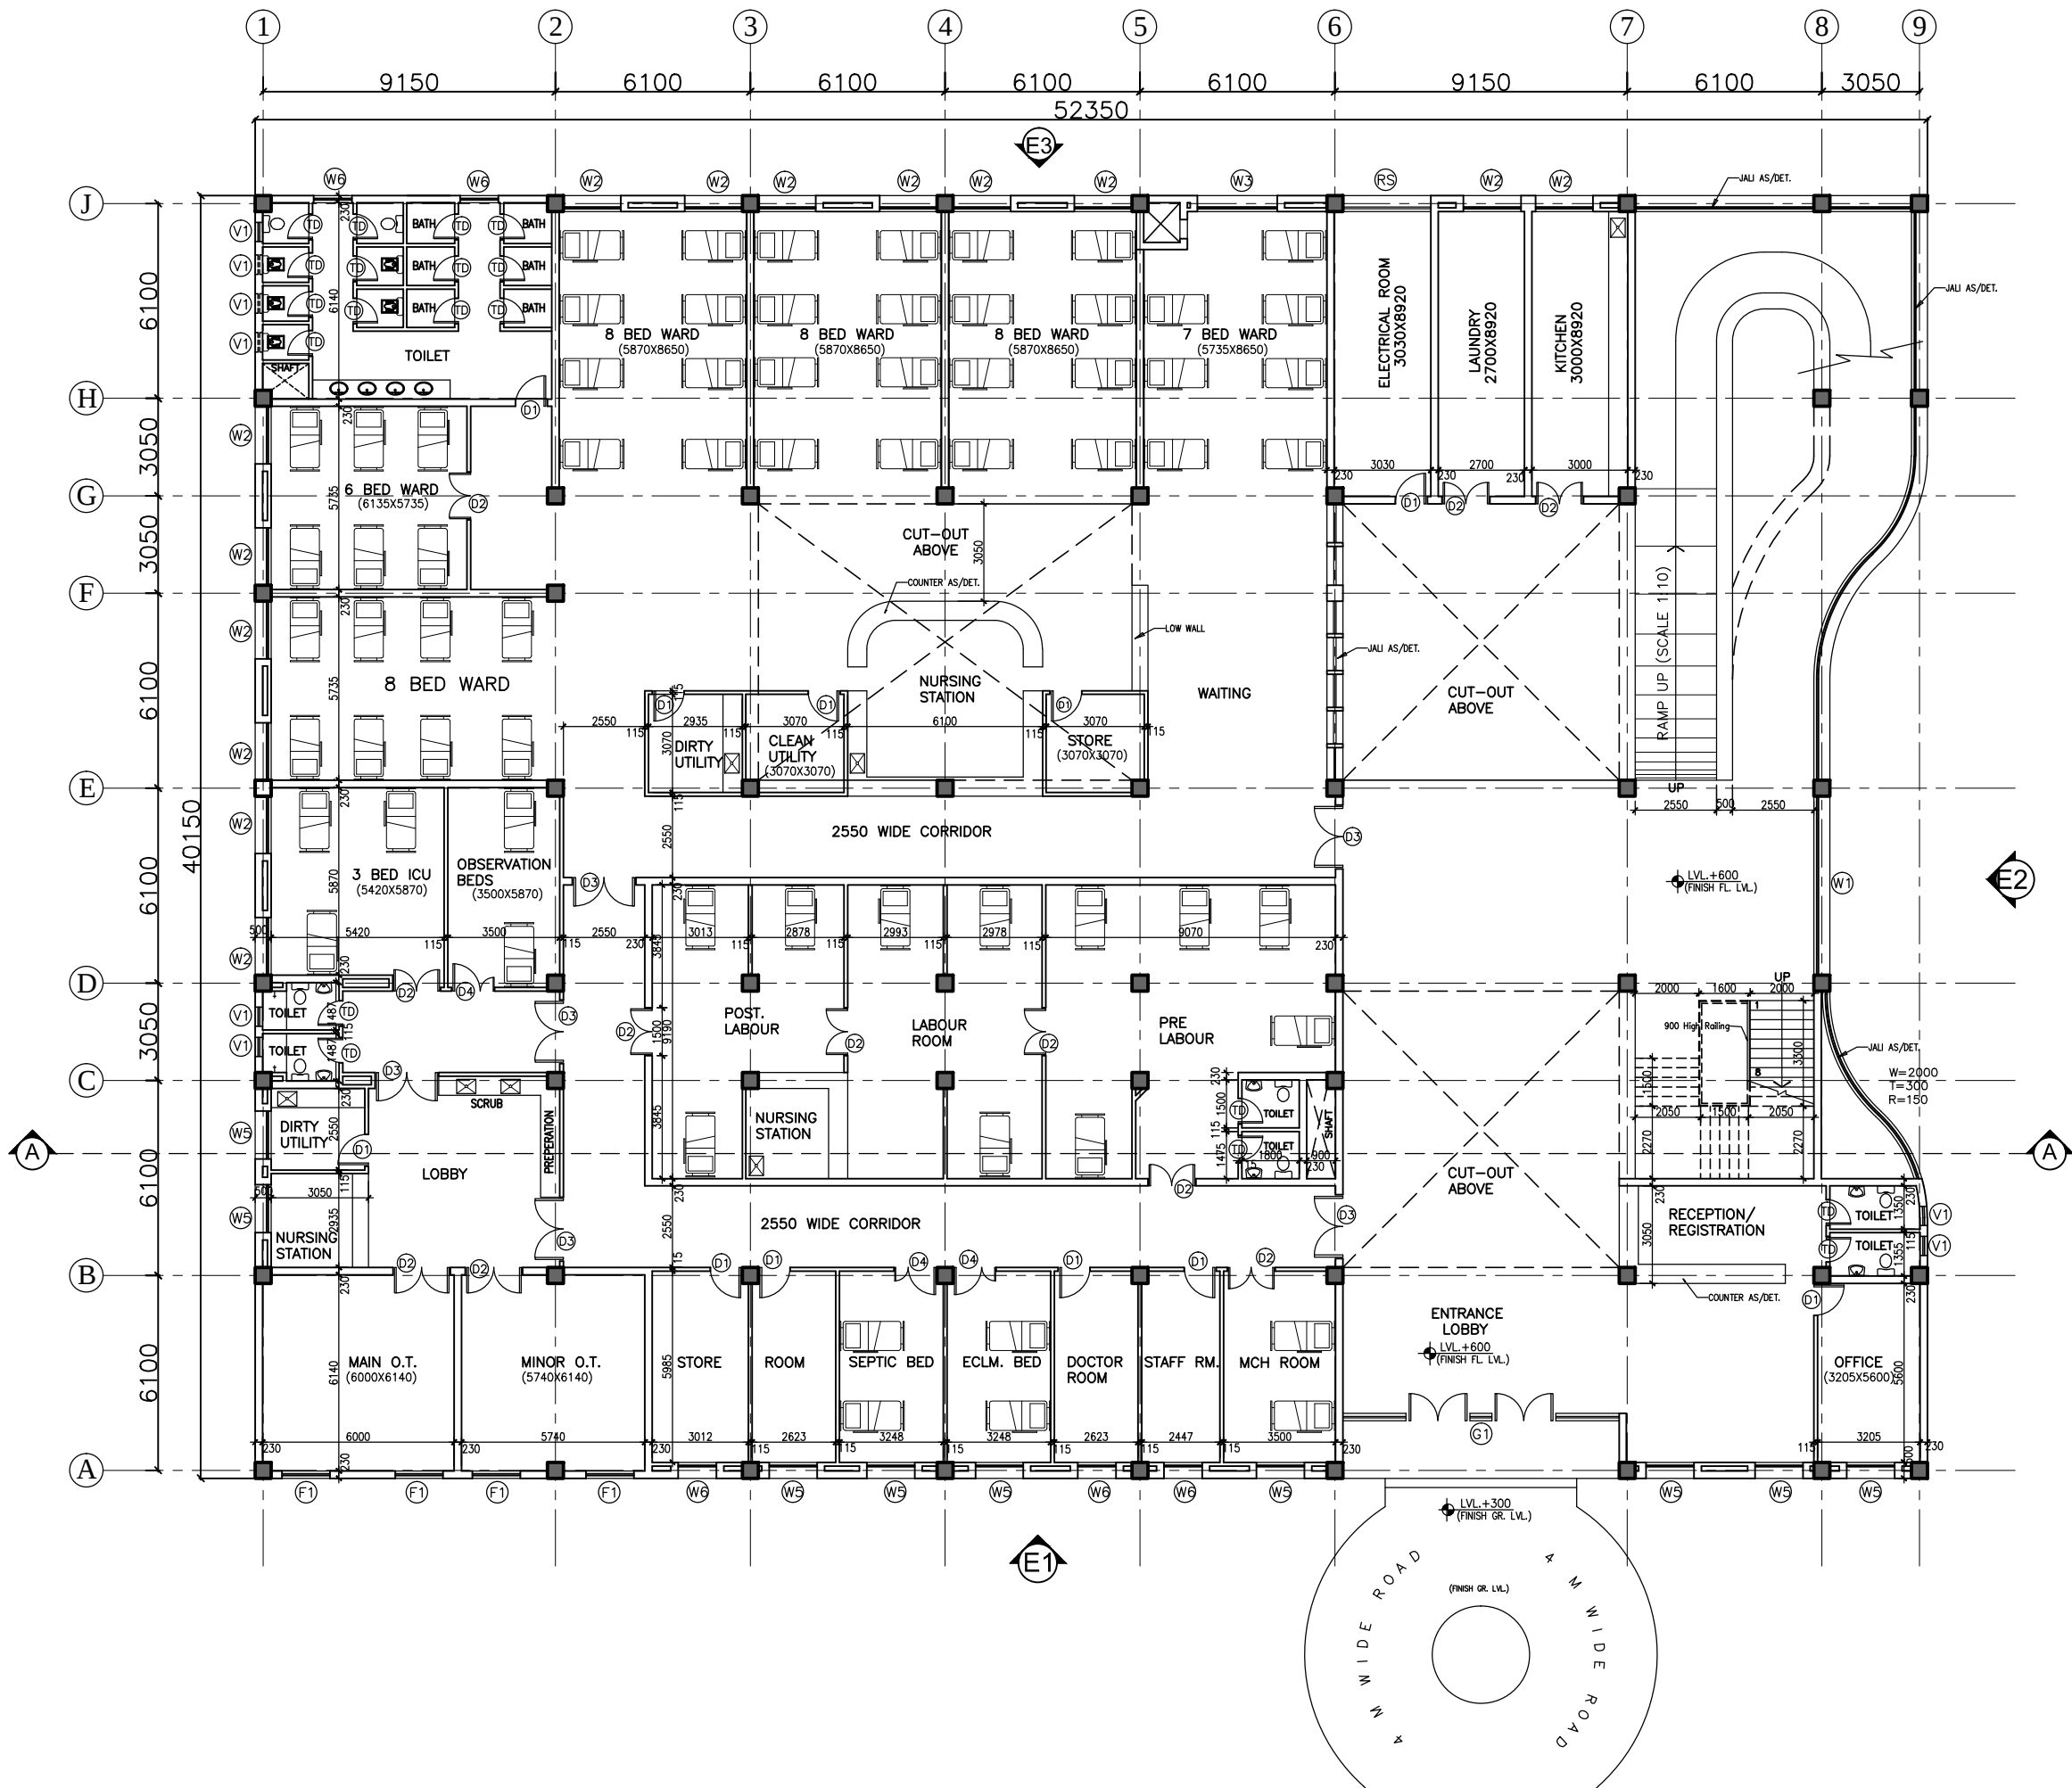

This drawing with all its contents is the sole intellectual property of the Hospital Services Consultancy Corporation (India) Ltd. Copying of this drawing or part thereof or its use in any form whatsoever without the written permission of HSCC is prohibited.

NOTES

DOOR AND WINDOW SCHEDULE

S.No	NAME	SIZE	CILL	LINTEL	REMARKS
1	TD	800X2150	000	2150	
2	D1	1000X2150	000	2150	
3	D2	1500X2150	000	2150	DOUBLE SHUTTER
4	D3	2000X2150	000	2150	DOUBLE SHUTTER
5	D4	1350X2150	000	2150	DOUBLE SHUTTER

RS	2760X3000	000	3000	BEAM BOTTOM
G1	8650X3000	0/150	3000	BEAM BOTTOM
G2	5600X3000	0/150	3000	BEAM BOTTOM

W1	5600X2100	900	3000	BEAM BOTTOM
W2	1800X2100	900	3000	
W3	2500X2100	900	3000	
W4	920X2100	900	3000	
W5	1500X2100	900	3000	
W6	1200X2100	900	3000	
F1	1500X2100	900	3000	

V1	600X600	1550	2150	
----	---------	------	------	--

REV DATE DESCRIPTION

REVISION

PROJECT

RMNCH PROJECT

Proposed 50
Bedded Hospital
at CHATTISGARH

TITLE

GROUND FLOOR PLAN

(COVERED AREA=2050 SQ. MT.)

TENDER DRAWING (ARCH.)

HSCC/CHATTISGARH/TD/002

Drawing No.

R-0

Rev.

HSCC/-

Job No.

1:100

Scale

01-04-2013


Date

App by

Rev. by

Prep. by

HSCC (INDIA) LIMITED
(A GOVERNMENT OF INDIA ENTERPRISES)
HSCC
NEW DELHI INDIA

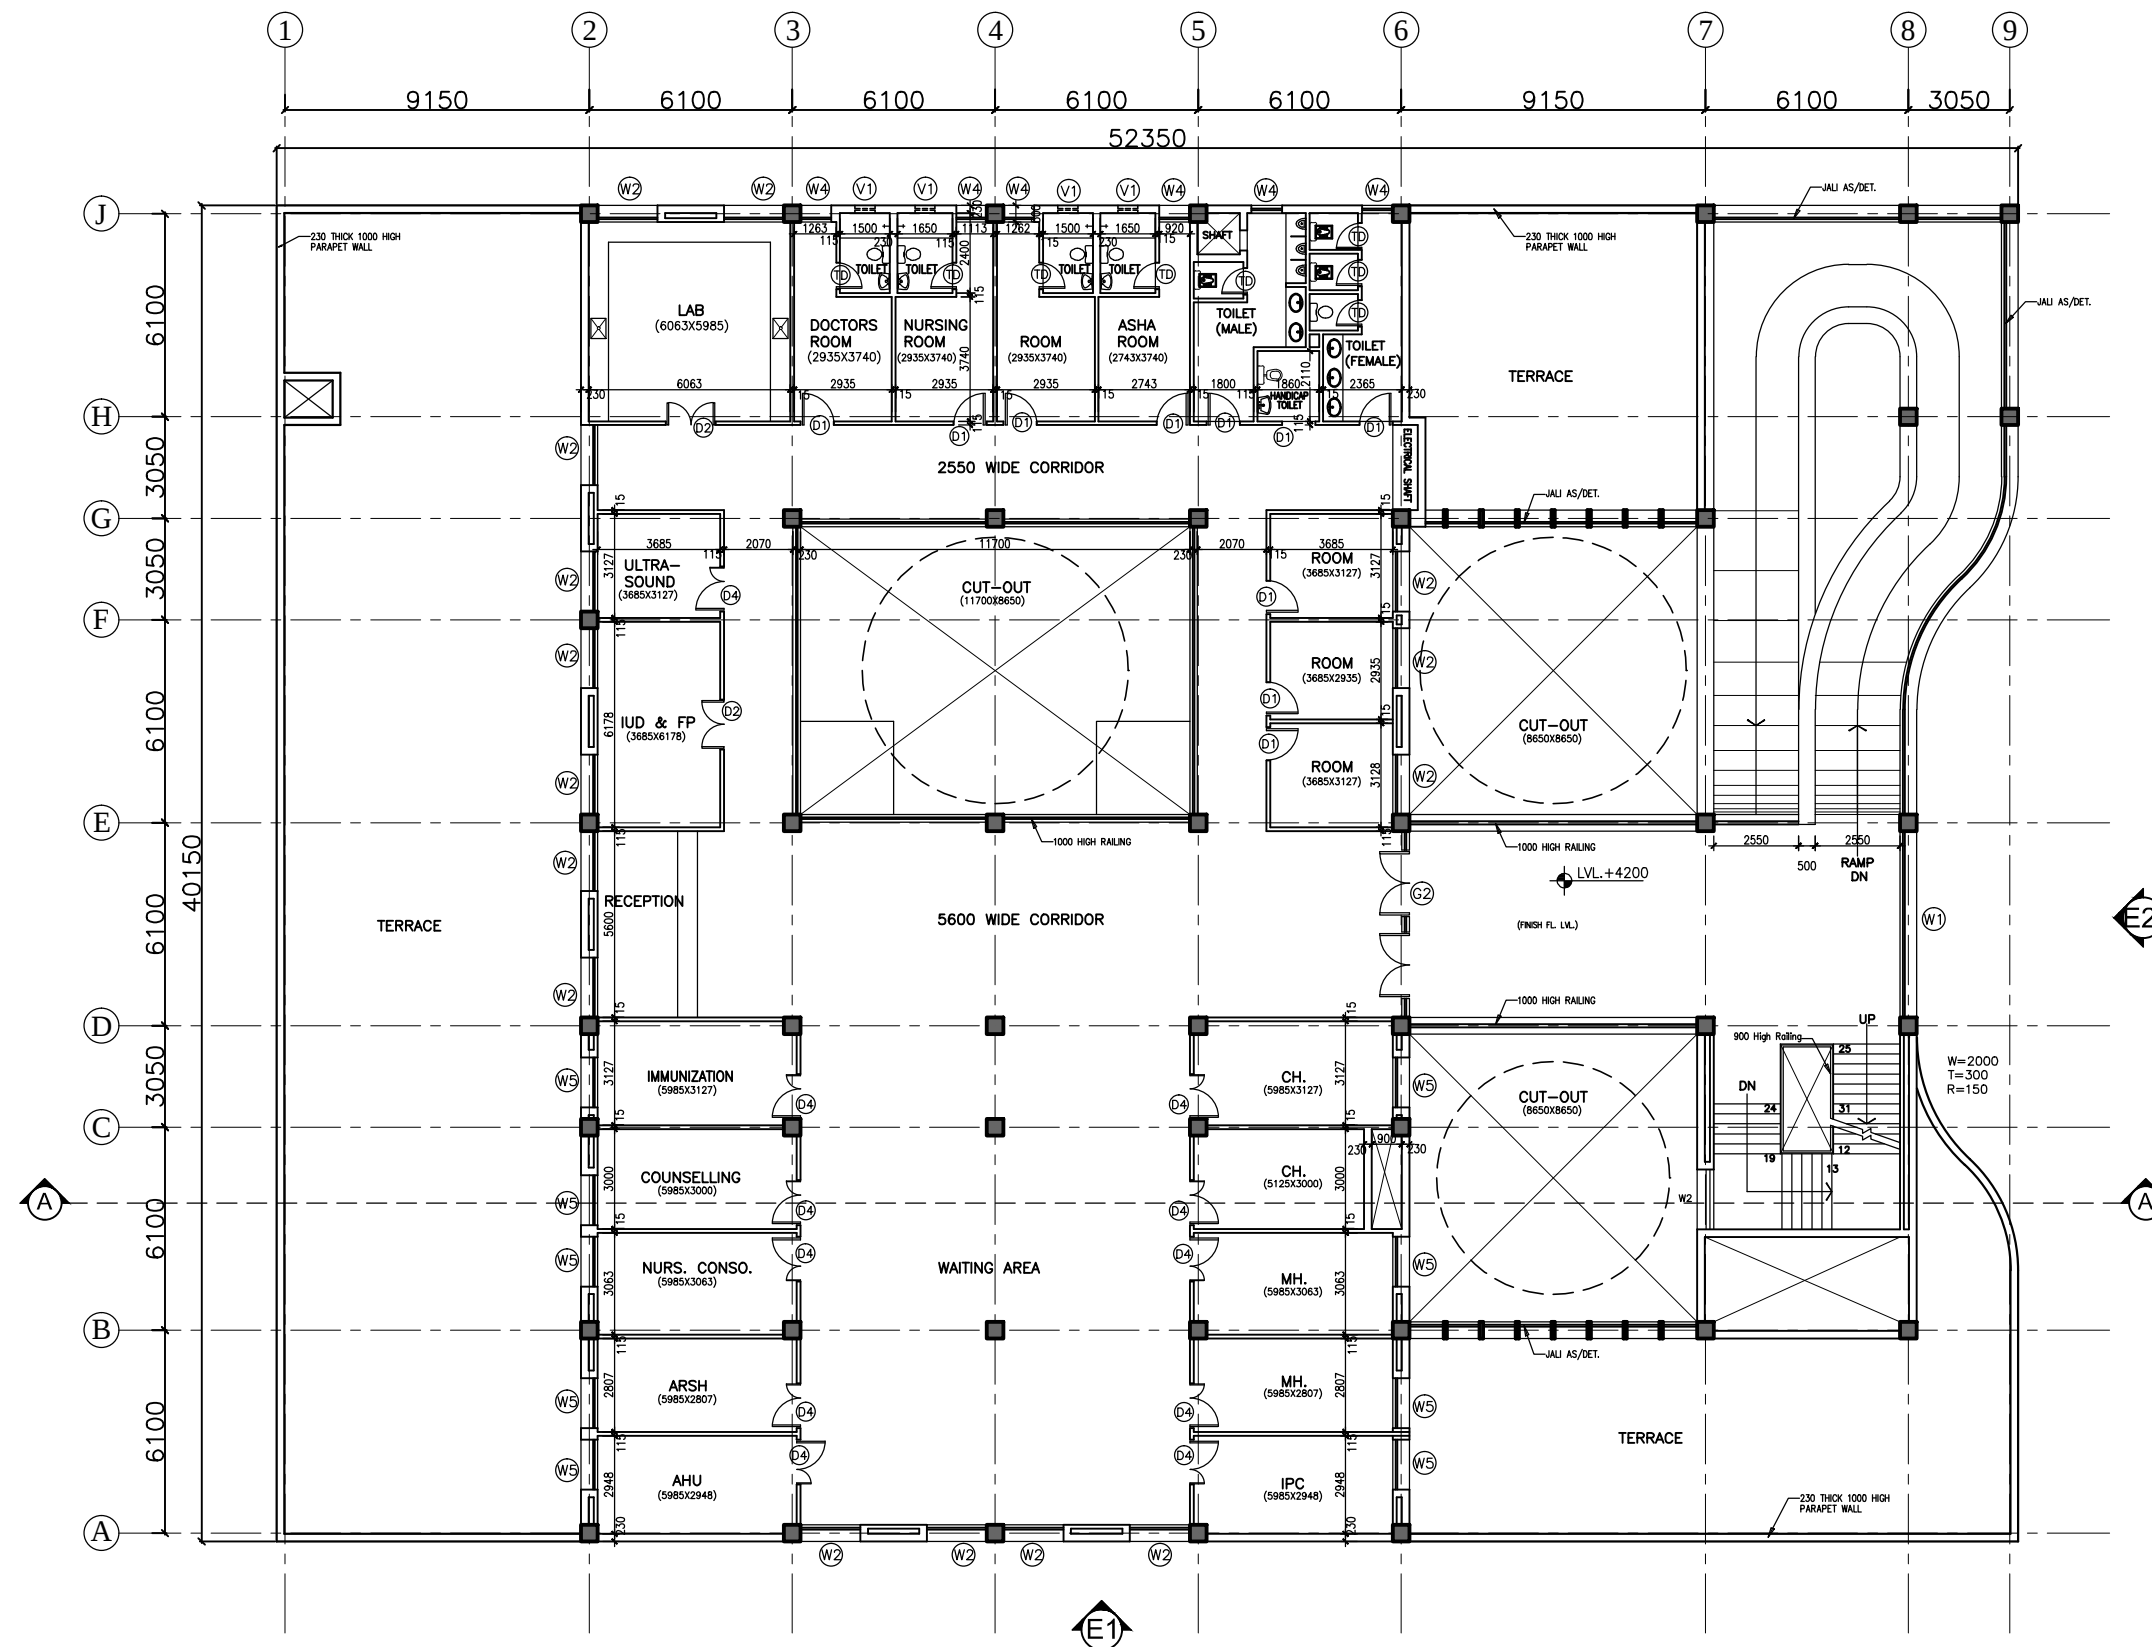

This drawing with all its contents is the sole intellectual property of the Hospital Services Consultancy Corporation (India) Ltd. Copying of this drawing or part thereof or its use in any form whatsoever without the written permission of HSCC is prohibited.

NOTES

DOOR AND WINDOW SCHEDULE

S.No	NAME	SIZE	CILL	LINTEL	REMARKS
1	TD	800X2150	000	2150	
2	D1	1000X2150	000	2150	
3	D2	1500X2150	000	2150	DOUBLE SHUTTER
4	D3	2000X2150	000	2150	DOUBLE SHUTTER
5	D4	1350X2150	000	2150	DOUBLE SHUTTER
RS		2760X3000	000	3000	BEAM BOTTOM
G1		8650X3000	0/150	3000	BEAM BOTTOM
G2		5600X3000	0/150	3000	BEAM BOTTOM
W1		5600X2100	900	3000	BEAM BOTTOM
W2		1800X2100	900	3000	
W3		2500X2100	900	3000	
W4		920X2100	900	3000	
W5		1500X2100	900	3000	
W6		1200X2100	900	3000	
F1		1500X2100	900	3000	
V1		600X600	1550	2150	

REV DATE DESCRIPTION
REVISION

PROJECT

RMNCH PROJECT

Proposed 50
Bedded Hospital
at CHATTISGARH

TITLE

FIRST FLOOR PLAN

(COVERED AREA=1035 SQ. MT.)


TENDER DRAWING
(ARCH.)

HSCC/CHATTISGARH/TD/003 R-0
Drawing No. Rev.

HSCC/- 1:100 01-04-2013
Job No. Scale Date

App by Rev. by Prep. by

HSCC (INDIA) LIMITED
(A GOVERNMENT OF INDIA ENTERPRISES)
HSCC
NEW DELHI INDIA

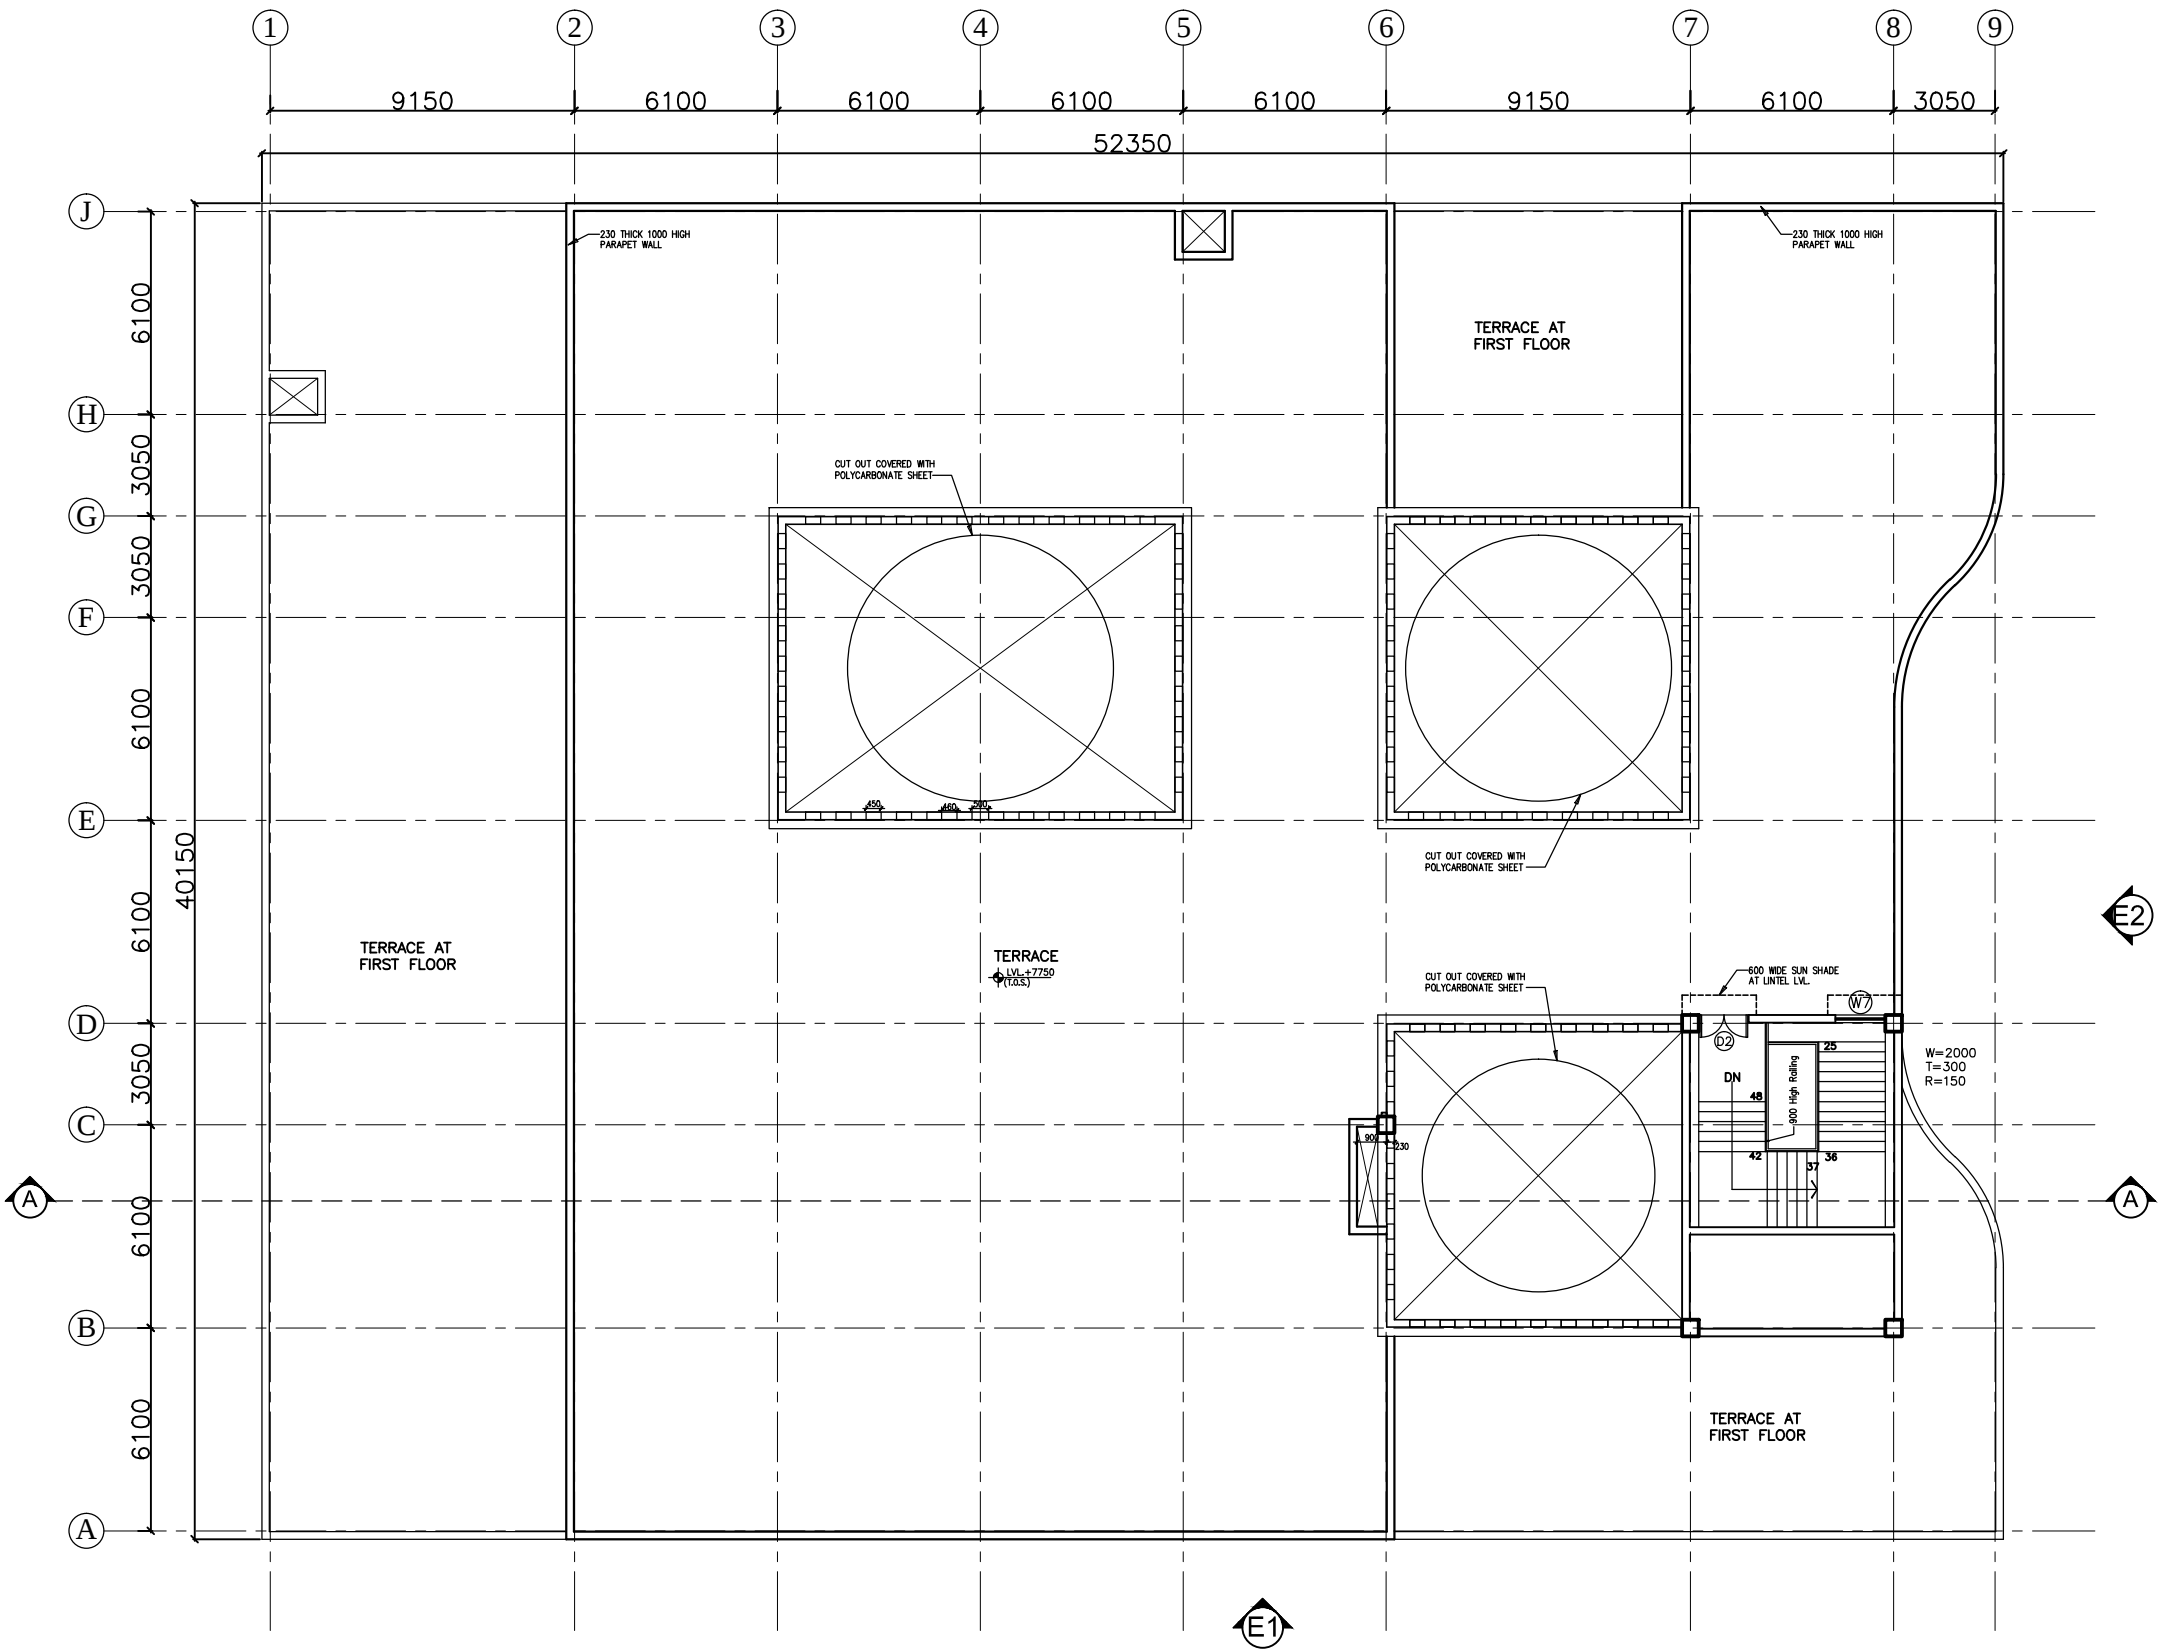

This drawing with all its contents is the sole intellectual property of the Hospital Services Consultancy Corporation (India) Ltd. Copying of this drawing or part thereof or its use in any form whatsoever without the written permission of HSCC is prohibited.

NOTES

DOOR AND WINDOW SCHEDULE

S.No	NAME	SIZE	CILL	LINTEL	REMARKS
1	TD	800X2150	000	2150	
2	D1	1000X2150	000	2150	
3	D2	1500X2150	000	2150	DOUBLE SHUTTER
4	D3	2000X2150	000	2150	DOUBLE SHUTTER
5	D4	1350X2150	000	2150	DOUBLE SHUTTER
RS	2760X3000	000	3000		BEAM BOTTOM
G1	8650X3000	0/150	3000		BEAM BOTTOM
G2	5600X3000	0/150	3000		BEAM BOTTOM
W1	5600X2100	900	3000		BEAM BOTTOM
W2	1800X2100	900	3000		
W3	2500X2100	900	3000		
W4	920X2100	900	3000		
W5	1500X2100	900	3000		
W6	1200X2100	900	3000		
F1	1500X2100	900	3000		
V1	600X600	1550	2150		

PROJECT

RMNCH PROJECT

Proposed 50
Bedded Hospital
at CHATTISGARH

TITLE

TERRACE PLAN

TENDER DRAWING (ARCH.)

HSCC/CHATTISGARH/TD/004
Drawing No.

R-0
Rev.

HSCC/-

Job No.

1:100

Scale

01-04-2013

Date

App by

Rev. by

Prep. by

HSCC (INDIA) LIMITED
(A GOVERNMENT OF INDIA ENTERPRISES)
HSCC
NEW DELHI INDIA

This drawing with all its contents is the sole intellectual property of the Hospital Services Consultancy Corporation (India) Ltd. Copying of this drawing or part thereof or its use in any form whatsoever without the written permission of HSCC is prohibited.

NOTES

DOOR AND WINDOW SCHEDULE

S.No	NAME	SIZE	CILL	LINTEL	REMARKS
1	TD	800X2150	000	2150	
2	D1	1000X2150	000	2150	
3	D2	1500X2150	000	2150	DOUBLE SHUTTER
4	D3	2000X2150	000	2150	DOUBLE SHUTTER
5	D4	1350X2150	000	2150	DOUBLE SHUTTER
RS	2760X3000	000	3000		BEAM BOTTOM
G1	8650X3000	0/150	3000		BEAM BOTTOM
G2	5600X3000	0/150	3000		BEAM BOTTOM
W1	5600X2100	900	3000		BEAM BOTTOM
W2	1800X2100	900	3000		
W3	2500X2100	900	3000		
W4	920X2100	900	3000		
W5	1500X2100	900	3000		
W6	1200X2100	900	3000		
F1	1500X2100	900	3000		
V1	600X600	1550	2150		

REV DATE DESCRIPTION

REVISION

PROJECT

RMNCH PROJECT

Proposed
50 Bedded Hospital
at NAGARI,
CHATTISGARH

TITLE

ELEVATIONS & SECTION




TENDER DRAWING
(ARCH.)

HSCC/NAGARI/TD/005 R-0
Drawing No. Rev.



HSCC/- 1:100 12-04-2013
Job No. Scale Date

App by Rev. by Prep. by

HSCC (INDIA) LIMITED
(A GOVERNMENT OF INDIA ENTERPRISES)
HSCC
NEW DELHI INDIA

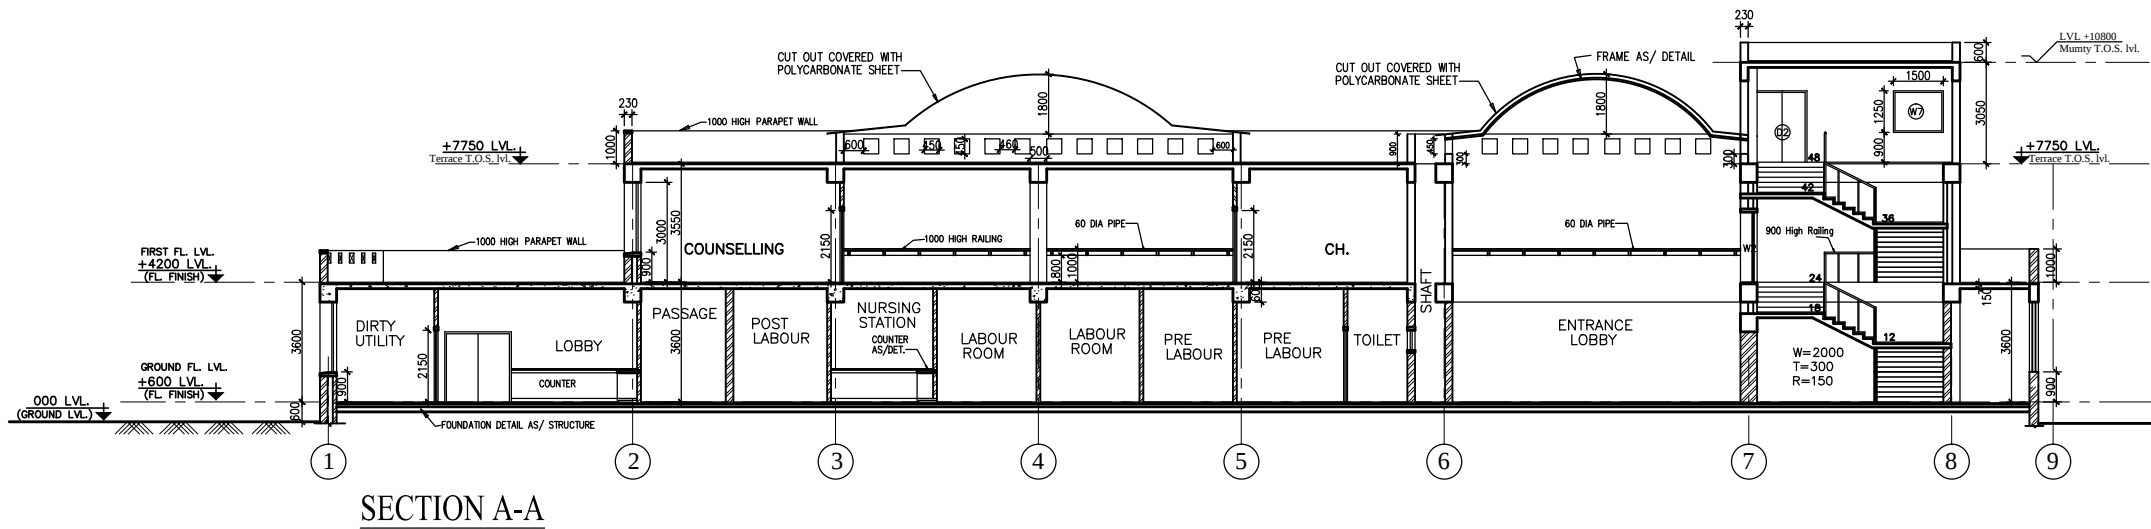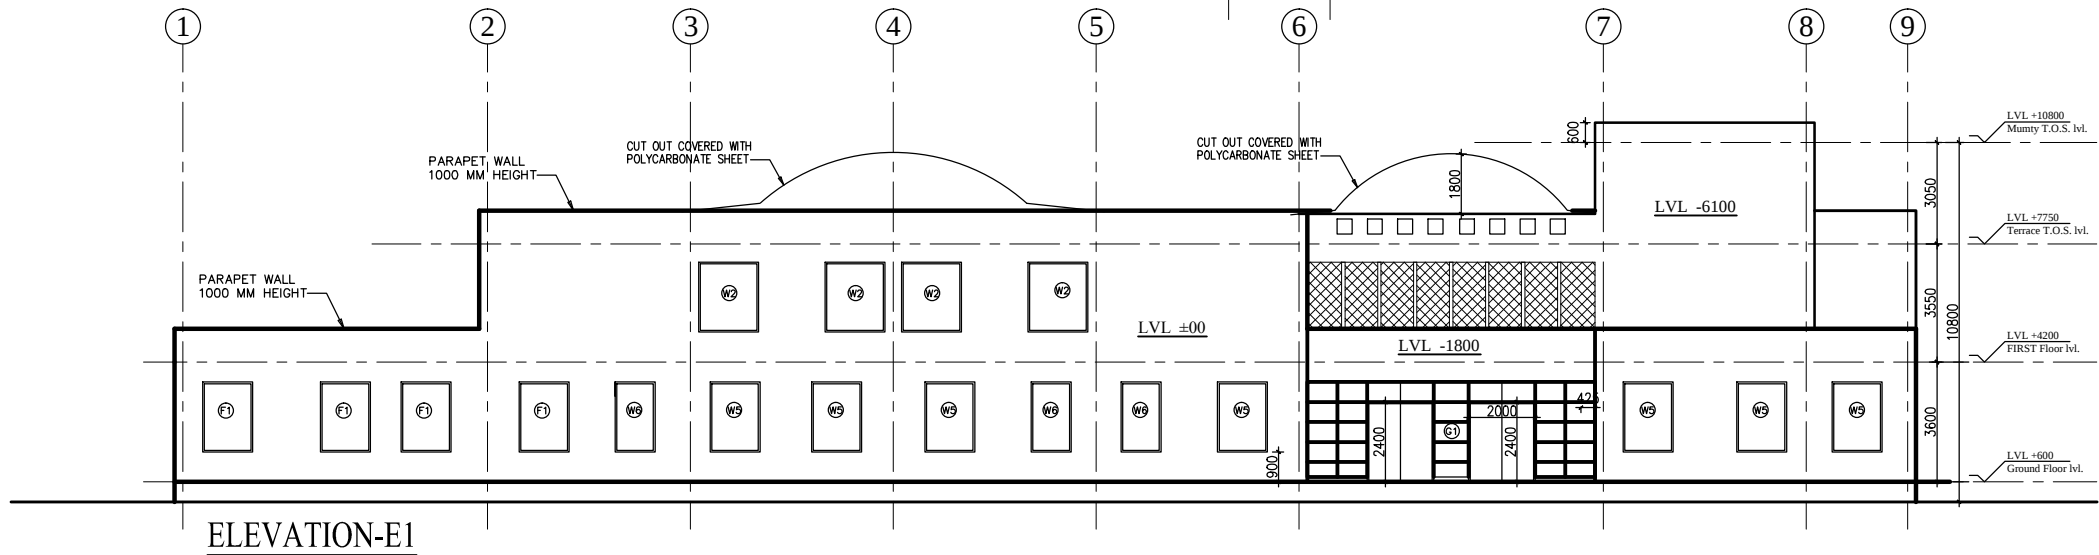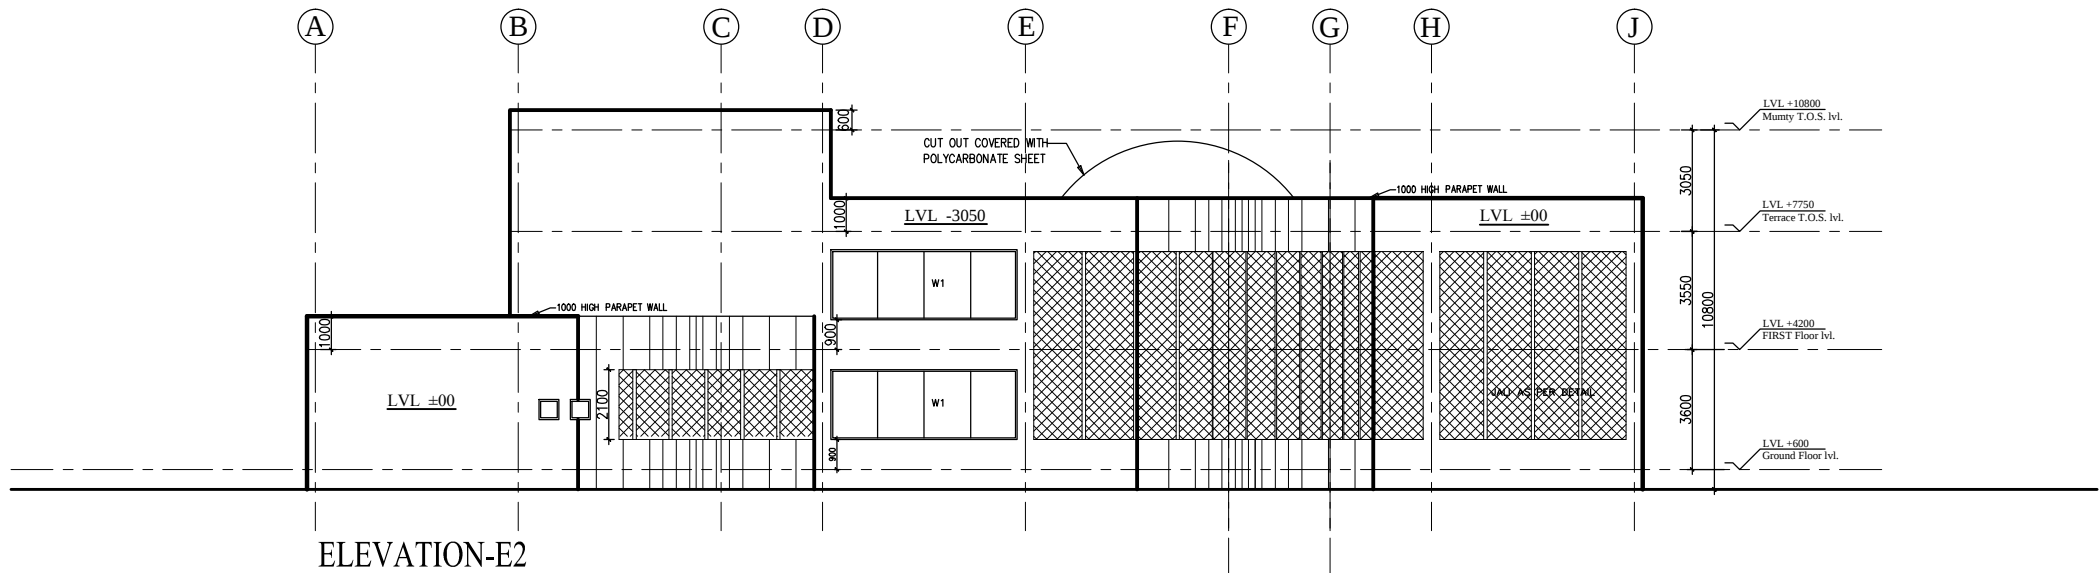

FOOTING SCHEDULE					
S.No	MD.	SIZE(xxy)	TH. (A)	TH. (B)	REMARKS
1	F1	1500x1500	200	300	1A/FEBD
2	F2	1800x1800	250	350	1A/FEBD
3	F3	2250x2250	250	450	1A/FEBD
4	F4	2700x2750	250	450	1A/FEBD
5	F5	3000x3000	300	500	1A/FEBD
6	F6	3200x3200	300	550	1A/FEBD
7	F7	3700x3700	300	600	1A/FEBD

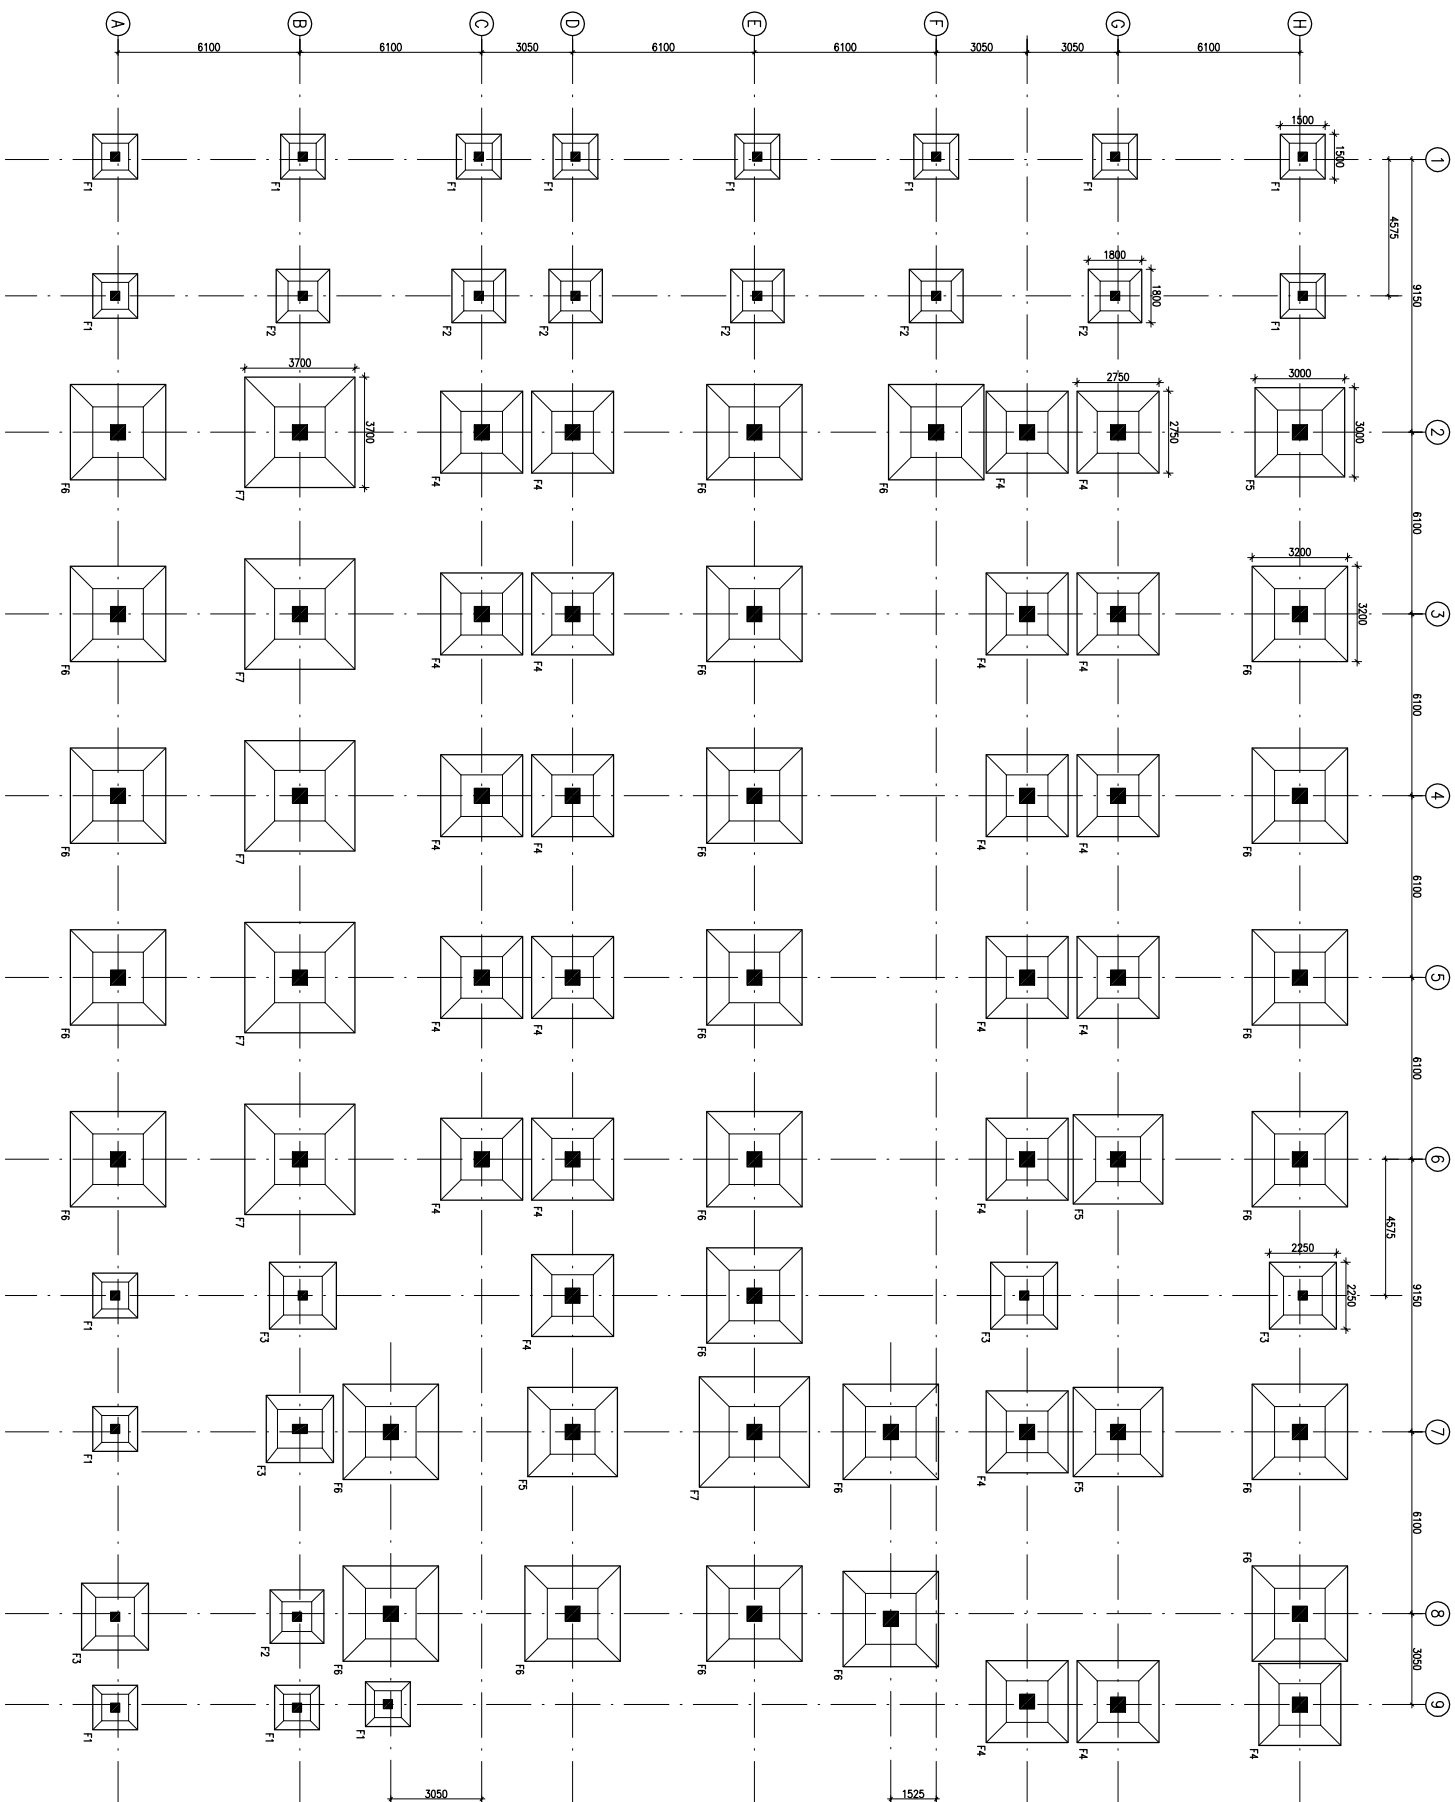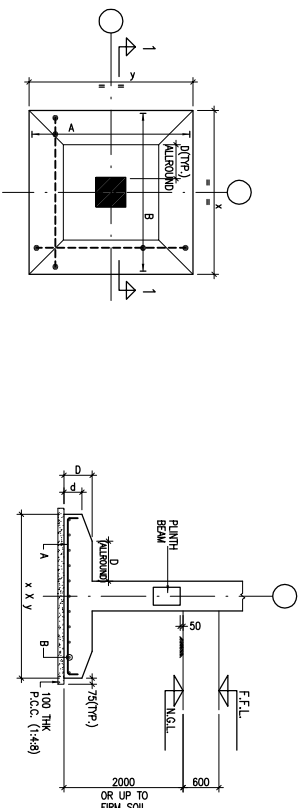

NOTES	
This drawing with all its contents is the sole intellectual property of the Hospital Services Consultancy Corporation (Inkd) Ltd. Copying of this drawing or part thereof or its use in any form whatsoever without the written permission of HSCC is prohibited.	

1. ALL DIMENSIONS ARE IN mm & LVS IN m.
2. READ IN CONJUNCTION WITH RELEVANT ARCH. Dwg.
3. FINISHED FLOOR LVL TO BE CONFINED AS/ARCH. DRESS. THE SLAB TOP LEVEL TO BE WORKED OUT SUITABLY CONSIDERING FLOOR FINISH THICKNESS.
4. CLEAR COVER OF R/F TO BE AS BELOW:-
 FOUNDATION = 50mm
 COLUMN = 40mm
 BEAM = 30mm
 SLAB = 25mm
5. CONC. MIX. TO BE M-25 FOR ALL RCC WORK AS PER IS:456-2000
6. ALL R/F BARS TO BE Fe250 Mpa. HYSD
7. ALL LVL LENGTHS = 50xSMALLER BAR & FOR TMT STEEL AS PER IS:1786.
8. DEVELOPMENT LENGTH = 50xBAR ϕ .
9. SFB ASSUMED 120 N/MM² AT 2.0 METER BELOW N.G.L.

1	08/04/13	OVERALL REUSED AS PER ARCH.
0	27/02/13	FOR TENDER
REV DATE		DESCRIPTION

PROJECT

PROPOSED
50 BEDDED HOSPITAL
RMNCH PROJECT,
CHATTISGARH

TITLE

FOUNDATION LAYOUT PLAN

HSCC/RMNC/D&E/ST-T-101

Drawing No.	REV. 1
-------------	--------


JOB No.	SCALE	DATE
---------	-------	------

APPROVED	REVIEWED	PREPARED
----------	----------	----------


HSCC INDIA LTD.
(A GOVERNMENT OF INDIA ENTERPRISE)

NEW DELHI

INDIA

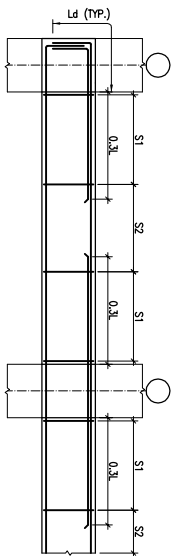

TYP. BEAM R/F DETAILS

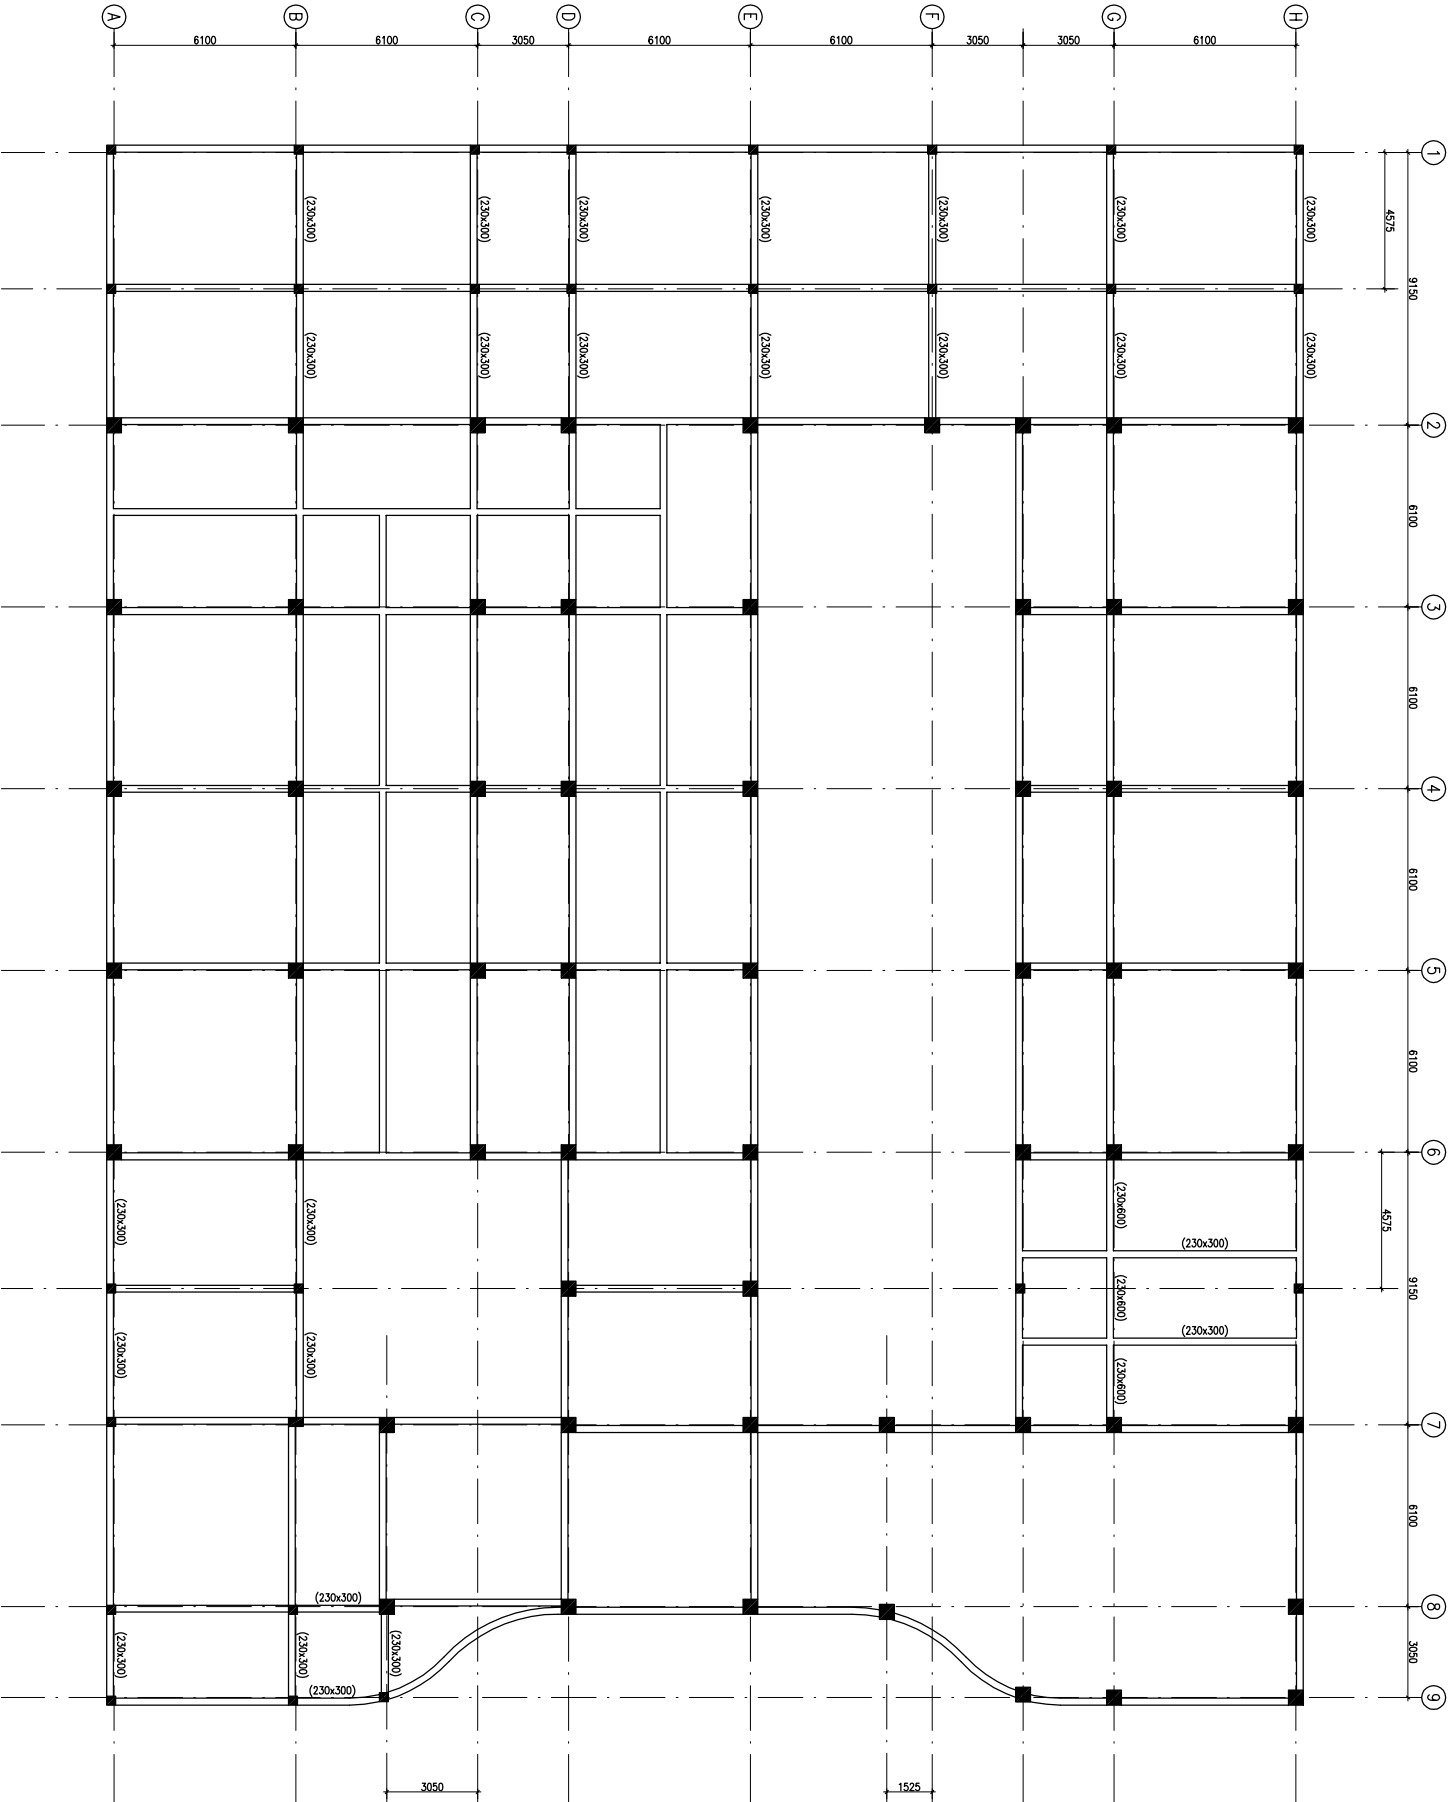

PLINTH BEAM FRAMING PLAN
(ALL BEAMS SIZE 230x450 UNO.)



This drawing with all its contents is the sole intellectual property of the Hospital Services Consultancy and is not to be reproduced, stored in a retrieval system, or transmitted in any form or by any means, electronic, mechanical, photocopying, recording, or by any information storage and retrieval system, without the written permission of HSCC. It is prohibited.

NOTES

1. ALL DIMENSIONS ARE IN mm & LWS IN m.
2. READ IN CONJUNCTION WITH RELEVANT ARCH. DRG.
3. FINISHED FLOOR LVL TO BE CONFIRMED AS/ARCH. DRGS. THE SLAB TOP LEVEL TO BE WORKED OUT SUITABLY CONSIDERING FLOOR FINISH THICKNESS.
4. CLEAR COVER OF R/F TO BE AS BELOW--
FOUNDATION = 50mm
COLUMN = 40mm
BEAM = 30mm
SLAB = 25mm
5. CONC. MIX. TO BE M-25 FOR ALL RCC WORK AS PER IS:456-2000
6. ALL R/F BARS TO BE Fe500 Mpa. HYSD OR TMT STEEL AS PER IS:1786.
7. ALL LAP LENGTHS = 50xSMALLER BAR Ø. SITE REQUIREMENT
8. DEVELOPMENT LENGTH = 50xBAR Ø.

REV#	DATE	DESCRIPTION
1	08.04.13	OVERALL REISED AS PER ARCH.
0	27.02.13	FOR TENDER

REVISION

PROJECT

PROPOSED
50 BEDDED HOSPITAL
RMNCH PROJECT,
CHATTISGARH

TITLE

PLINTH BEAM FRAMING PLAN

HSCC/RMNC/D&E/ST-T-103

Drawing No. REV. 1

HSCC/RMNC 1:1/25 FEB-2013

JOB No. SCALE DATE

APPROVED REVIEWED PREPARED

HSCC INDIA LTD.
A GOVERNMENT OF INDIA ENTERPRISE

HSCC
NEW DELHI INDIA



This drawing with all its contents is the sole intellectual property of the Hospital Services Consultancy and is not to be reproduced, stored in a retrieval system, or transmitted in any form or by any means, electronic, mechanical, photocopying, recording, or otherwise, without the prior written permission of HSCC. It is prohibited.

NOTES

- 1. ALL DIMENSIONS ARE IN mm & LWS IN m.
- 2. READ IN CONJUNCTION WITH RELEVANT ARCH. DRG.
- 3. FINISHED FLOOR LVL TO BE CONFIRMED AS/ARCH. DRGS. THE SLAB TOP LEVEL TO BE WORKED OUT SUITABLY CONSIDERING FLOOR FINISH THICKNESS.
- 4. CLEAR COVER OF R/F TO BE AS BELOW:-
FOUNDATION = 50mm
COLUMN = 40mm
BEAM = 30mm
SLAB = 25mm
- 5. CONC. MK. TO BE M-25 FOR ALL RCC WORK AS PER IS:456-2000
- 6. ALL R/F BARS TO BE Fe500 Mpa. HYSD OR TMT STEEL AS PER IS:1786.
- 7. ALL LAP LENGTHS = 50xSMALLER BAR Ø. SITE REQUIREMENT
- 8. DEVELOPMENT LENGTH = 50xBAR Ø.

REVISION	
REV	DESCRIPTION
1	08.04.13 OVERALL REISED AS PER ARCH.
0	27.02.13 FOR TENDER

PROJECT

PROPOSED
50 BEDDED HOSPITAL
RMNCH PROJECT,
CHATTISGARH

TITLE

COLUMN LAYOUT PLAN

HSCC/RMNC/DAE/ST-T-102


Drawing No. REV. 1

HSCC/RMNC	1:125	FEB-2013
JOB No.	SCALE	DATE

APPROVED	REVIEWED	PREPARED

HSCC INDIA LTD.
A GOVERNMENT OF INDIA ENTERPRISE

 HSCC
NEW DELHI INDIA




COLUMN MKD. C1




COLUMN MKD. C2




COLUMN MKD. C3

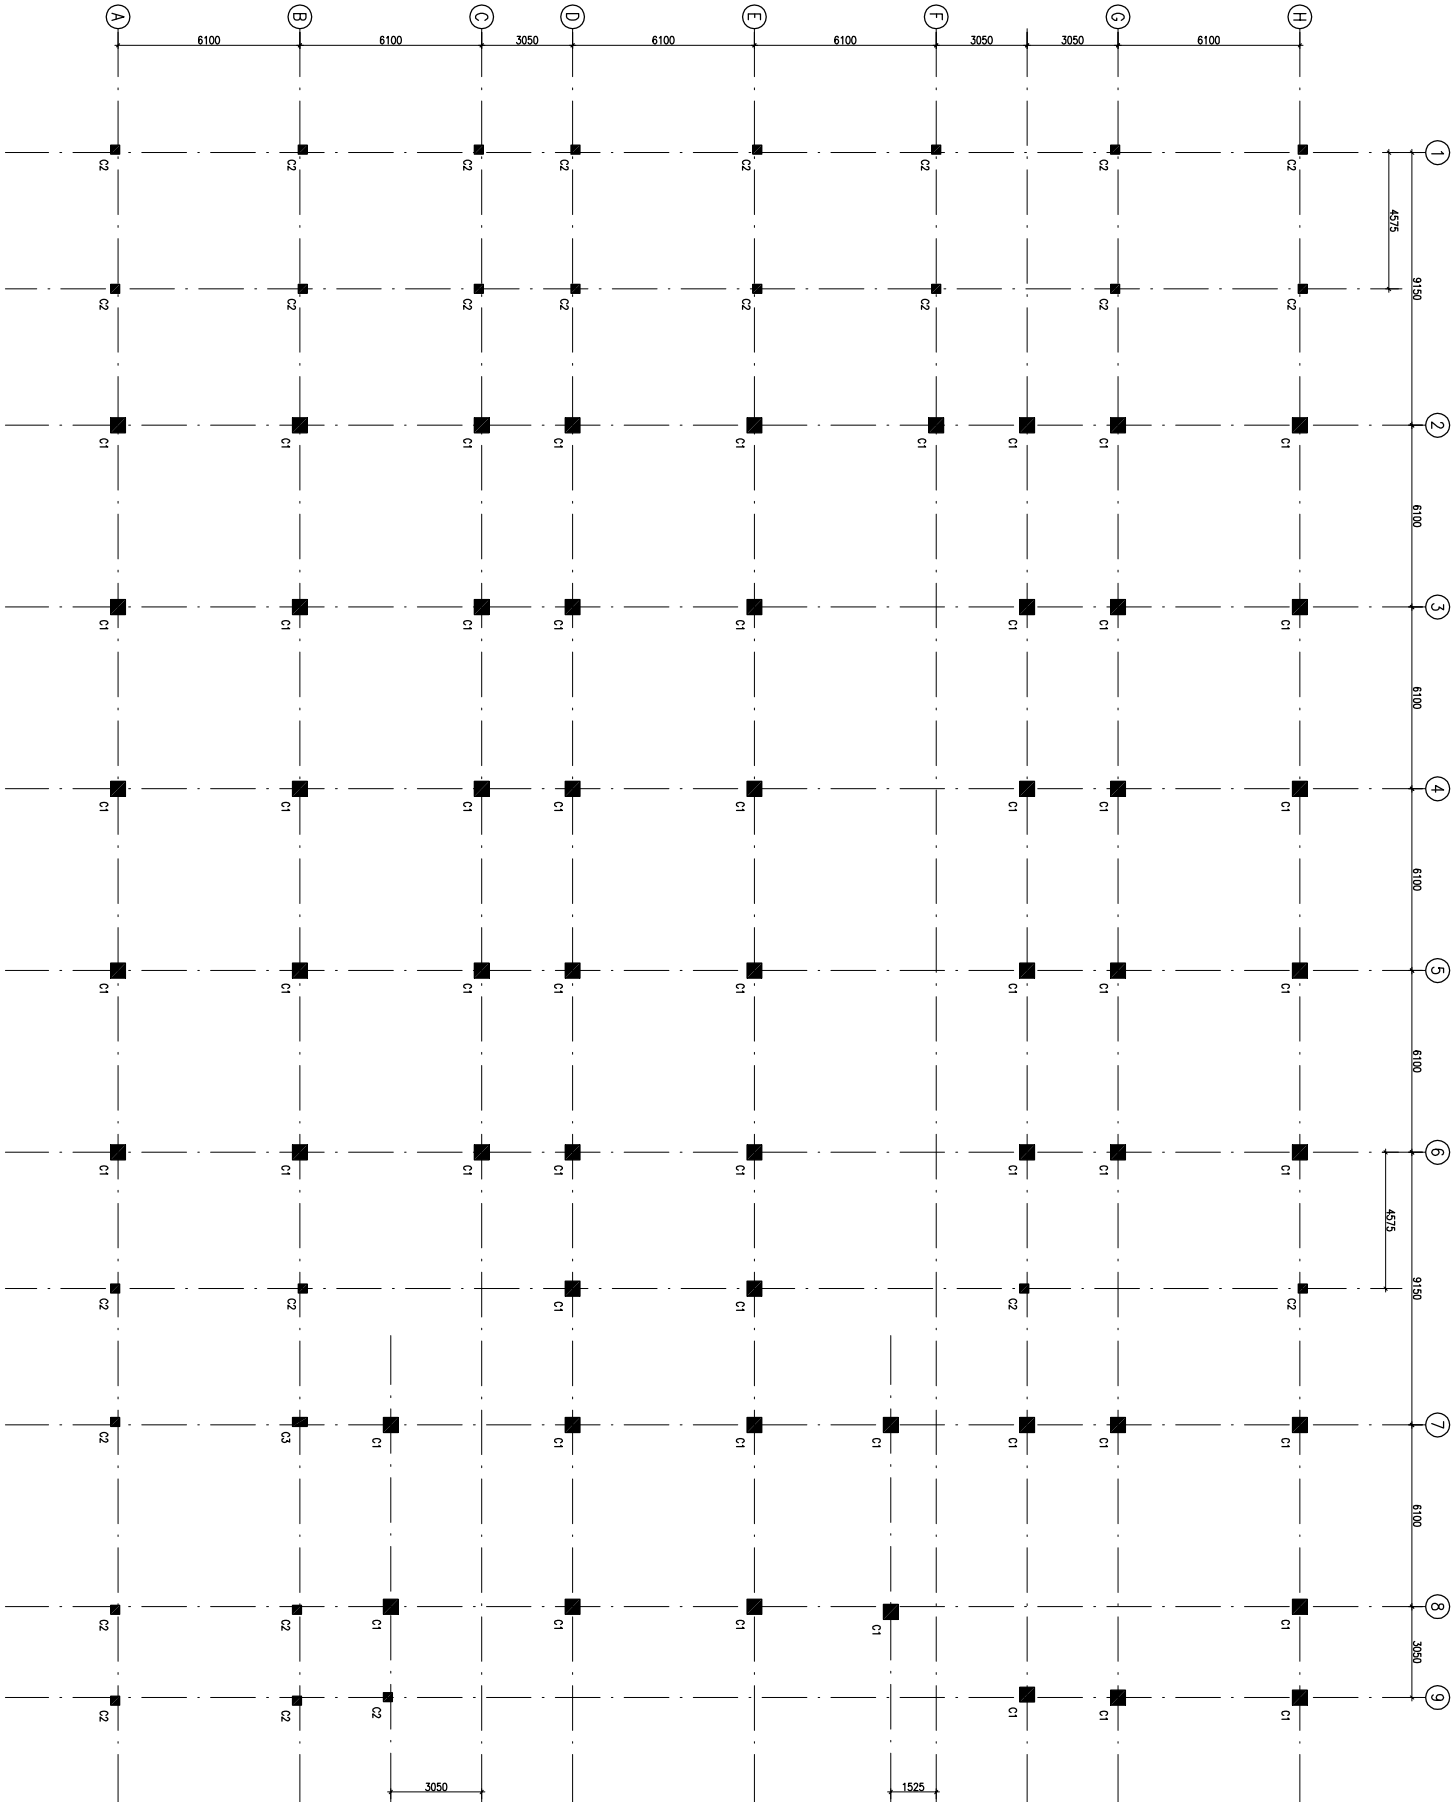


COLUMN LAYOUT PLAN

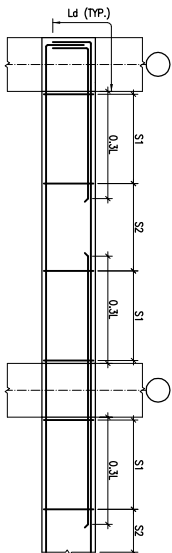


TYP. BEAM R/F DETAILS

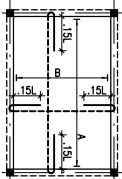

TYP. SUNKEN SLAB R/F DETAIL

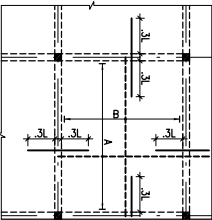

TYP. SLAB R/F DETAIL

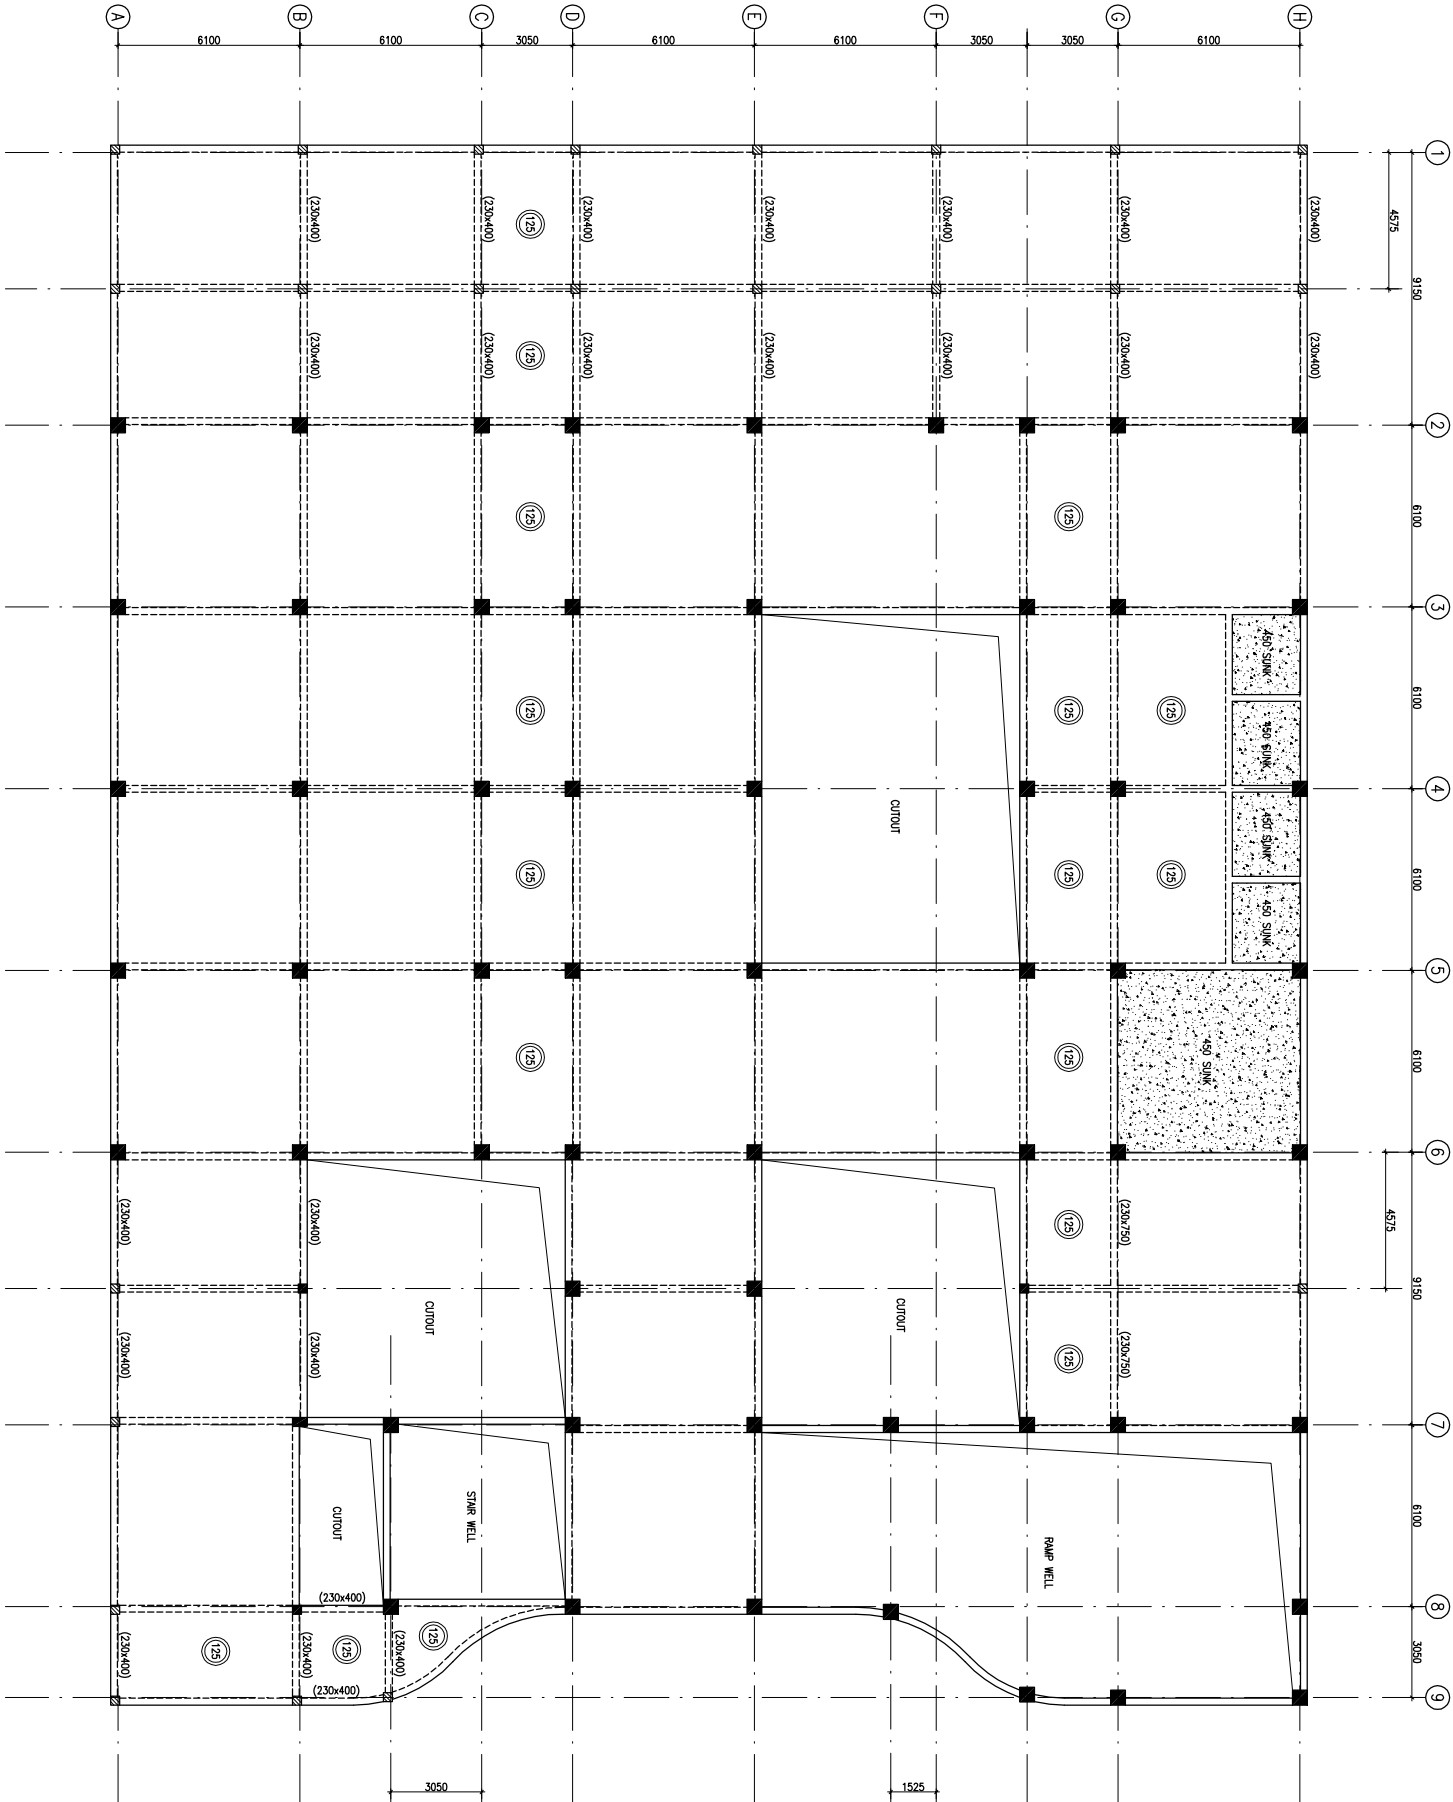

FIRST FLOOR BEAM FRAMING PLAN
(ALL BEAMS SIZE 230x400 U.N.O.) & (SLAB THICKNESS 150mm U.N.O.)



This drawing with all its contents is the sole intellectual property of the Hospital Services Consultancy (HSCC) and shall remain the property of this company or part thereof or its use in any form whatsoever without the written permission of HSCC is prohibited.

NOTES

1. ALL DIMENSIONS ARE IN mm & LVS IN m.
2. READ IN CONJUNCTION WITH RELEVANT ARCH. DRG.
3. FINISHED FLOOR LVL TO BE CONFIRMED AS/ARCH. DRGS. THE SLAB TOP LEVEL TO BE WORKED OUT SUITABLY CONSIDERING FLOOR FINISH THICKNESS.
4. CLEAR COVER OF R/F TO BE AS BELOW--
FOUNDATION = 50mm
COLUMN = 40mm
BEAM = 30mm
SLAB = 25mm
5. CONC. MIX. TO BE M-25 FOR ALL RCC WORK AS PER IS:456-2000
6. ALL R/F BARS TO BE Fe500 Mpa. HYSD OR TMT STEEL AS PER IS:1786.
7. ALL LAP LENGTHS = 50xSMALLER BAR Ø. SITE REQUIREMENT
8. DEVELOPMENT LENGTH = 50xBAR Ø.

REV#	DATE	DESCRIPTION
1	08.04.13	OVERALL REISED AS PER ARCH.
0	27.02.13	FOR TENDER

REVISION

PROJECT

PROPOSED
50 BEDDED HOSPITAL
RMNCH PROJECT,

CHATTISGARH

TITLE

FIRST FLOOR BEAM FRAMING PLAN

HSCC/RMNC/DAE/ST-T-104

Drawing No. REV. 1

HSCC/RMNC 1:1/25 FEB-2013

JOB No. SCALE DATE

APPROVED	REVIEWED	PREPARED
----------	----------	----------

HSCC INDIA LTD.

(A) GOVERNMENT OF INDIA ENTERPRISED


HSCC
NEW DELHI INDIA




This drawing with all its contents is the sole intellectual property of the Hospital Services Consultancy (HSCC) and shall remain the property of this entity or part thereof or its use in any form whatsoever without the written permission of HSCC is prohibited.

NOTES


1. ALL DIMENSIONS ARE IN mm & LVS IN m.
2. READ IN CONJUNCTION WITH RELEVANT ARCH. DRG.
3. FINISHED FLOOR LVL TO BE CONFIRMED AS/ARCH. DRGS. THE SLAB TOP LEVEL TO BE WORKED OUT SUITABLY CONSIDERING FLOOR FINISH THICKNESS.
4. CLEAR COVER OF R/F TO BE AS BELOW:-
FOUNDATION = 50mm
COLUMN = 40mm
BEAM = 30mm
SLAB = 25mm
5. CONC. MIX. TO BE M-25 FOR ALL RCC WORK AS PER IS:456-2000
6. ALL R/F BARS TO BE Fe500 Mpa. HYSD OR TMT STEEL AS PER IS:1786.
7. ALL LAP LENGTHS = 50xSMALLER BAR Ø. SITE REQUIREMENT
8. DEVELOPMENT LENGTH = 50xBAR Ø.

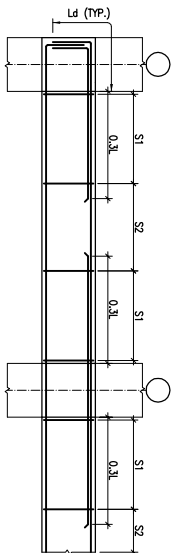


TYP. BEAM R/F DETAILS

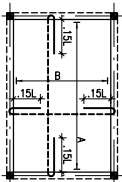

TYP. SUNKEN SLAB R/F DETAIL

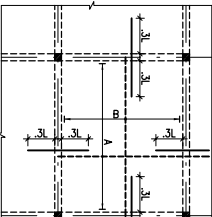

TYP. SLAB R/F DETAIL

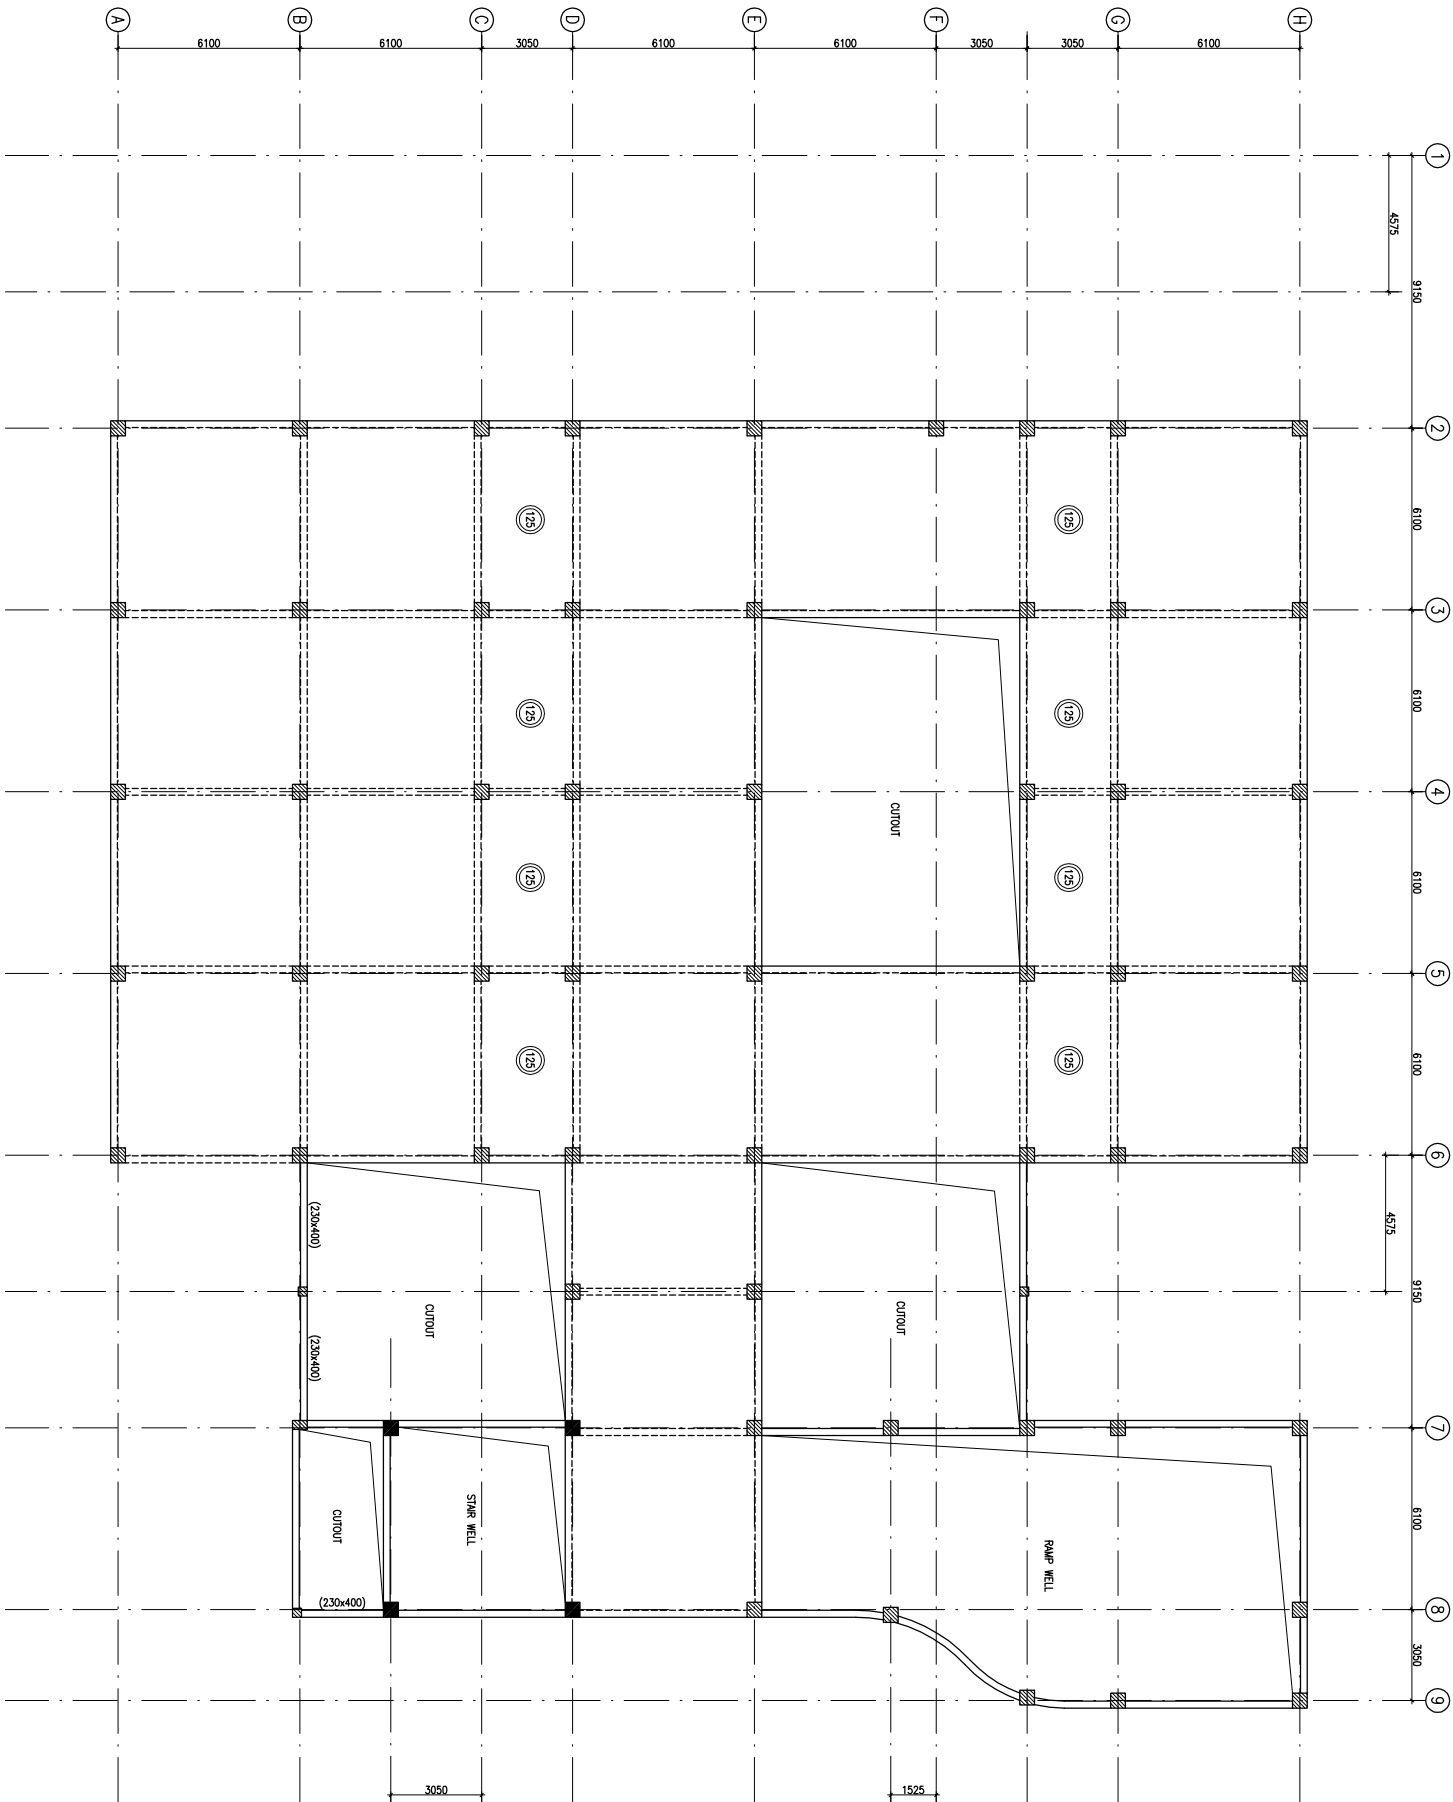

TERRACE LVL BEAM FRAMING PLAN
(ALL BEAMS SIZE 230x400 U.N.O.) & (SLAB THICKNESS 150mm U.N.O.)

TITLE

CHATTISGARH

PROPOSED
50 BEDDED HOSPITAL
RMNCH PROJECT,

PROJECT

REVISION

REV	DATE	DESCRIPTION
1	08.04.13	OVERALL REVISED AS PER ARCH.
0	27.02.13	FOR TENDER

TERRACE LVL BEAM FRAMING PLAN

HSCC/RMNC/D&E/ST-T-105


Drawing No. REV. 1

HSCC/RMNC	1:125	FEB-2013
JOB No.	SCALE	DATE

APPROVED	REVIEWED	PREPARED
----------	----------	----------

HSCC INDIA LTD.
A GOVERNMENT OF INDIA ENTERPRISE

 HSCC
NEW DELHI INDIA



This drawing with all its contents is the sole intellectual property of the Hospital Services Consultancy Corporation (HSCC). Copying of this drawing or part thereof, or its use in any form whatsoever without the written permission of HSCC is prohibited.

L E C U E N U .	
1	100 Ø CI SOL. & VENT PIPE
2	100Ø CI WASTE & VENT PIPE
3	100Ø CI SOL. PIPE
4	100Ø CI. WASTE PIPE
5	50Ø UPVC SOL. PIPE
6	40Ø UPVC WASTE PIPE
7	32Ø UPVC WASTE PIPE
8	Ø UTW DN. TAKE
9	Ø TW DN. TAKE
10	100 Ø S.W. PIPE
F.T	FLOOR TRAP - 100x100
F.D	FLOOR DRAIN 50Ø
FCQ	FLOOR CLEAN OUT
CP	CLEAN OUT PLUG
⊗	VALVE
MH	MANHOLE (900x600)mm
GT	GULLY TRAP (300x300)mm

PROJECT	RMNCH PROJECT
	Proposed 50 Bedded Hospital (G+1) at CHATTISGARH

TITLE - PLUMBING & TENDER DRAWING

Ground Floor Plan

HSCC/D&E/BEMETARA/TD/PL-01
Drawing No.

Job No.	Scale	Date
App. by	Rev. by	Prep. by

HSCC (INDIA) LIMITED
(A GOVERNMENT OF INDIA ENTERPRISE)

HSCC

NEW DELHI INDIA

NOTES

LEGEND:

1	100 Ø CI SOIL & VENT PIPE
2	1000 CI WASTE & VENT PIPE
3	1000 Ø CI SOIL PIPE
4	1000 Ø CI WASTE PIPE
5	500 Ø PVC SOIL PIPE
6	400 Ø PVC WASTE PIPE
7	320 Ø PVC WASTE PIPE
8	Ø UTW DN TAKE
9	Ø TW DN TAKE
10	100 Ø S/W PIPE
F.T	FLOOR TRAP 100x100
F.D	FLOOR DRAIN 50Ø
F.O	FLOOR CLEAN OUT
COP	CLEAN OUT PLUG
×	WAVE
MH	MANHOLE (900x800)mm
GI	GULLY TRAP (300x300)mm
	
	

PROJECT

RMNCH PROJECT
Proposed 50 Bedded
Hospital (G+1) at
CHATTISGARH

TITLE - PLUMBING & FIRE

TENDER DRAWING

First Floor Plan

HSCC/D&E/BEMETARA/TD/PL-02

Drawing No.

Job No. _____

App by	Rev. by	Prep. by
--------	---------	----------

1. BASED ON THIS DRAWING EXECUTING AGENCY WILL PLEASE SHOP
DRAWING AFTER INCORPORATING THE CHANGES AS PER SITE CONDITION
FOR THE APPROVAL OF ENGINEER-IN-CHARGE BEFORE START OF WORK.
2. THE NO. & LOCATION OF FIXTURES TO BE FINALIZED BEFORE EXECUTION
WITH MEDICAL IN-CHARGE OF PROJECT.

This drawing with all its
contents is the sole
intellectual property of this
company and shall remain
the property of this
company. No part of this
drawing or part hereof shall
be reproduced or
transmitted in any form or
by any means electronic or
mechanical, including
photocopying, recording,
or by any information
storage and retrieval
system, without the written
permission of HSCC is prohibited.

NOTES

LEVEL.

1	100 Ø CI SOIL & VENT PIPE
2	100Ø CI.WASTE & VENT PIPE
3	100Ø CI. SOIL PIPE
4	100Ø CI. WASTE PIPE
5	50Ø UPVC SOIL PIPE
6	40Ø UPVC WASTE PIPE
7	32Ø UPVC WASTE PIPE
8	Ø UTW DN.TAKE
9	Ø TW DN.TAKE
10	100 Ø S.W. PIPE
F.T	FLOOR TRAP 100x100
F.D	FLOOR DRAIN 50Ø
F.O	FLOOR CLEAN OUT
COP	CLEAN OUT PLUG
×	VALVE
MH	MANHOLE (900x600)mm
GT	GULLY TRAP(300x300)mm

REV	DATE	DESCRIPTION

PROJECT

RMNCH PROJECT
Proposed 50 Bedded
Hospital (G+1) at
CHATTISGARH


TITLE - PLUMBING & FIRE

TENDER DRAWING

Terrace
Plan


HSCC/D&E/BH/METABA/TD/PL-03
Drawing No.

Job No.	Scale	Date
App by	Rev. by	Prep. by

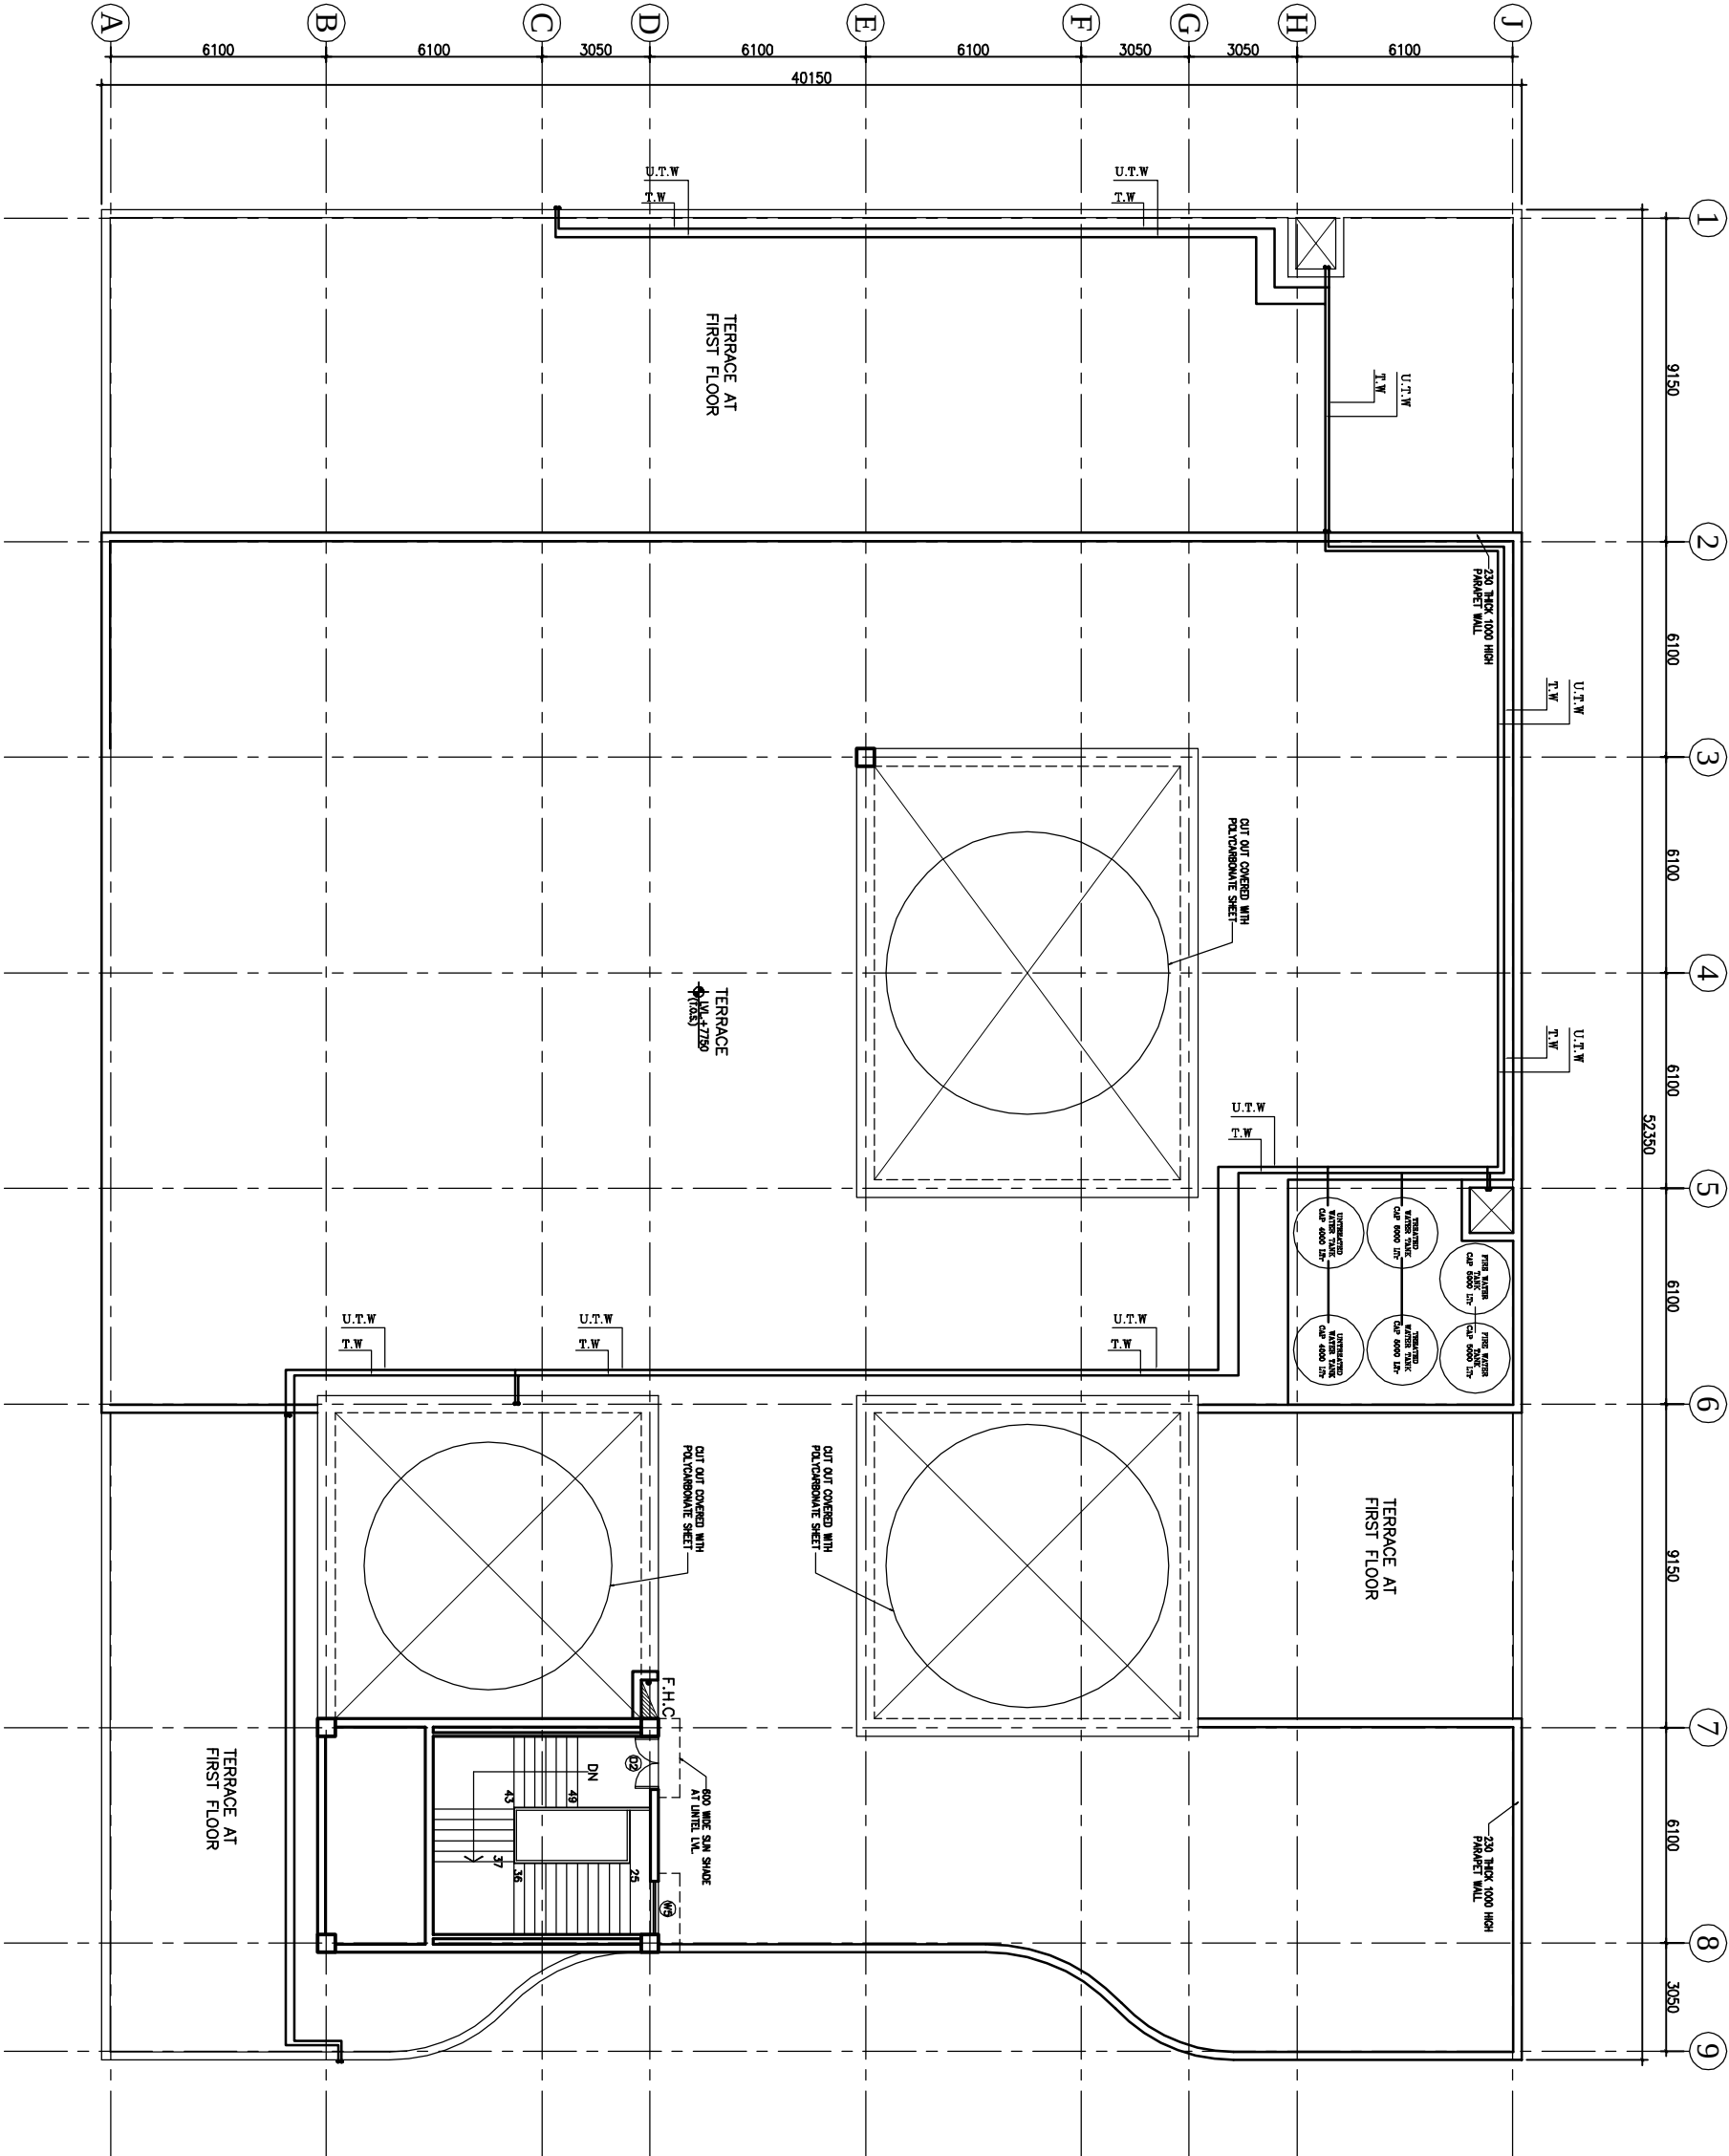

NOTES


REV	DATE	DESCRIPTION	
REVISION			
PROJECT			
RMNCH PROJECT			
Proposed 50 Bedded Hospital of CHATTISGARH			
TITLE			
MODEL PLANS (G+1)			
TENDER DRAWING			
First Floor Plan			
ELECTRICAL LAYOUT			
(COVERED AREA=1035 SQ. MT.)			
HSCC/D&E/CHATTISGARH/TD/EL-02 R-0			
Drawing No.			Rev.
HSCC/-	NTS		
Job No.	Scale	Date	
App. by	Rev. by	Prep. by	

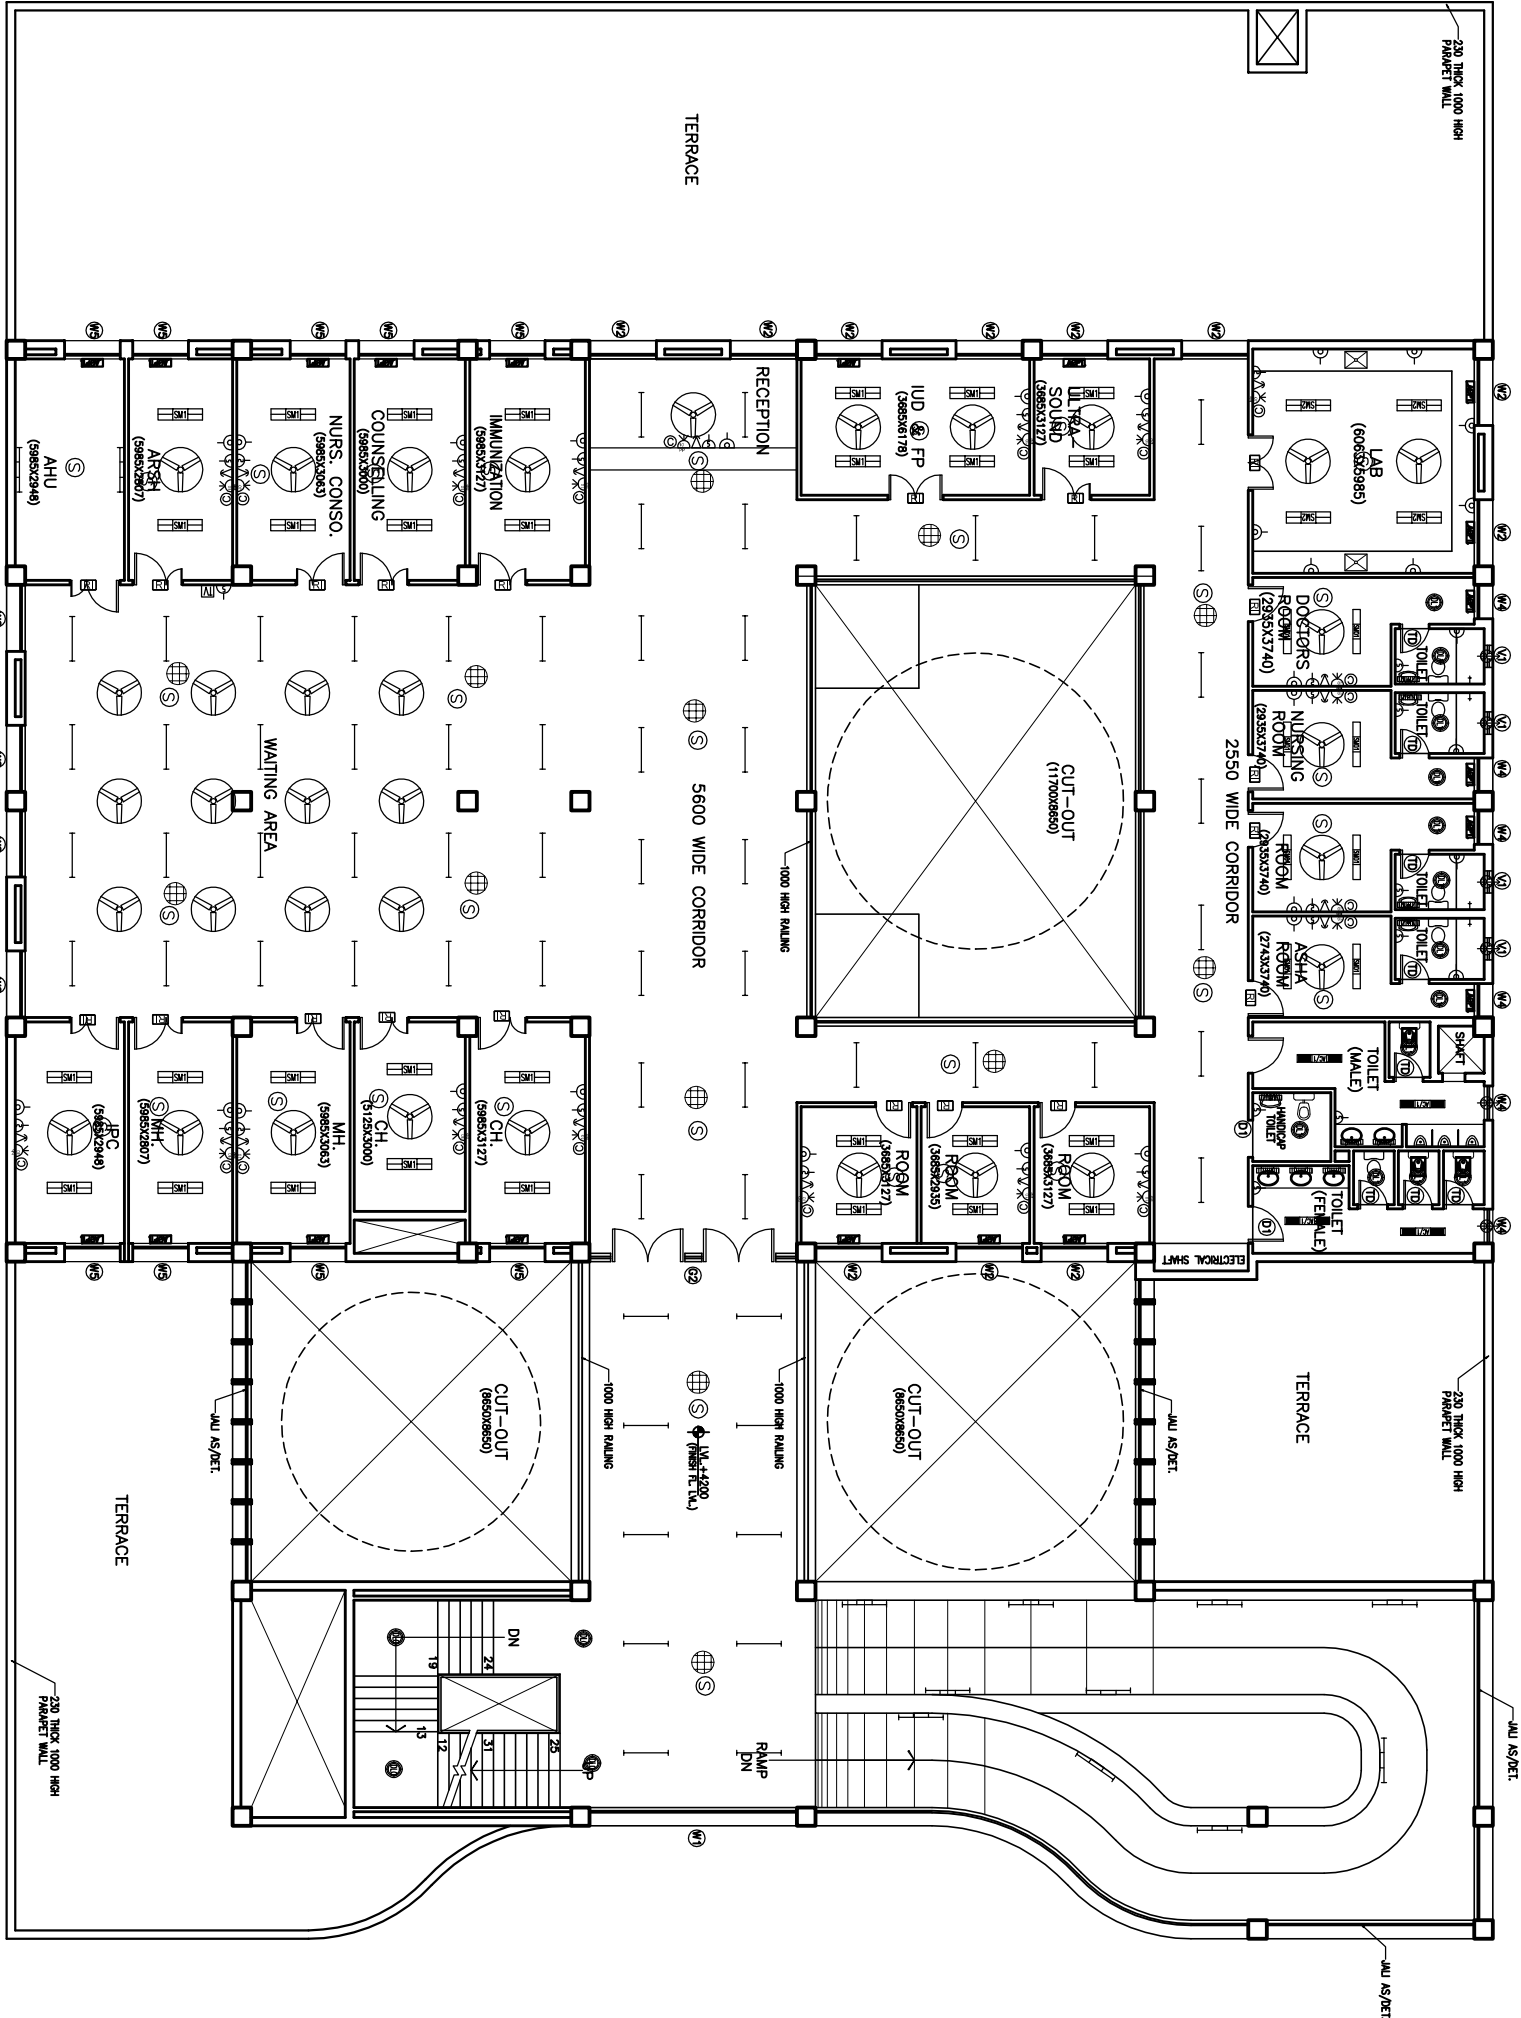

FIRST FLOOR PLAN

This drawing with all its contents is the sole intellectual property of the Hospital Services Consultancy Corporation (India) Ltd. Copying of this drawing or part thereof or its use in any form and/or use without the written permission of HSCC is prohibited.

NOTES

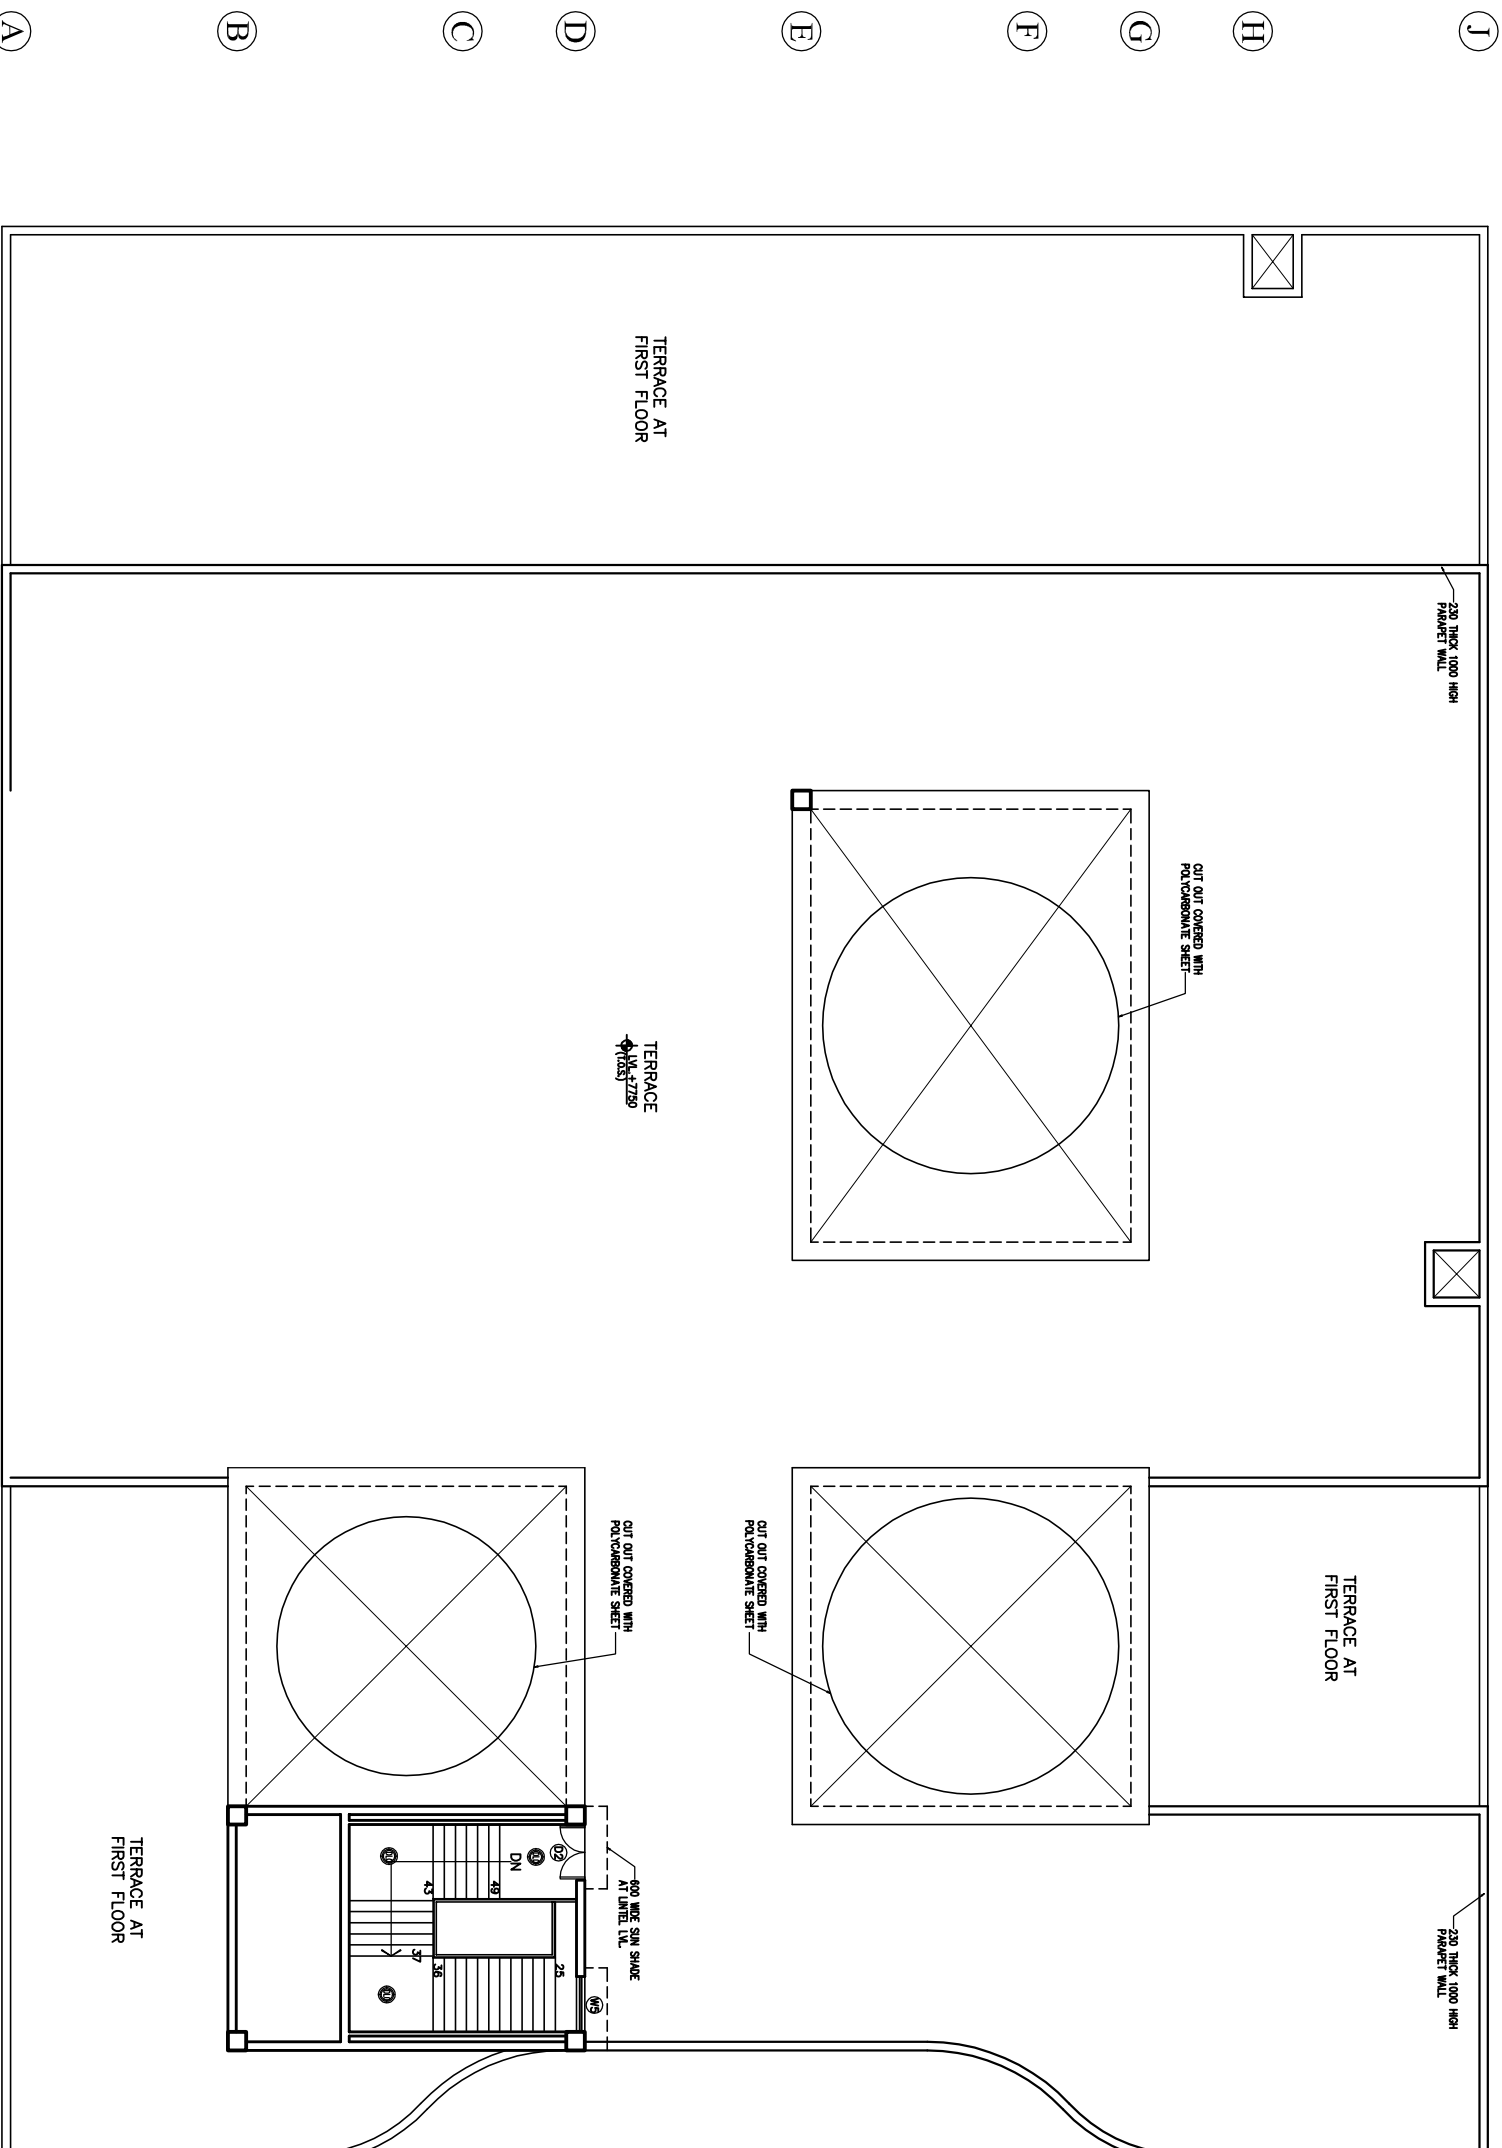

REV	DATE	DESCRIPTION			
REVISION					

PROJECT

RMNCH PROJECT

Proposed
50 Bedded Hospital
at
CHATTISGARH

TITLE


MODEL PLANS (G+1)

TENDER DRAWING

Terrace Plan

ELECTRICAL LAYOUT


HSOC/D&E/CHA/TTSGARH/IDEL-03 R-0		Rev.
Drawing No.		
BSOC/-	NTS	
Job No.	Scale	Date
App by	Rev. by	Prep. by

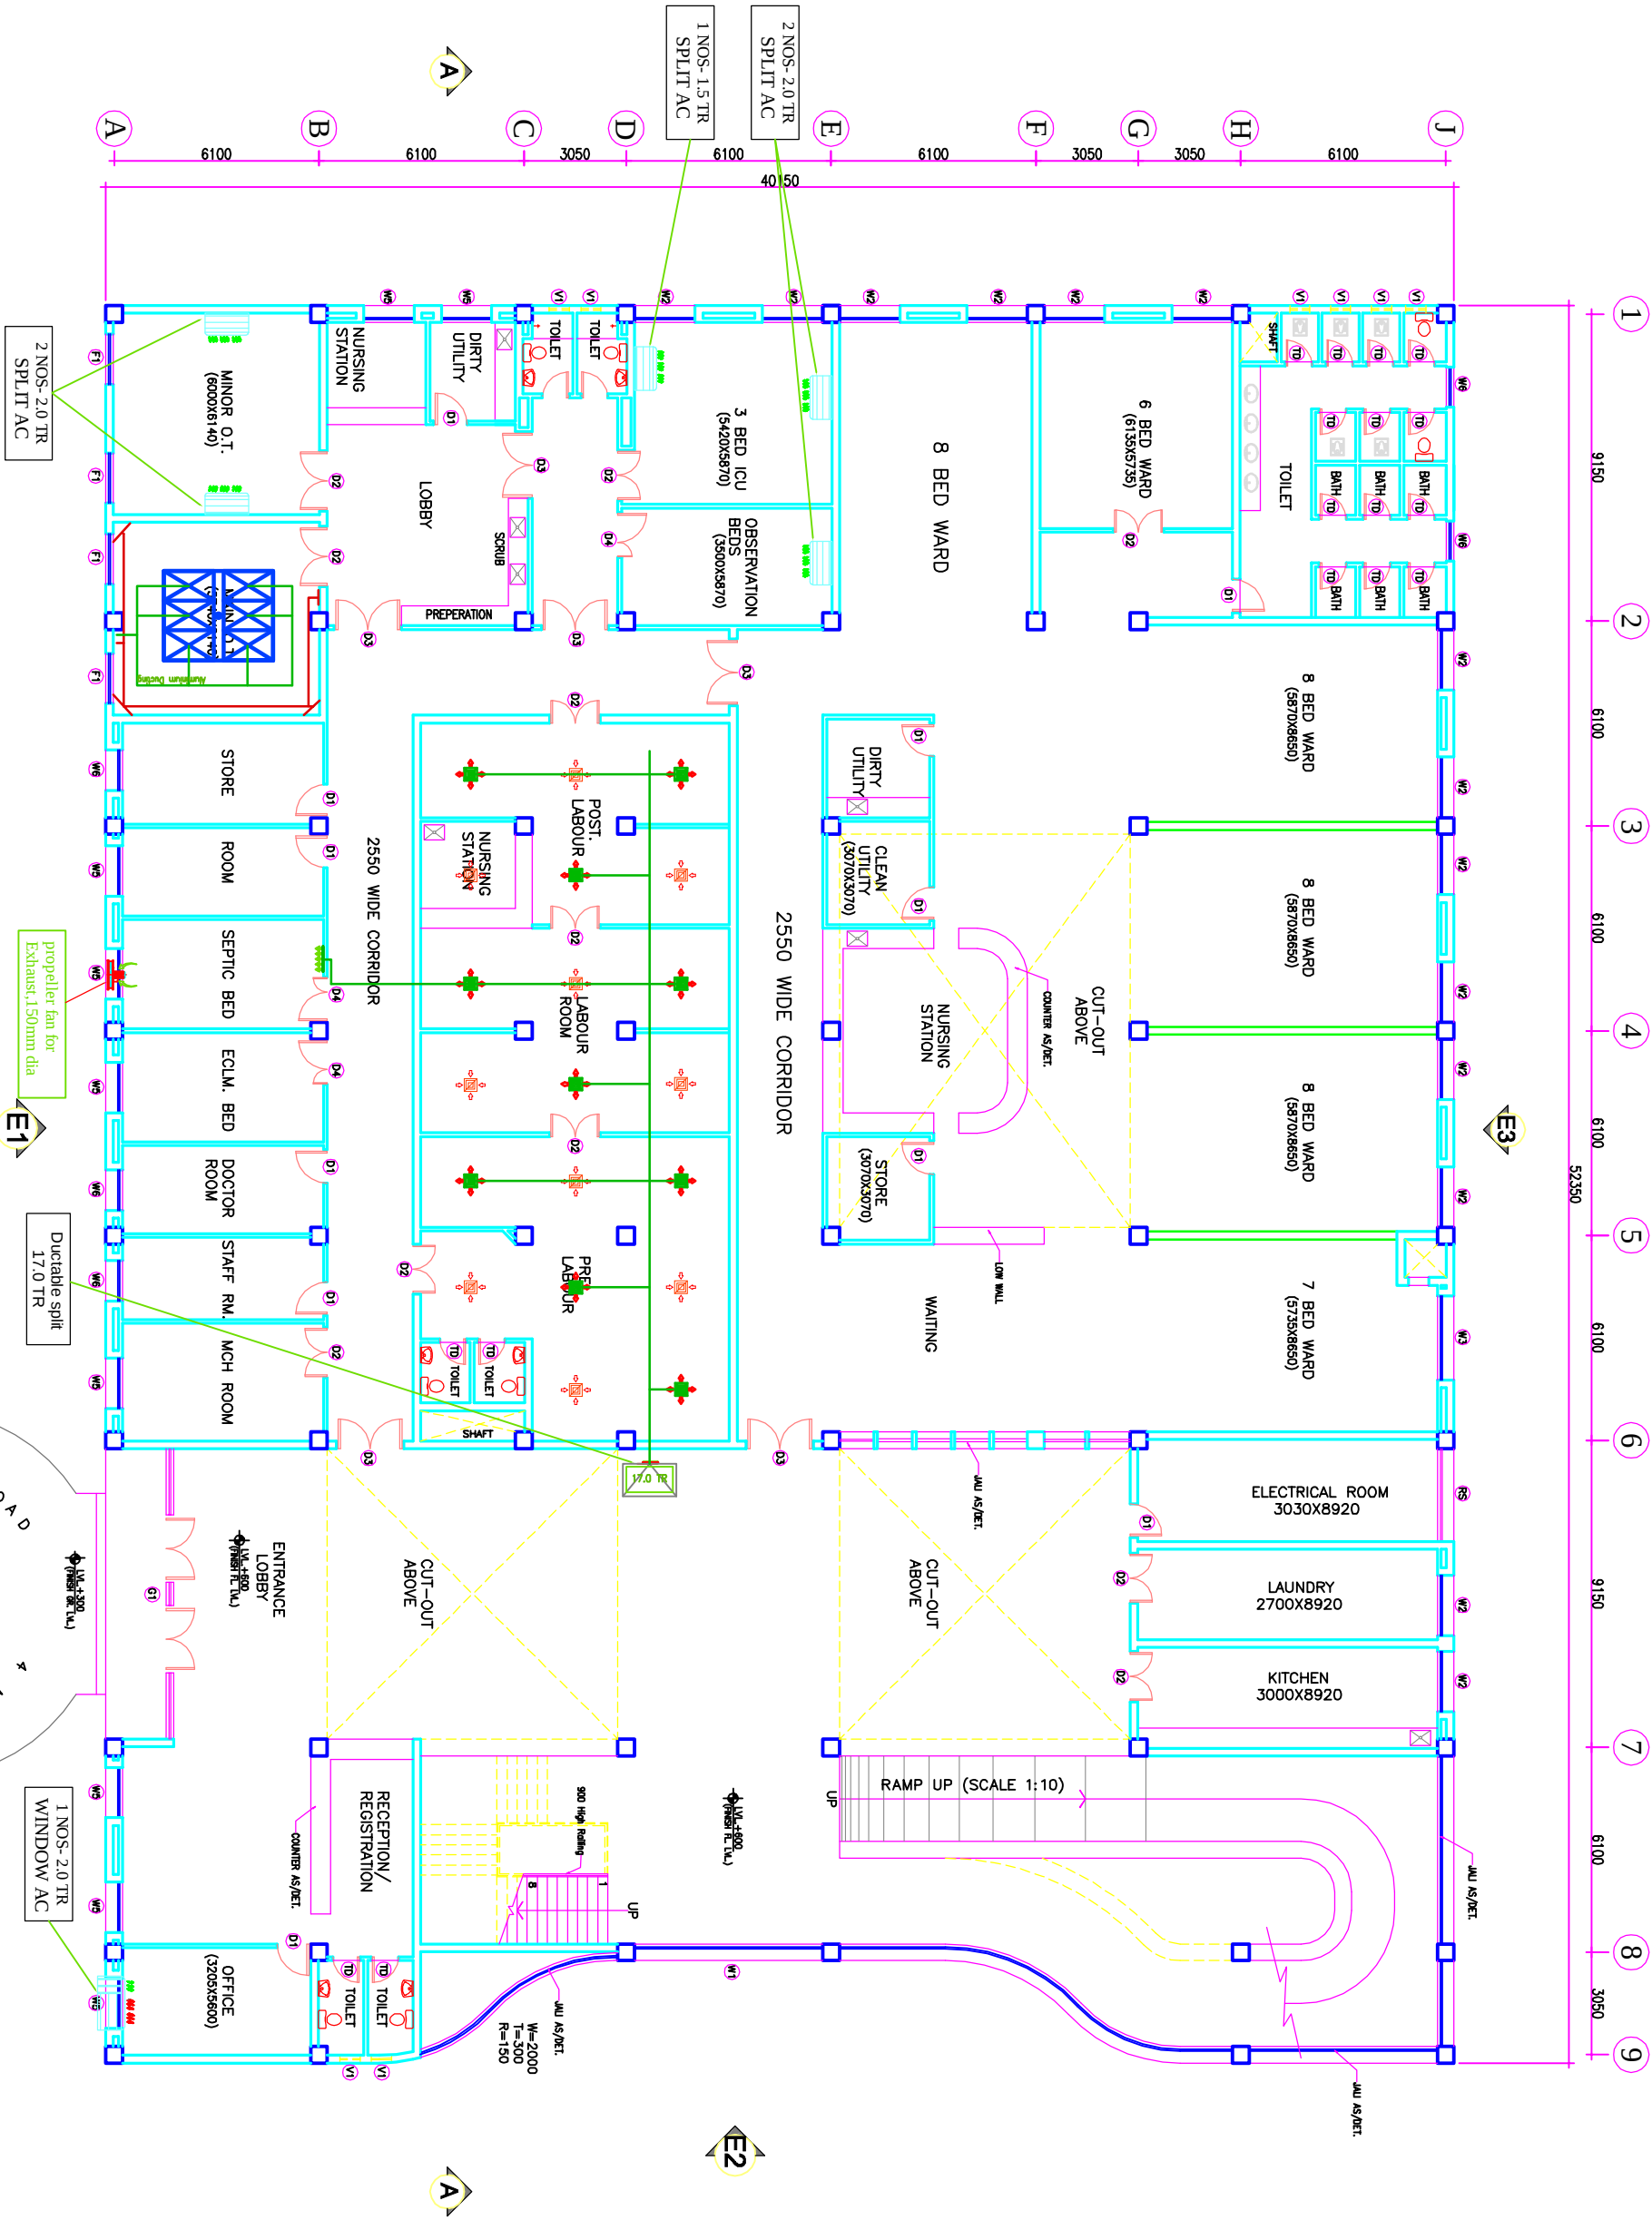

The drawing with all its contents is the sole property of the HSCC (INDIA) LIMITED. It is not to be reproduced, stored in a retrieval system, or transmitted in any form or by any means, electronic, mechanical, photocopying, recording, or by any information storage and retrieval system, without the written permission of HSCC. It is prohibited.

NOTES

DOOR AND WINDOW SCHEDULE				
S/N	NAME	SIZE	UNIT	REMARKS
1	D1	800X2150	000	2150
2	D1	1000X2150	000	2150
3	D2	1500X2150	000	2150
4	D3	2000X2150	000	2150
5	D4	1500X2150	000	2150
6	D5	1500X2150	000	2150
7	D6	1500X2150	000	2150
238	D237	1500X2150	000	2150
239	D238	1500X2150	000	2150</

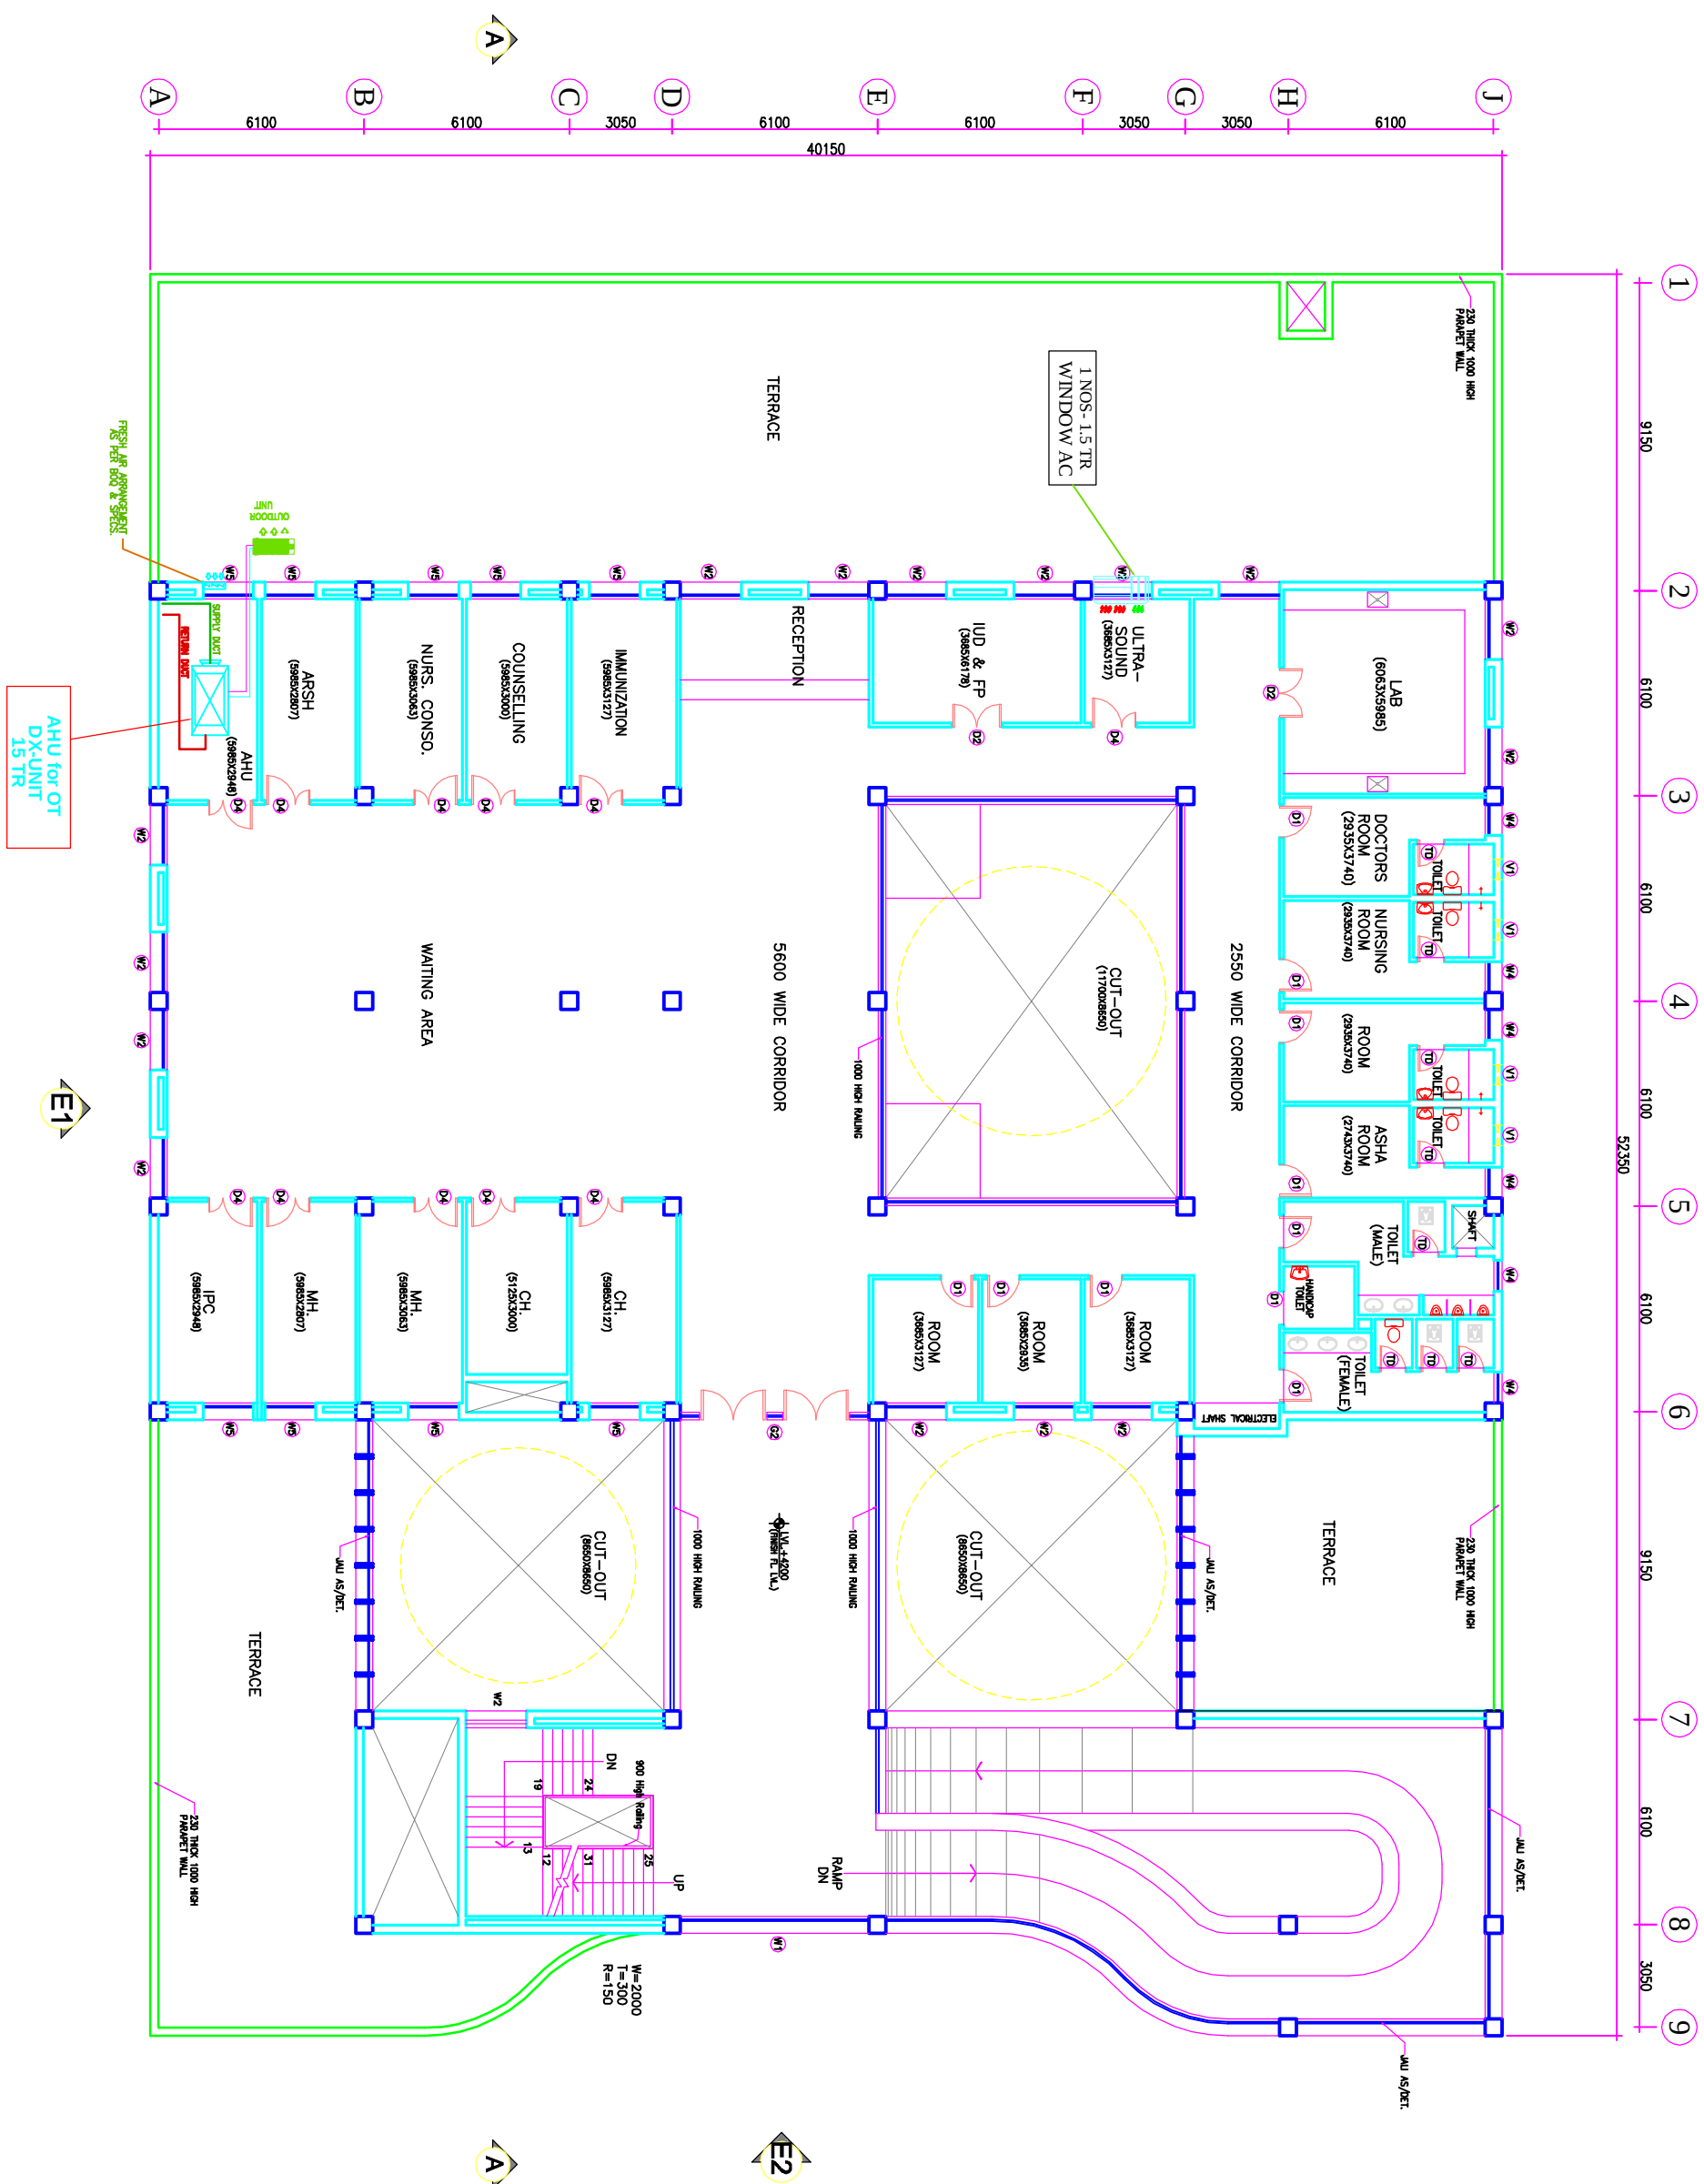

NOTES	This dealing with all its subsidiaries is the sole business activity of the Hospital Services Consultancy Corporation (HSCC) Ltd. Copying of this drawing or part thereof for use in any form whatsoever without the written permission of HSCC is prohibited.
-------	--

DOOR AND WINDOW SCHEDULE				
S/N	TYPE	COL	UNIT	REMARKS
1	600X2150	900	2150	
2	1000X2150	900	2150	
3	1500X2150	900	2150	DOUBLE SILLER
4	2000X2150	900	2150	DOUBLE SILLER
5	1500X2150	900	2150	DOUBLE SILLER
6	2760X3000	900	3000	
7	850X3000	0/1550	3000	
8	5800X3000	0/1550	3000	
9	1500X2150	900	3000	BEAM BOTTOM
10	2500X2150	900	3000	
11	1500X2150	900	3000	
12	1500X2150	900	3000	
13	1500X2150	900	3000	
14	1500X2150	900	3000	
15	600X600	1550	2150	

[illegible]

PROJECT
RMNCH PROJECT

Proposed 50 Bedded Hospital at CHHATTISGARH	TITLE HVAC LAYOUT FIRST FLOOR PLAN (COVERED AREA=1035 SQ. MT.)
--	--

TENDER DRAWING

HSBC/D&E/RYAC/NR/HM-CG-50/AC-02	R-0
Drawing No.	Rev.
HSBC/-	1:100
Job No.	Scale
	01-04-2013
	Date
App by	Rev. by
	Prep. by