


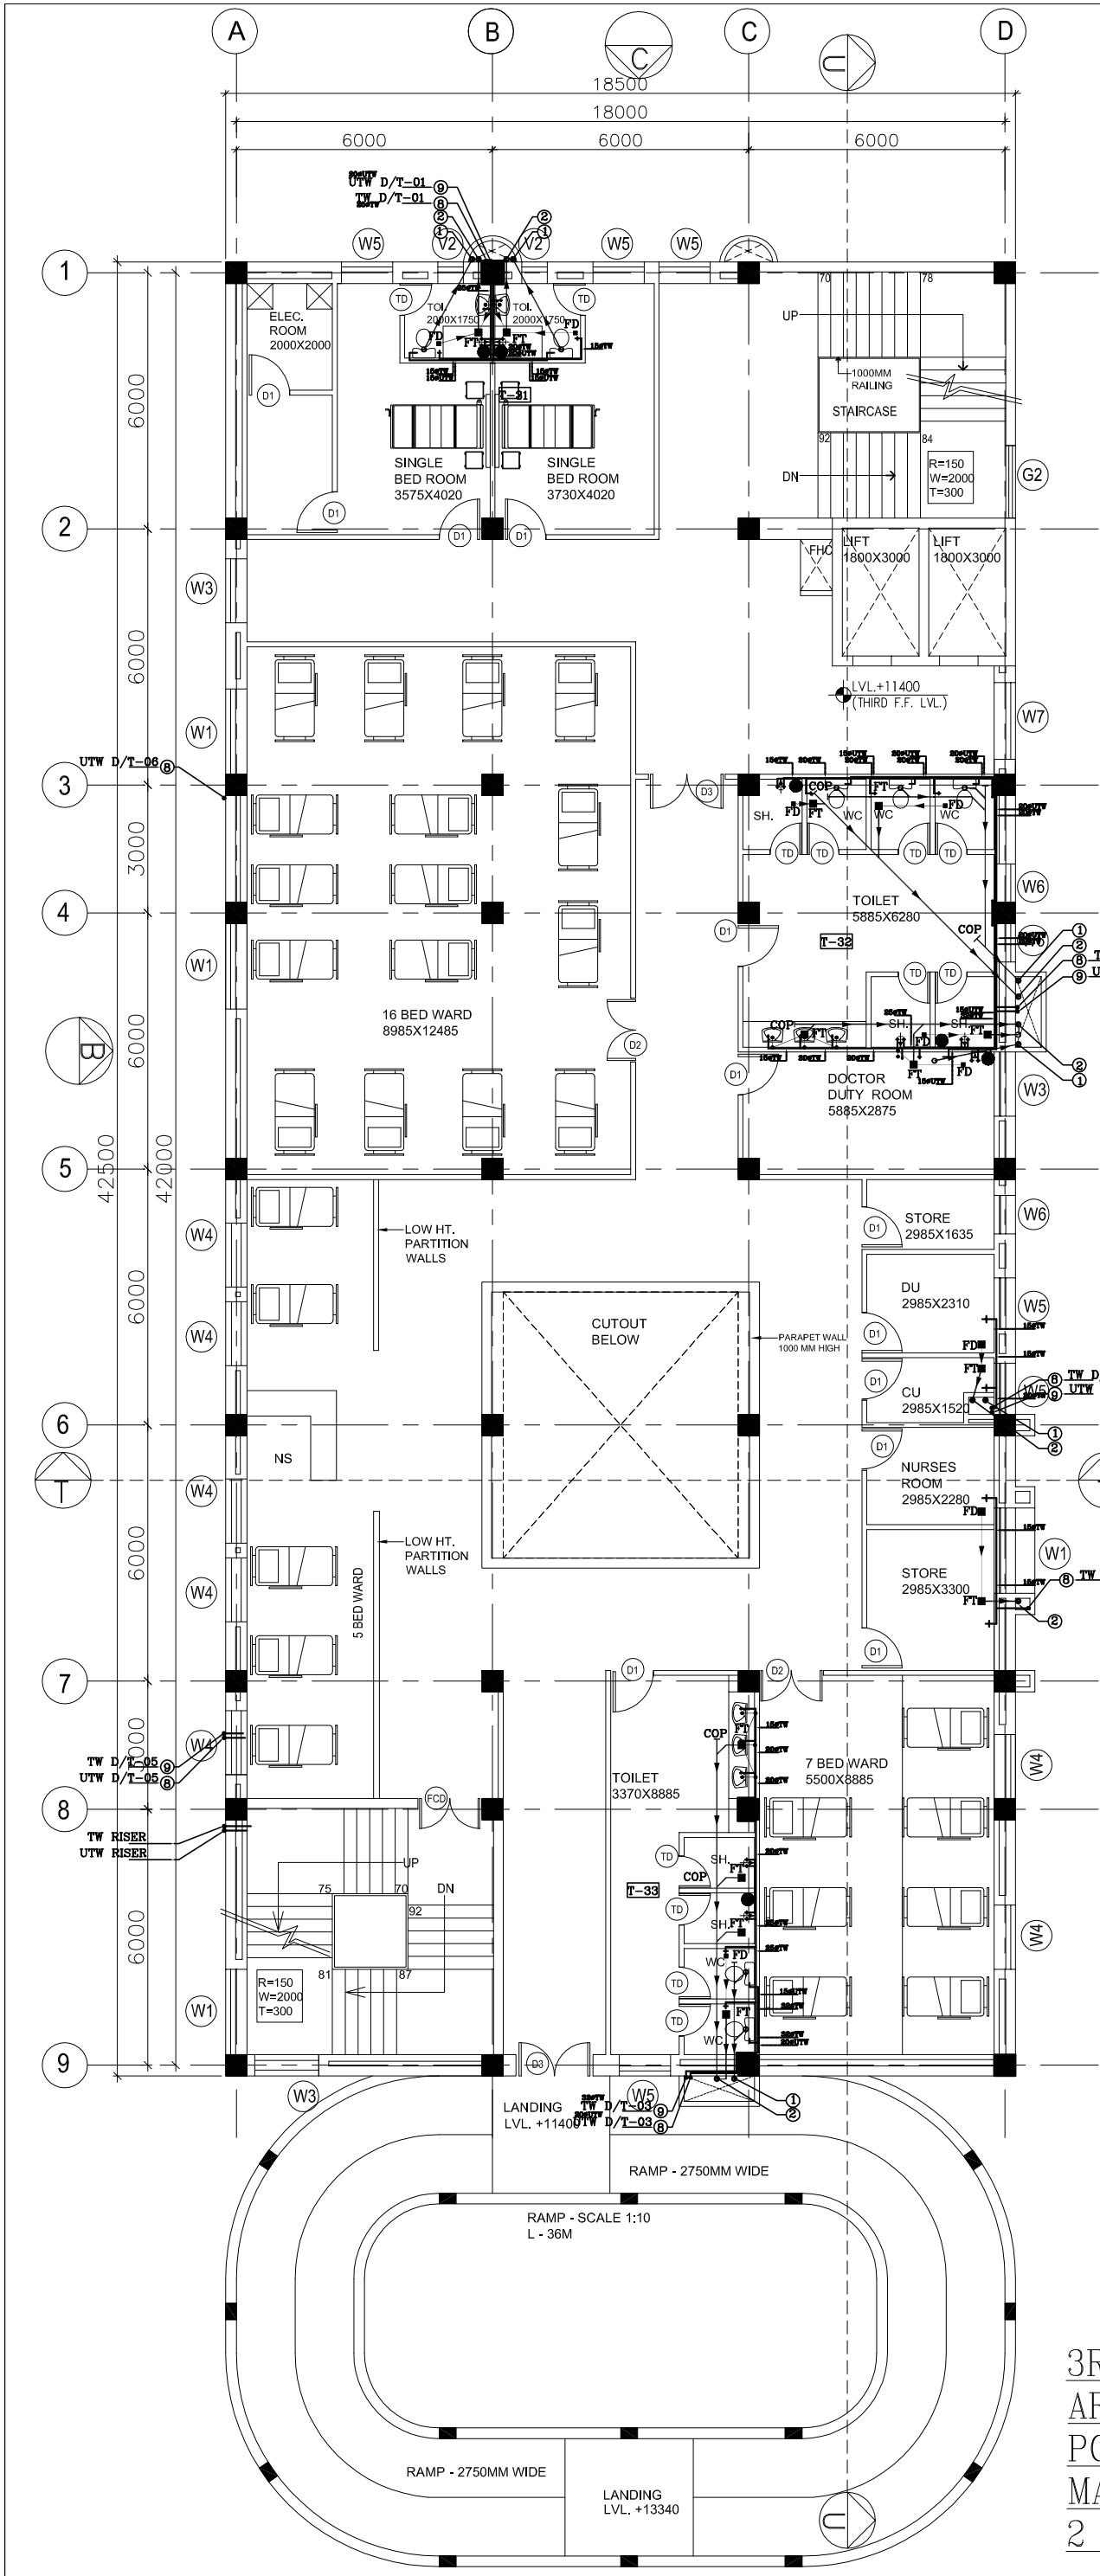

DOOR / WINDOW SCHEDULE					
S.NO.	TYPE	WIDTH	CILL	LINTEL	REMARKS
1	D1	1000	—	2150	
2	D2	1500	—	2150	
3	D3	1800	—	2150	
4	D5	1200	—	2150	
5	TD	750	—	2150	TOILET DOOR
6	FCD	1500	—	2150	
7	G1	2890	00	BEAM BOTTOM	
8	G2	2000	00	BEAM BOTTOM	
9	G3	1700	00	BEAM BOTTOM	
10	G4	4000-2500	00	BEAM BOTTOM	
11	G5	2700	900	BEAM BOTTOM	
12	W1	2000	900	BEAM BOTTOM	
13	W2	2500	900	BEAM BOTTOM	
14	W3	1500	900	BEAM BOTTOM	
15	W4	1500	900	2400	
16	W5	1200	900	BEAM BOTTOM	
17	W6	900	900	BEAM BOTTOM	
18	W7	1800	900	BEAM BOTTOM	
19	V1	1000	2150	BEAM BOTTOM	
20	V2	600	2150	BEAM BOTTOM	
21	F1	1500	900	BEAM BOTTOM	

This drawing with all its contents is the sole intellectual property of the Hospital Services Consultancy Corporation (India) Ltd. Copying of this drawing or part thereof or its use in any form whatsoever without the written permission of HSCC is prohibited.

NOTES

1. DRAWINGS TO BE READ NOT MEASURED

2. PARTITION WALL IN TOILETS UP TO LINTEL HEIGHT

LEGEND:

1	100 Ø CI SOIL & VENT PIPE
2	100Ø CI.WASTE & VENT PIPE
3	100Ø CI. SOIL PIPE
4	100Ø CI. WASTE PIPE
5	50Ø uPVC SOIL PIPE
6	40Ø uPVC WASTE PIPE
7	32Ø uPVC WASTE PIPE
8	Ø UTW DN.TAKE
9	Ø TW DN.TAKE
10	100 Ø S.W. PIPE
11	100 Ø R.W. PIPE
12	100 Ø HDPE.LAB WASTE PIPE
13	50 Ø HDPE.LAB WASTE PIPE
F.T	FLOOR TRAP 100x100
F.D	FLOOR DRAIN 50Ø
FCO	FLOOR CLEAN OUT
COP	CLEAN OUT PLUG
✕	VALVE
MH	MANHOLE (900x800)mm
GT	GULLY TRAP(300X300)mm

REVISION	DESCRIPTION

3RD FLOOR PLAN
AREA = 864.65 SQM
POST NATAL – 28 BED
MATERNITY WARD +
2 SINGLE ROOMS

PROJECT

PROPOSED
100 BEDDED HOSPITAL
SHAHJAHANPUR

TITLE PLUMBING

TENDER DRAWING

THIRD
FLOOR PLAN

HSCC/D&E/TD/SHAHJAHANPUR/PL-05

Drawing No. Rev.

Job No. 1:150 Scale MARCH-2013 Date

R.TYAGI App by R.SUR Rev. by S.BHATT Prep. by

HSCC (INDIA) LIMITED
(A GOVERNMENT OF INDIA ENTERPRISES)

HSCC

NEW DELHI INDIA