




COLUMN SIZE
(500X500)

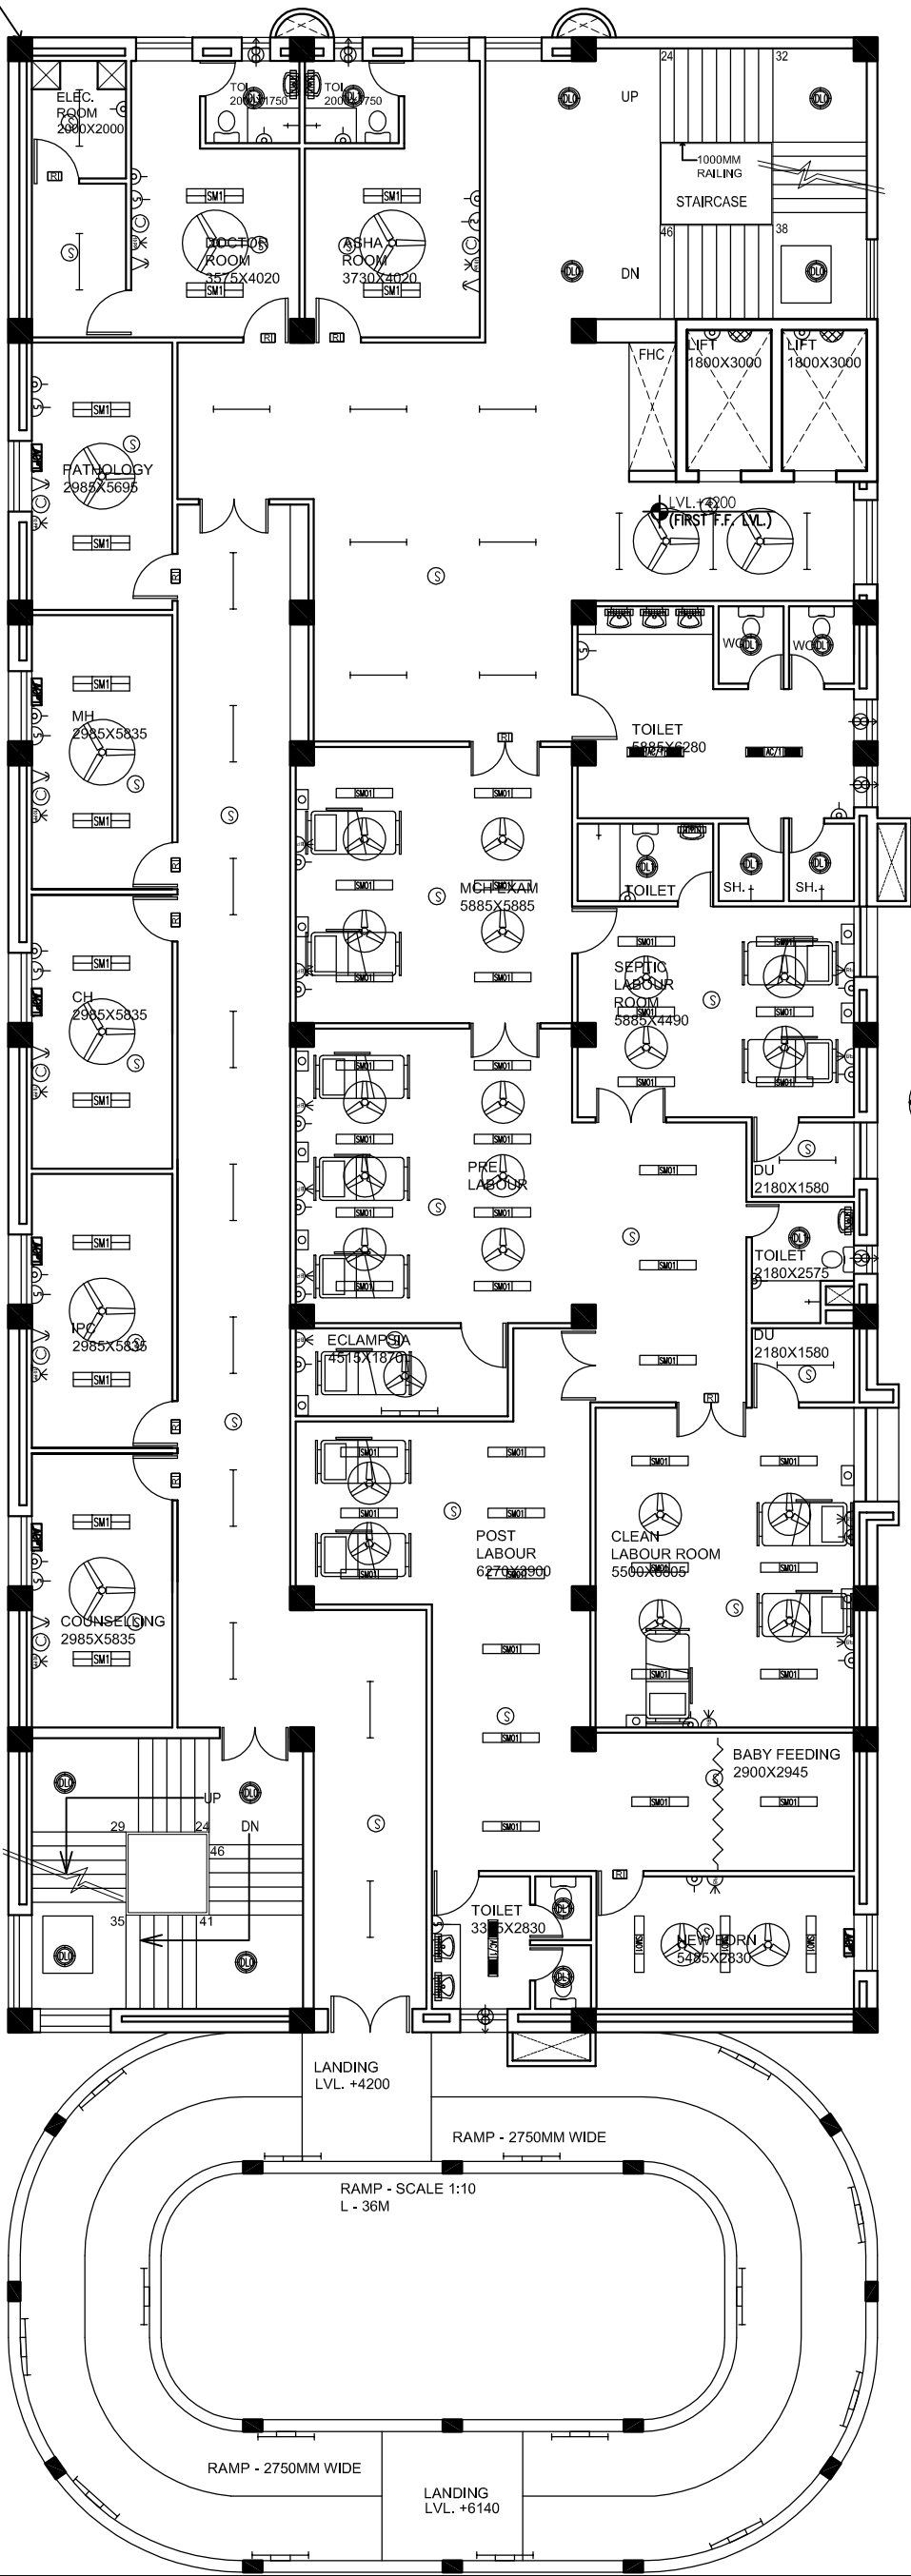

IST FLOOR PLAN
AREA = 898.97 SQM
LABOUR ROOM+OPD

This drawing with all its contents is the sole intellectual property of the Hospital Services Consultancy Corporation (India) Ltd. Copying of this drawing or part thereof or its use in any form whatsoever without the written permission of HSCC is prohibited.

NOTES

- DRAWINGS TO BE READ NOT MEASURED
- PARTITION WALL IN TOILETS UP TO LINTEL HEIGHT

REVISION

PROJECT

PROPOSED
100 BEDDED HOSPITAL
SHAHJAHANPUR

TITLE

TENDER DRAWING

FIRST
FLOOR PLAN
ELECTRICAL LAYOUT

HSCC/D&E/ID/UP(SHAHJAHANPUR)/EL-302

Drawing No. Rev.

Job No. NTS Scale MARCH-2013 Date

App by Rev. by Prep. by

HSCC (INDIA) LIMITED
(A GOVERNMENT OF INDIA ENTERPRISES)

HSCC
NEW DELHI INDIA