


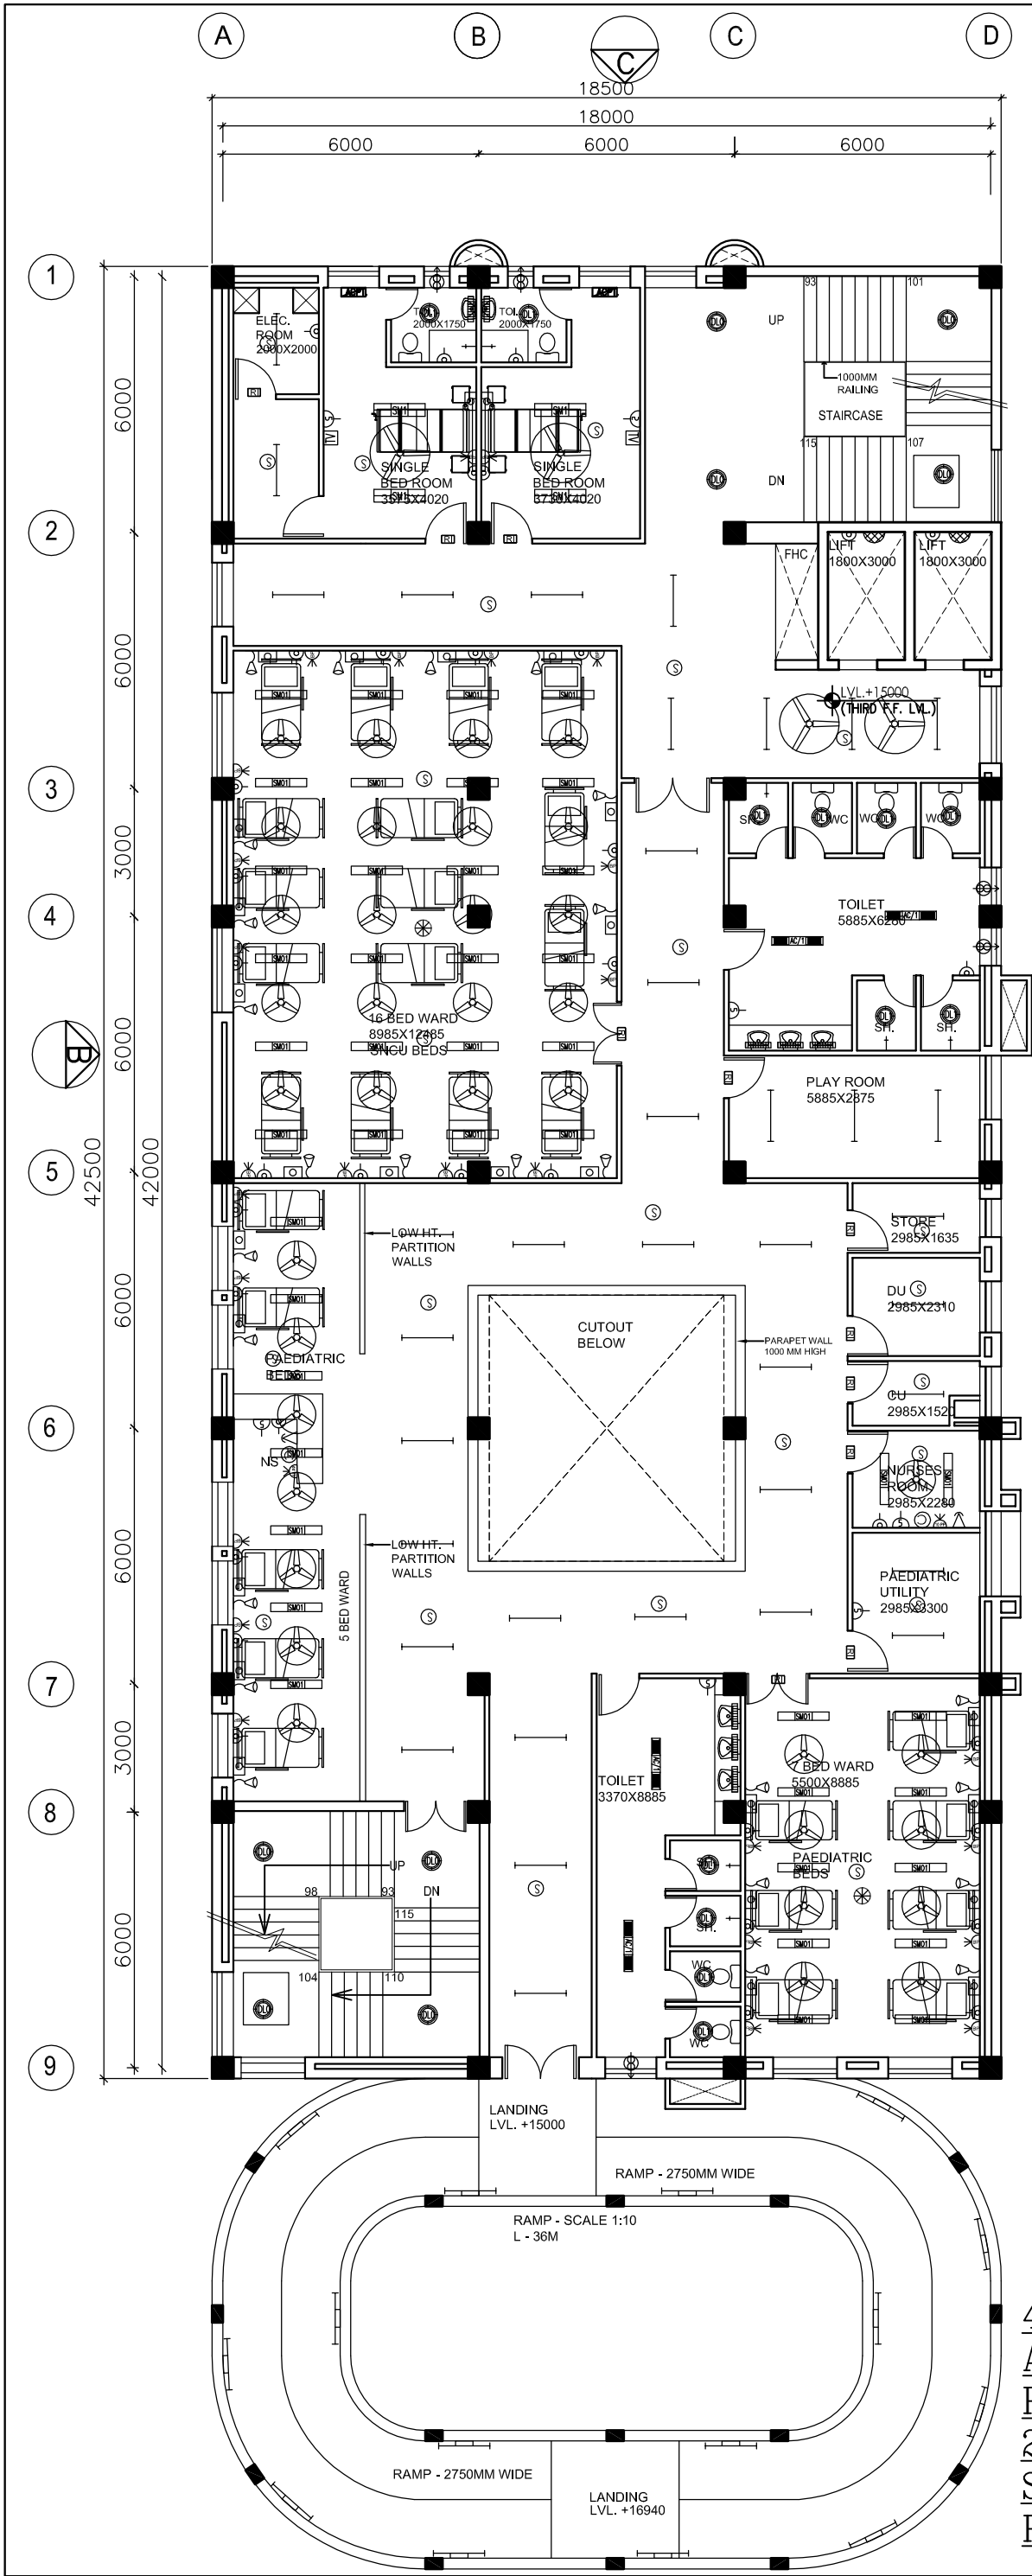

4TH FLOOR PLAN
AREA = 864.65 SQM
PAEDIATRIC WARD -
28 BEDS + 2 SINGLE ROOMS
SNCU - 16 BED
PAEDIATRIC - 12 BED

This drawing with all its contents is the sole intellectual property of the Hospital Services Consultancy Corporation (India) Ltd. Copying of this drawing or part thereof or its use in any form whatsoever without the written permission of HSCC is prohibited.

- NOTES
1. DRAWINGS TO BE READ NOT MEASURED
 2. PARTITION WALL IN TOILETS UP TO LINTEL HEIGHT

REVISION

PROJECT

PROPOSED
100 BEDDED HOSPITAL
SHAHJAHANPUR

TITLE

TENDER DRAWING

FOURTH
FLOOR PLAN
ELECTRICAL LAYOUT

HSCC/D&E/ID/UP(SHAHJAHANPUR)/EL-305

Drawing No. Rev.

Job No. NTS Scale MARCH-2013 Date

App by Rev. by Prep. by

HSCC (INDIA) LIMITED
(A GOVERNMENT OF INDIA ENTERPRISES)

HSCC
NEW DELHI INDIA