


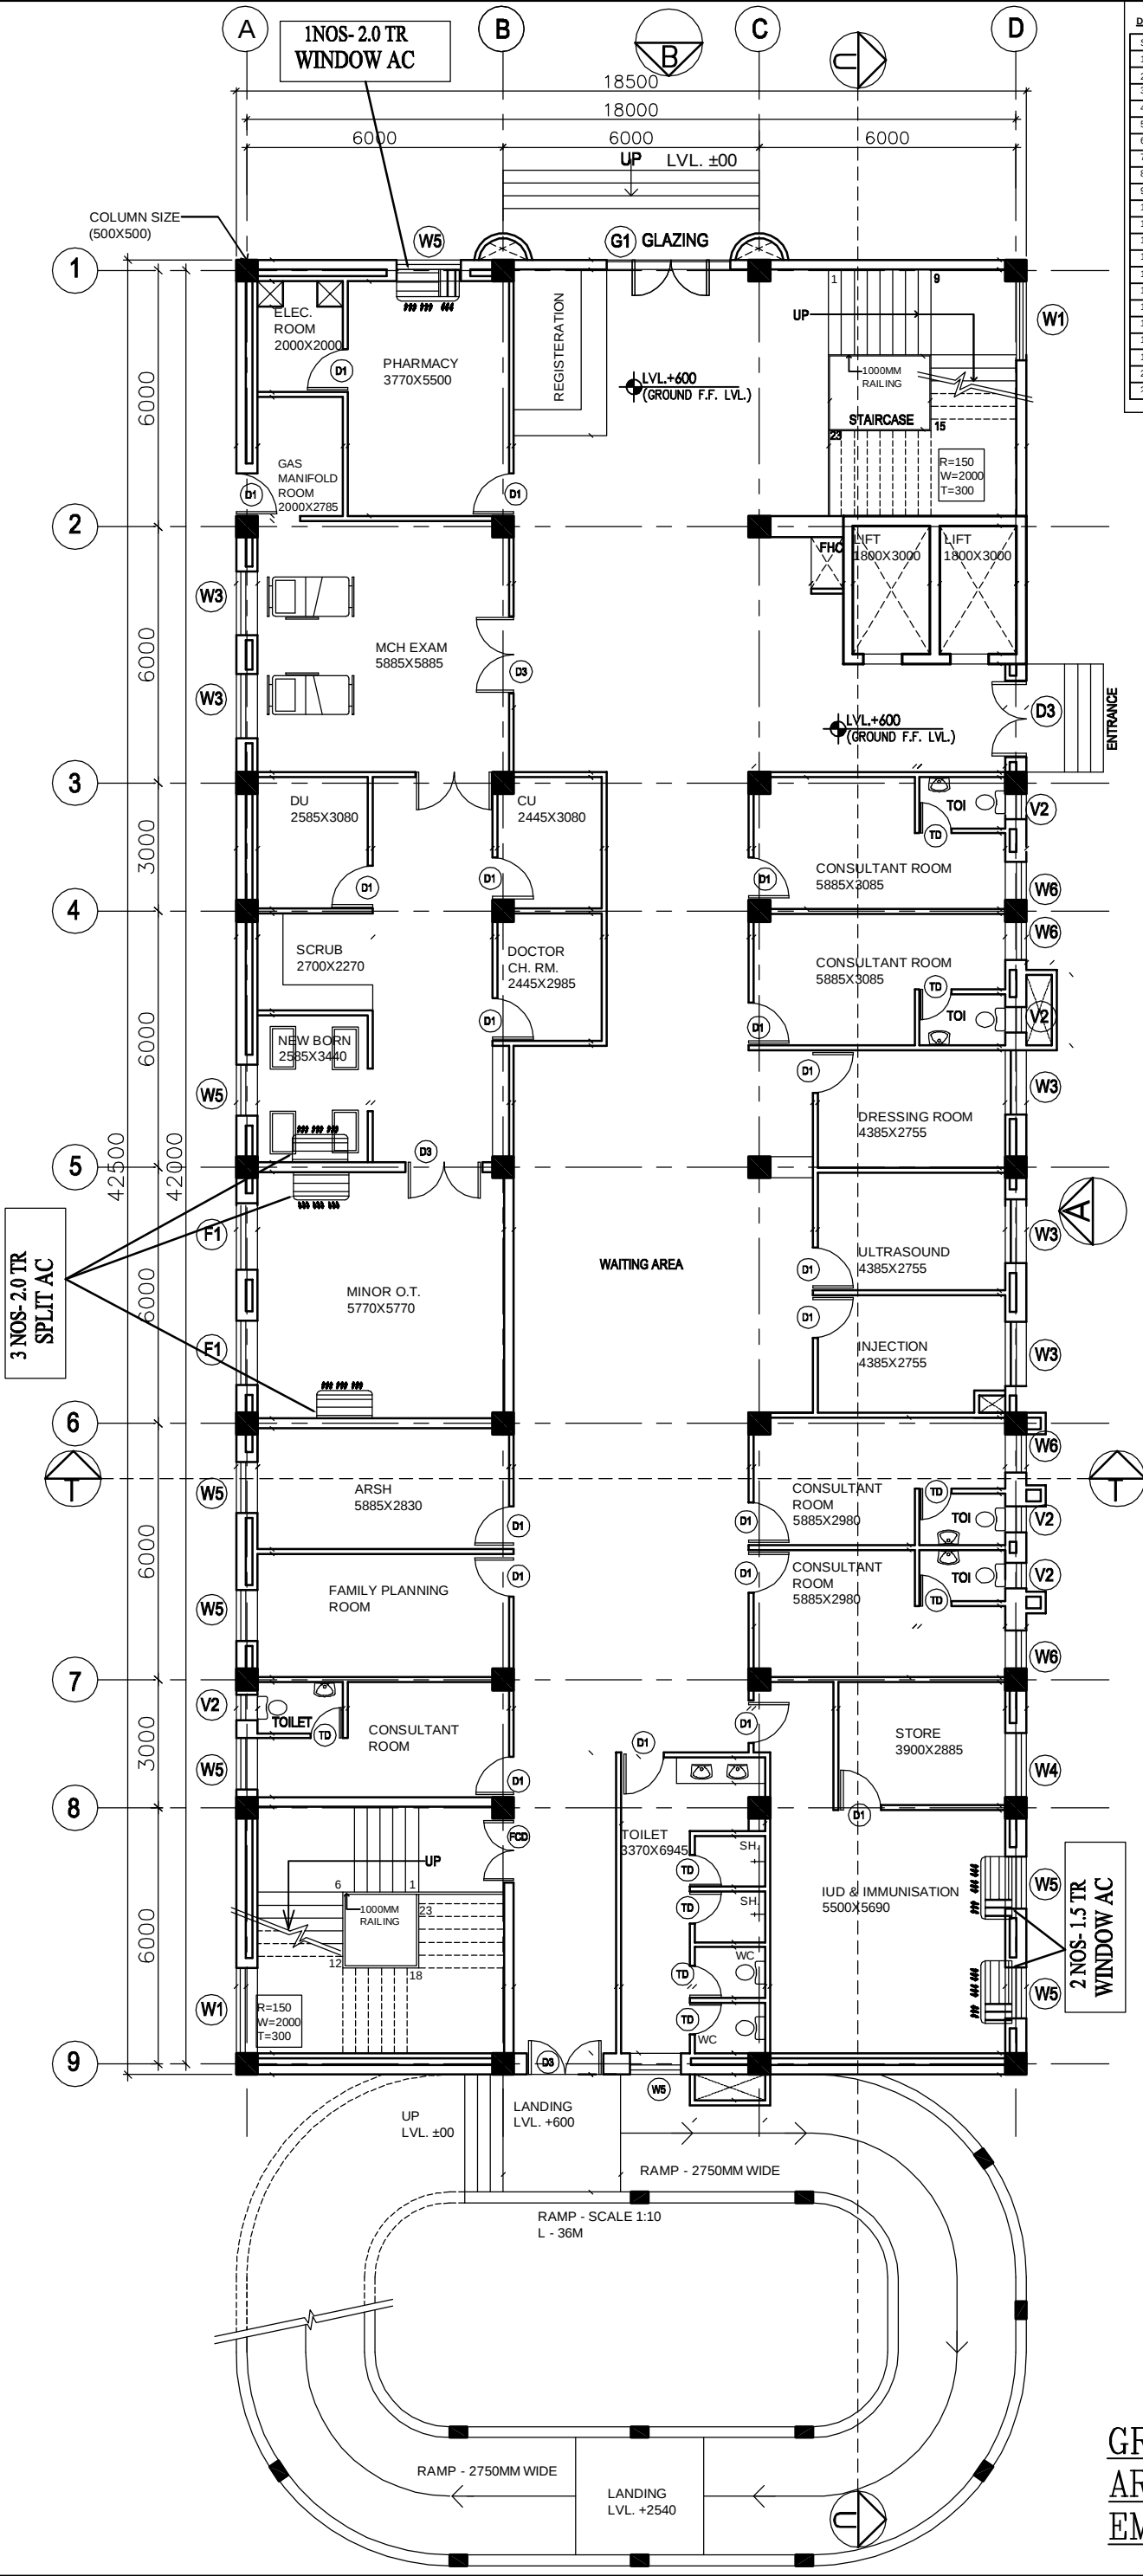

This drawing with all its contents is the sole intellectual property of the Hospital Services Consultancy Corporation (India) Ltd. Copying of this drawing or part thereof or its use in any form whatsoever without the written permission of HSCC is prohibited.

REVISION

NO.	DESCRIPTION

PROJECT

PROPOSED
100 BEDDED HOSPITAL
SHAHJAHANPUR

TITLE

TENDER DRAWING

GROUND FLOOR PLAN

HVAC LAYOUT

HSCC/D&E/HVAC/UP-SHAHJAHANPUR/AC-01
Drawing No. Rev.

Job No. 1:150 Scale MARCH-2013 Date

App by Rev. by Prep. by

HSCC (INDIA) LIMITED
(A GOVERNMENT OF INDIA ENTERPRISES)
HSCC
NEW DELHI INDIA