


| DOOR / WINDOW SCHEDULE |      |           |      |             |             |
|------------------------|------|-----------|------|-------------|-------------|
| S.NO.                  | TYPE | WIDTH     | CILL | LINTEL      | REMARKS     |
| 1                      | D1   | 1000      | —    | 2150        |             |
| 2                      | D2   | 1500      | —    | 2150        |             |
| 3                      | D3   | 1800      | —    | 2150        |             |
| 4                      | D5   | 1200      | —    | 2150        |             |
| 5                      | TD   | 750       | —    | 2150        | TOILET DOOF |
| 6                      | FCD  | 1500      | —    | 2150        |             |
| 7                      | G1   | 2890      | 00   | BEAM BOTTOM |             |
| 8                      | G2   | 2000      | 00   | BEAM BOTTOM |             |
| 9                      | G3   | 1700      | 00   | BEAM BOTTOM |             |
| 10                     | G4   | 4000-2500 | 00   | BEAM BOTTOM |             |
| 11                     | G5   | 2700      | 900  | BEAM BOTTOM |             |
| 12                     | W1   | 2000      | 900  | BEAM BOTTOM |             |
| 13                     | W2   | 2500      | 900  | BEAM BOTTOM |             |
| 14                     | W3   | 1500      | 900  | BEAM BOTTOM |             |
| 15                     | W4   | 1500      | 900  | 2400        |             |
| 16                     | W5   | 1200      | 900  | BEAM BOTTOM |             |
| 17                     | W6   | 900       | 900  | BEAM BOTTOM |             |
| 18                     | W7   | 1800      | 900  | BEAM BOTTOM |             |
| 19                     | V1   | 1000      | 2150 | BEAM BOTTOM |             |
| 20                     | V2   | 600       | 2150 | BEAM BOTTOM |             |
| 21                     | C1   | 1500      | 000  | BEAM BOTTOM |             |

This drawing with all its contents is the sole intellectual property of the Hospital Services Consultancy Corporation (India) Ltd. Copying of this drawing or part thereof or its use in any form whatsoever without the written permission of HSCC is prohibited.

- NOTES
- DRAWINGS TO BE READ NOT MEASURED
  - PARTITION WALL IN TOILETS UP TO LINTEL HEIGHT

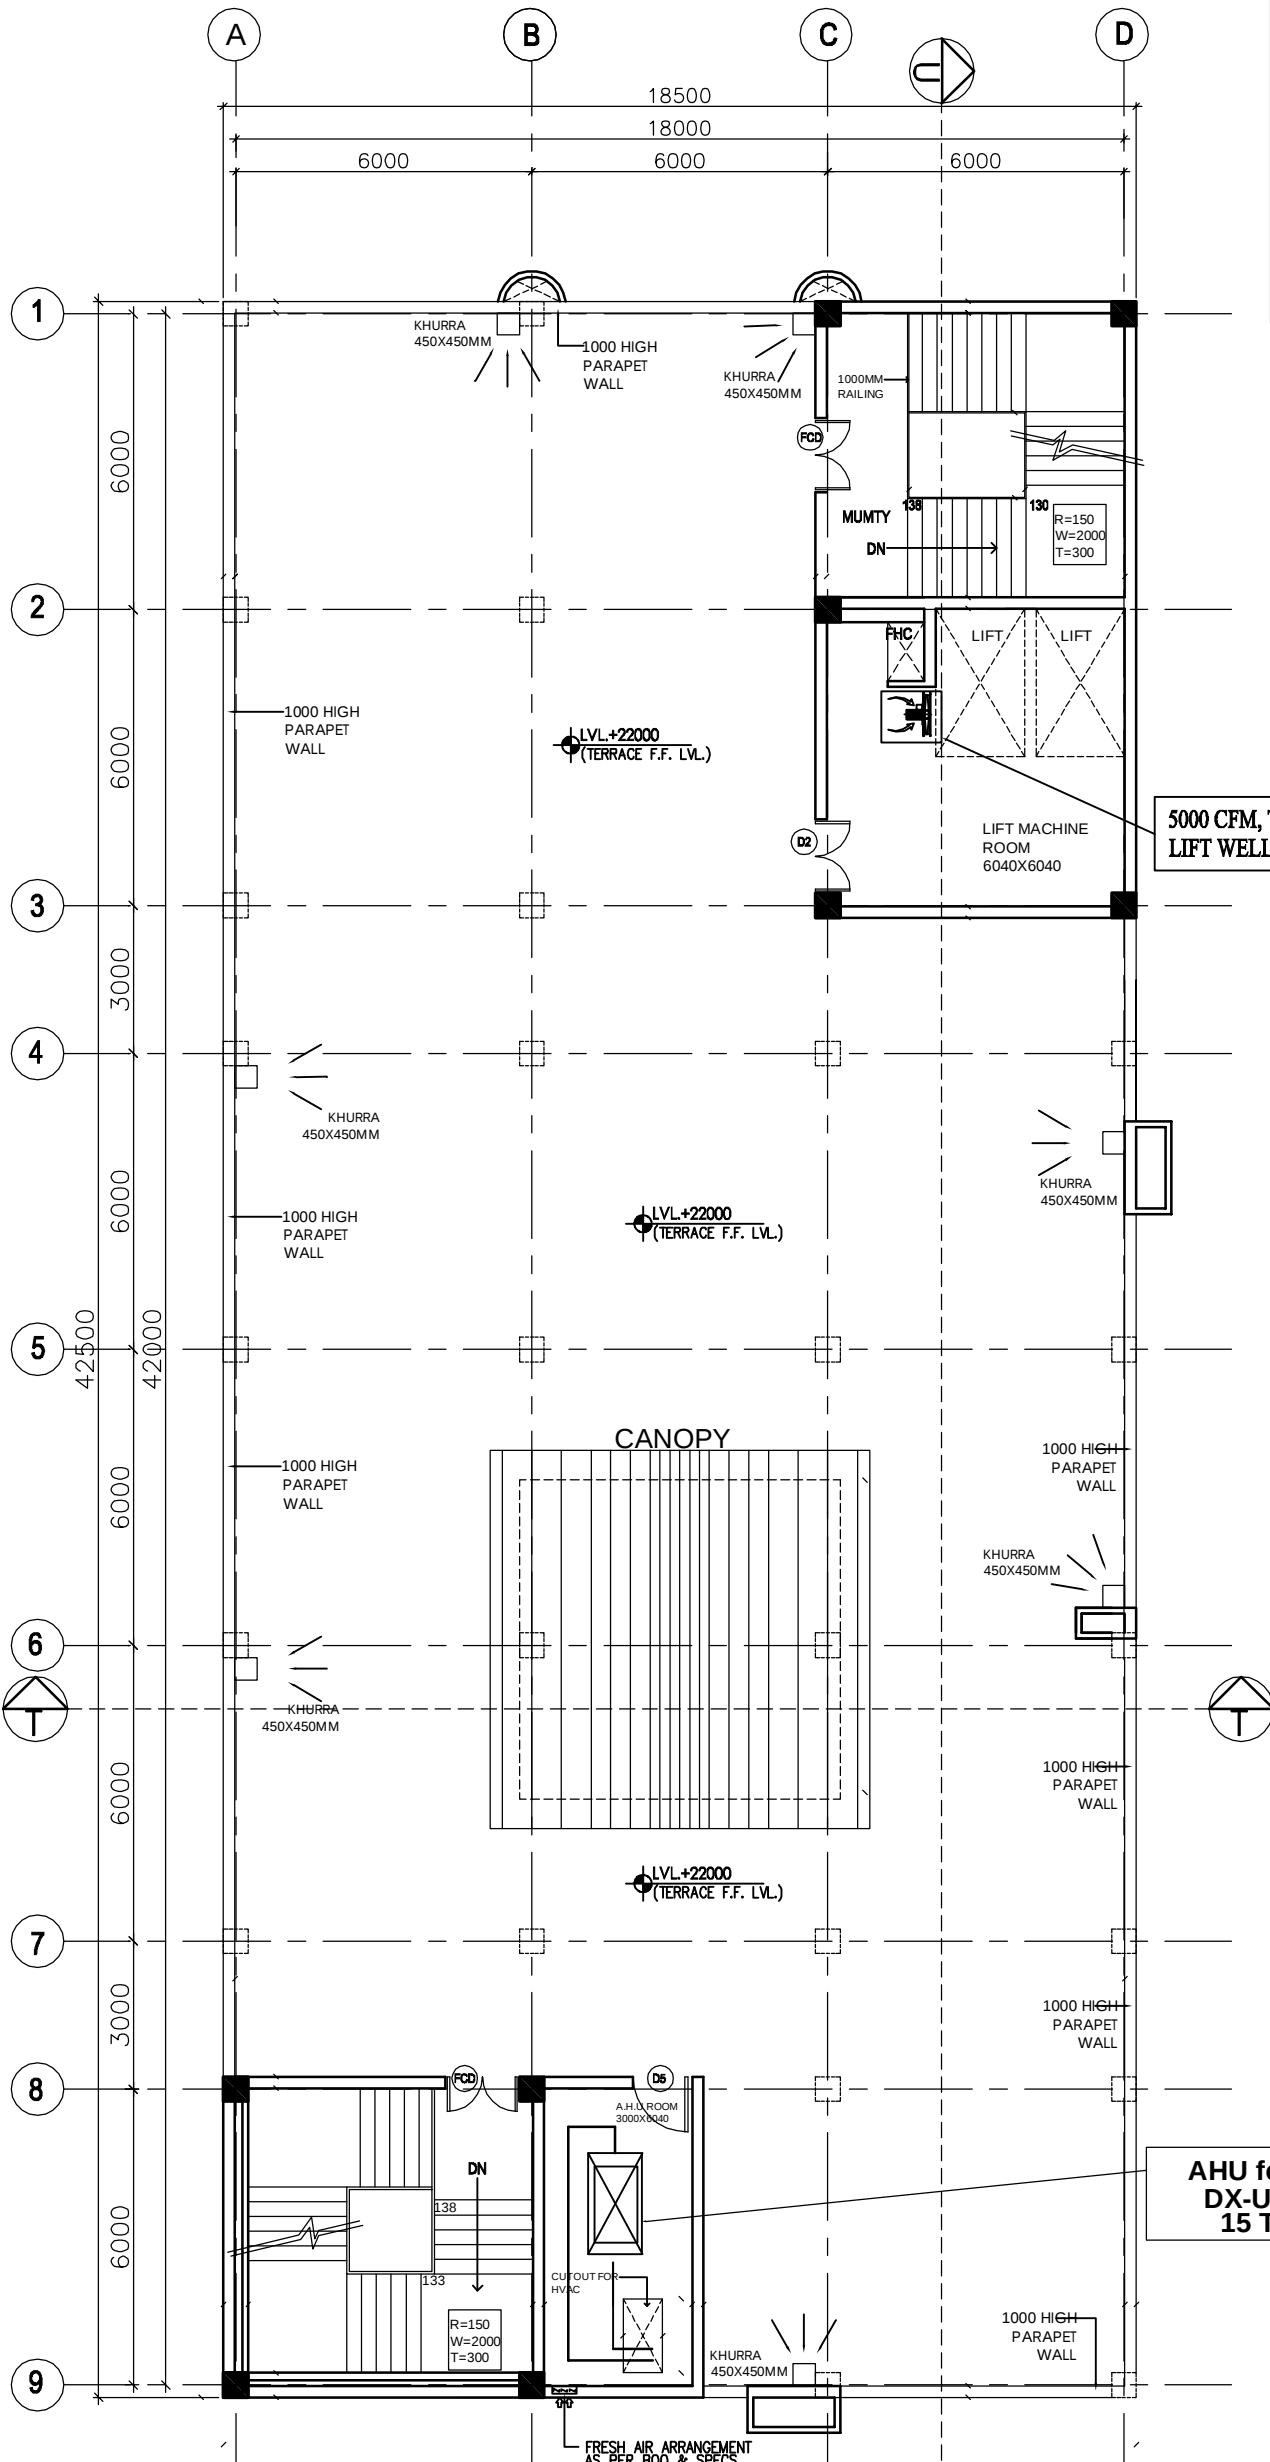

5000 CFM, TUBE AXIAL FAN FOR LIFT WELL PRESSURISATION

AHU for OT DX-UNIT 15 TR

TERRACE PLAN

| REVISION                                  |             | DESCRIPTION     |
|-------------------------------------------|-------------|-----------------|
|                                           |             |                 |
| PROJECT                                   |             |                 |
| PROPOSED 100 BEDDED HOSPITAL SHAHJAHANPUR |             |                 |
| TITLE                                     |             |                 |
| TENDER DRAWING                            |             |                 |
| TERRACE PLAN                              |             |                 |
| HVAC LAYOUT                               |             |                 |
| HSCC/D&E/HVAC/UP-SHAHJAHANPUR/AC-04       |             |                 |
| Drawing No.                               |             | Rev.            |
| Job No.                                   | 1:150 Scale | MARCH-2013 Date |
| App by                                    | Rev. by     | Prep. by        |