

CHHATTISGARH MEDICAL SERVICES CORPORATION LIMITED

(Government of Chhattisgarh)

Tender

For

Construction of 100 bedded MCH wing at Bilaspur (C.G.),
under National Rural Health Mission scheme

Tender Drawings

VOLUME-VI

June' 2013




HSCC (INDIA) LTD.
(CONSULTANTS & ENGINEERS FOR MEGA HOSPITALS & LABORATORIES)
E-6(A), sector-1, NOIDA(U.P) 201301 (India)

Phone : 0120-2542436-40

Fax : 0120-2542447

Tender No. HSCC/NRHM/CG/2013 (II) /03

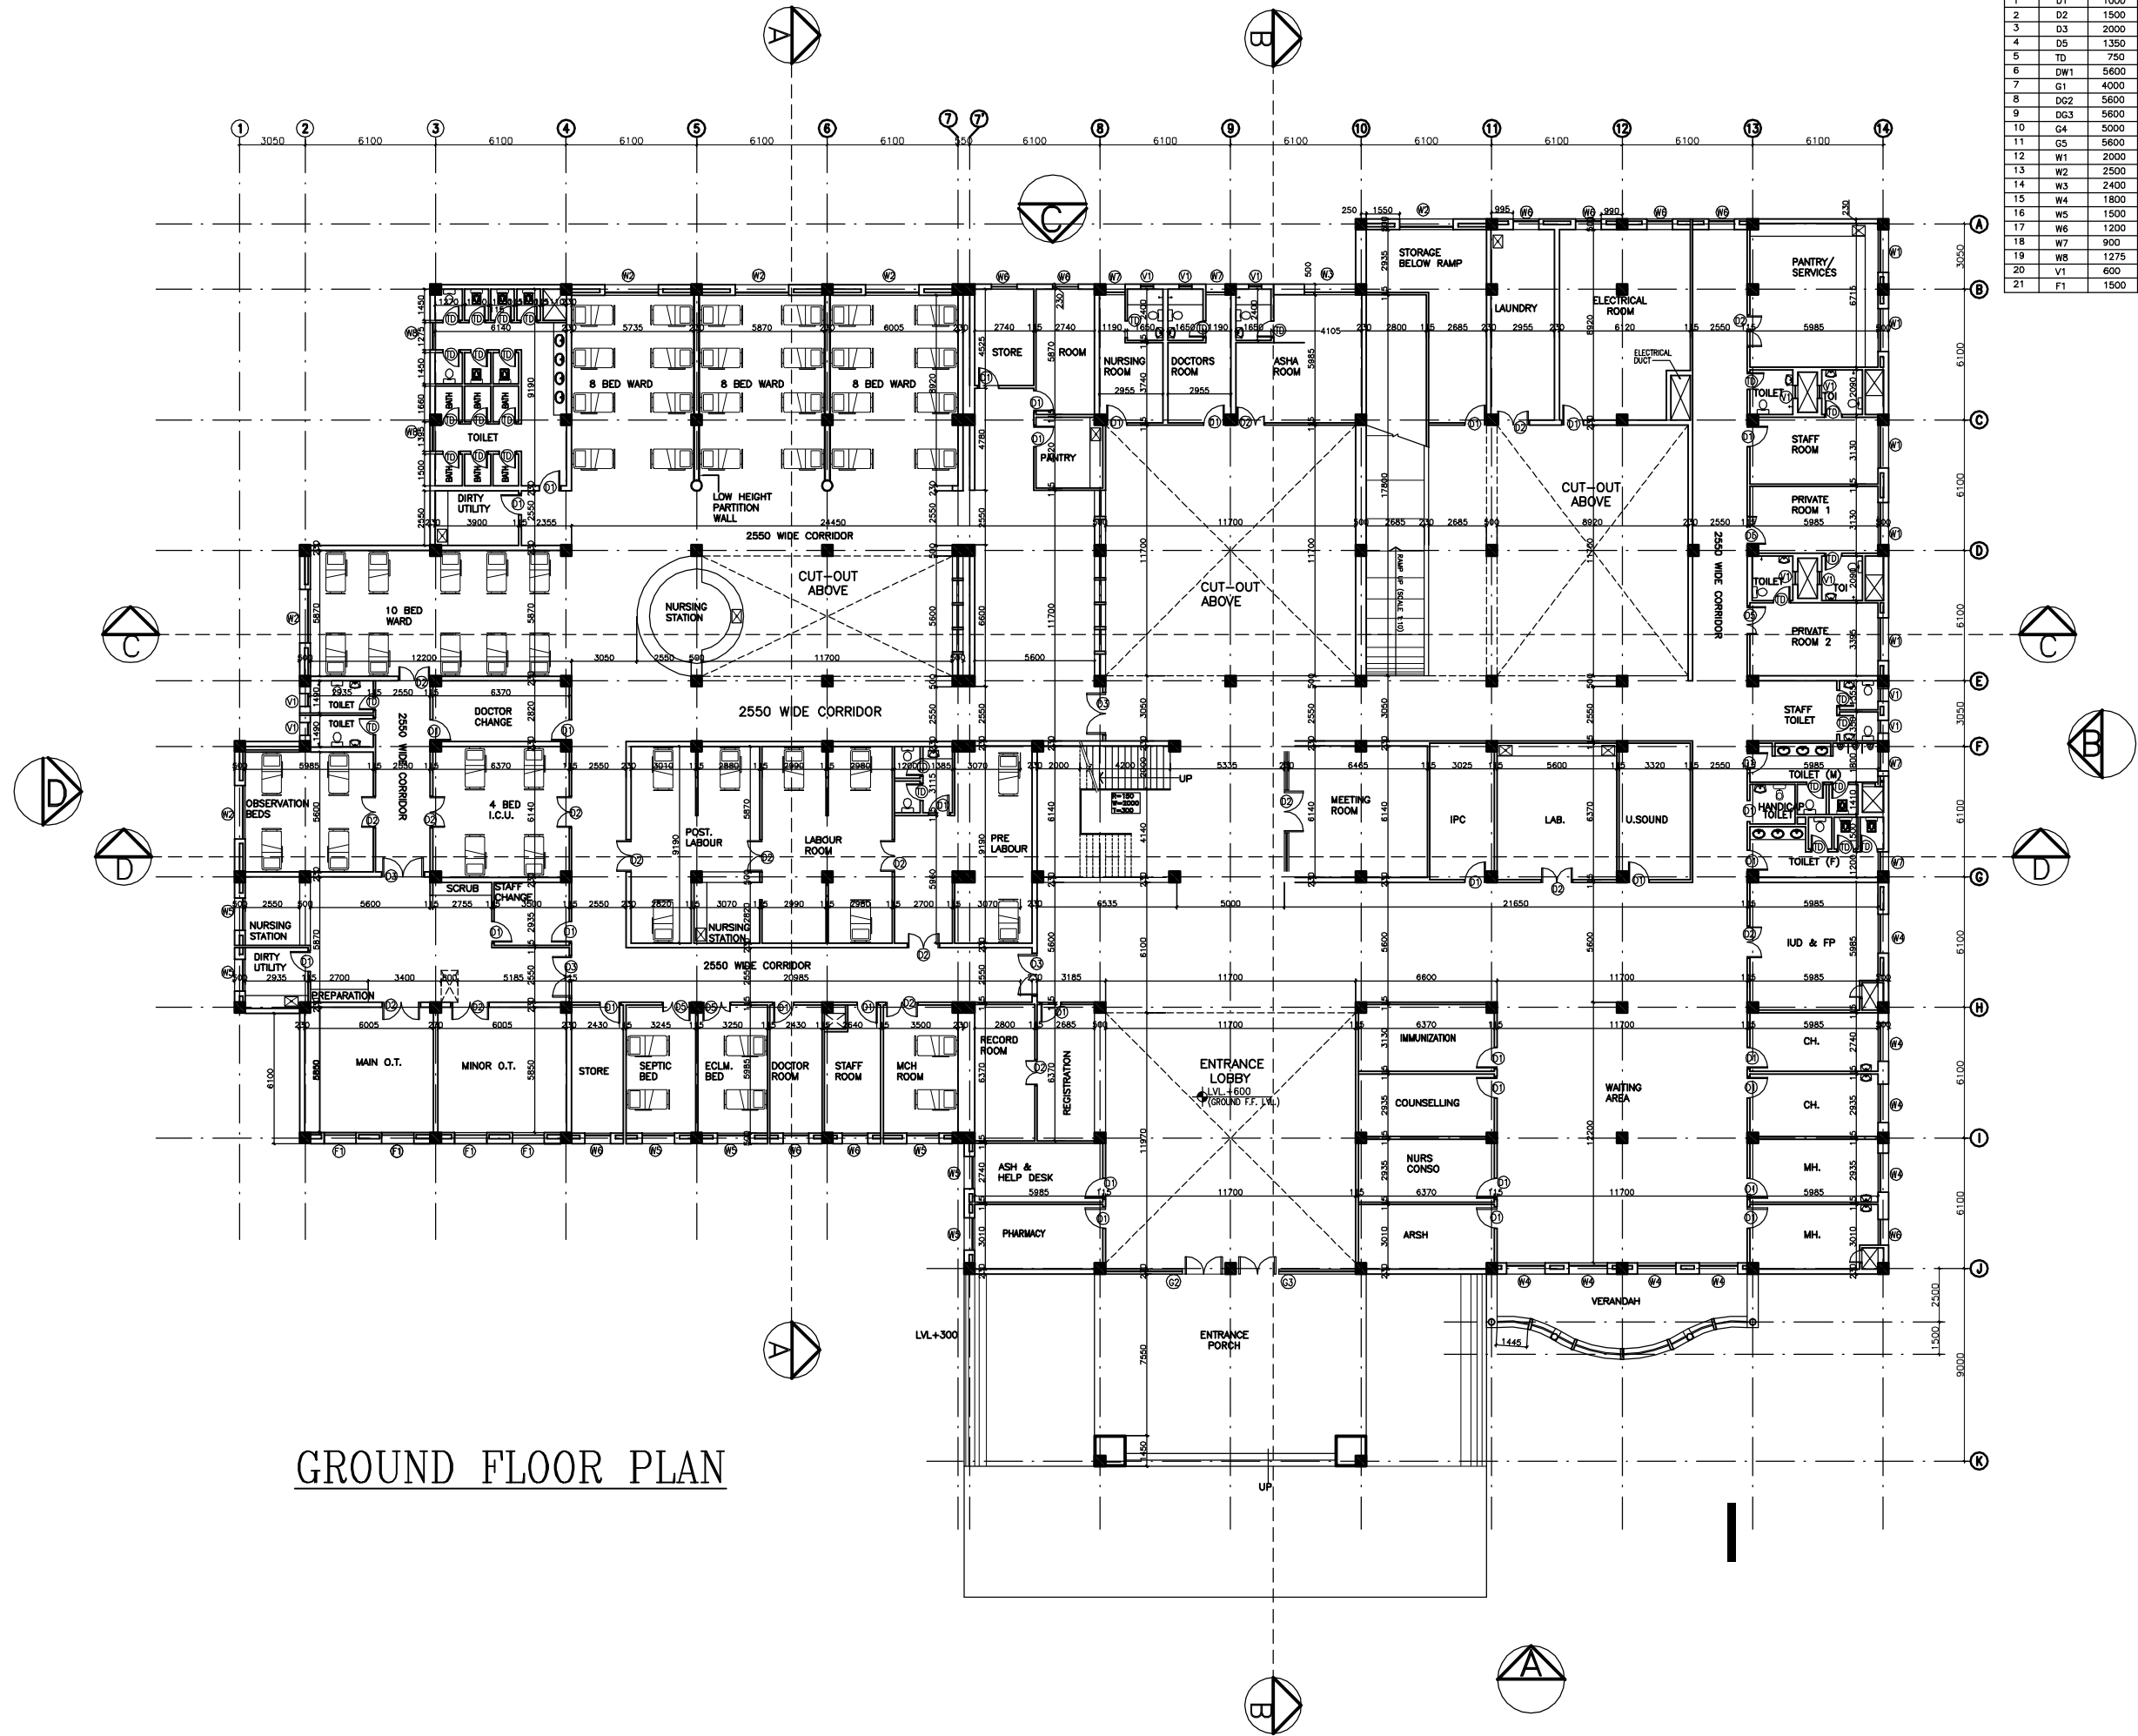

S.NO.	TYPE	WIDTH	CILL	LINTEL	REMARKS
1	D1	1000	—	2150	
2	D2	1500	—	2150	
3	D3	2000	—	2150	
4	D5	1350	—	2150	
5	TD	750	—	2150	TOILET DOOR
6	DW1	5600	00	BEAM BOTTOM	
7	G1	4000	00	BEAM BOTTOM	
8	DG2	5600	00	BEAM BOTTOM	
9	DG3	5600	00	BEAM BOTTOM	
10	G4	5000	00	BEAM BOTTOM	
11	G5	5600	00	2150	
12	W1	2000	900	BEAM BOTTOM	
13	W2	2500	900	BEAM BOTTOM	
14	W3	2400	900	BEAM BOTTOM	
15	W4	1800	900	BEAM BOTTOM	
16	W5	1500	900	BEAM BOTTOM	
17	W6	1200	900	BEAM BOTTOM	
18	W7	900	900	BEAM BOTTOM	
19	W8	1275	1200	2150	
20	V1	600	2150	BEAM BOTTOM	
21	F1	1500	2150	BEAM BOTTOM	

This drawing with all its contents is the sole intellectual property of the Hospital Services Consultancy Corporation (HSCC) Ltd. Copying of this drawing or part thereof, or its use in any form whatsoever without the written permission of HSCC is prohibited.


NOTES

REV	DATE	DESCRIPTION
REVISION		

PROJECT
RMNCH PROJECT
Proposed
100 Bedded Hospital
at
CHATTISGARH

TITLE
GROUND
FLOOR PLAN
(COVERED AREA=3022 SQ. MT.)
working DRAWINGS
(ARCHITECTURE)

HSCC/100 BED/TD/002 Drawing No.		R-0 Rev.
Job No.	1:150 Scale	27-05-2013 Date
App by	Rev. by	Prep. by

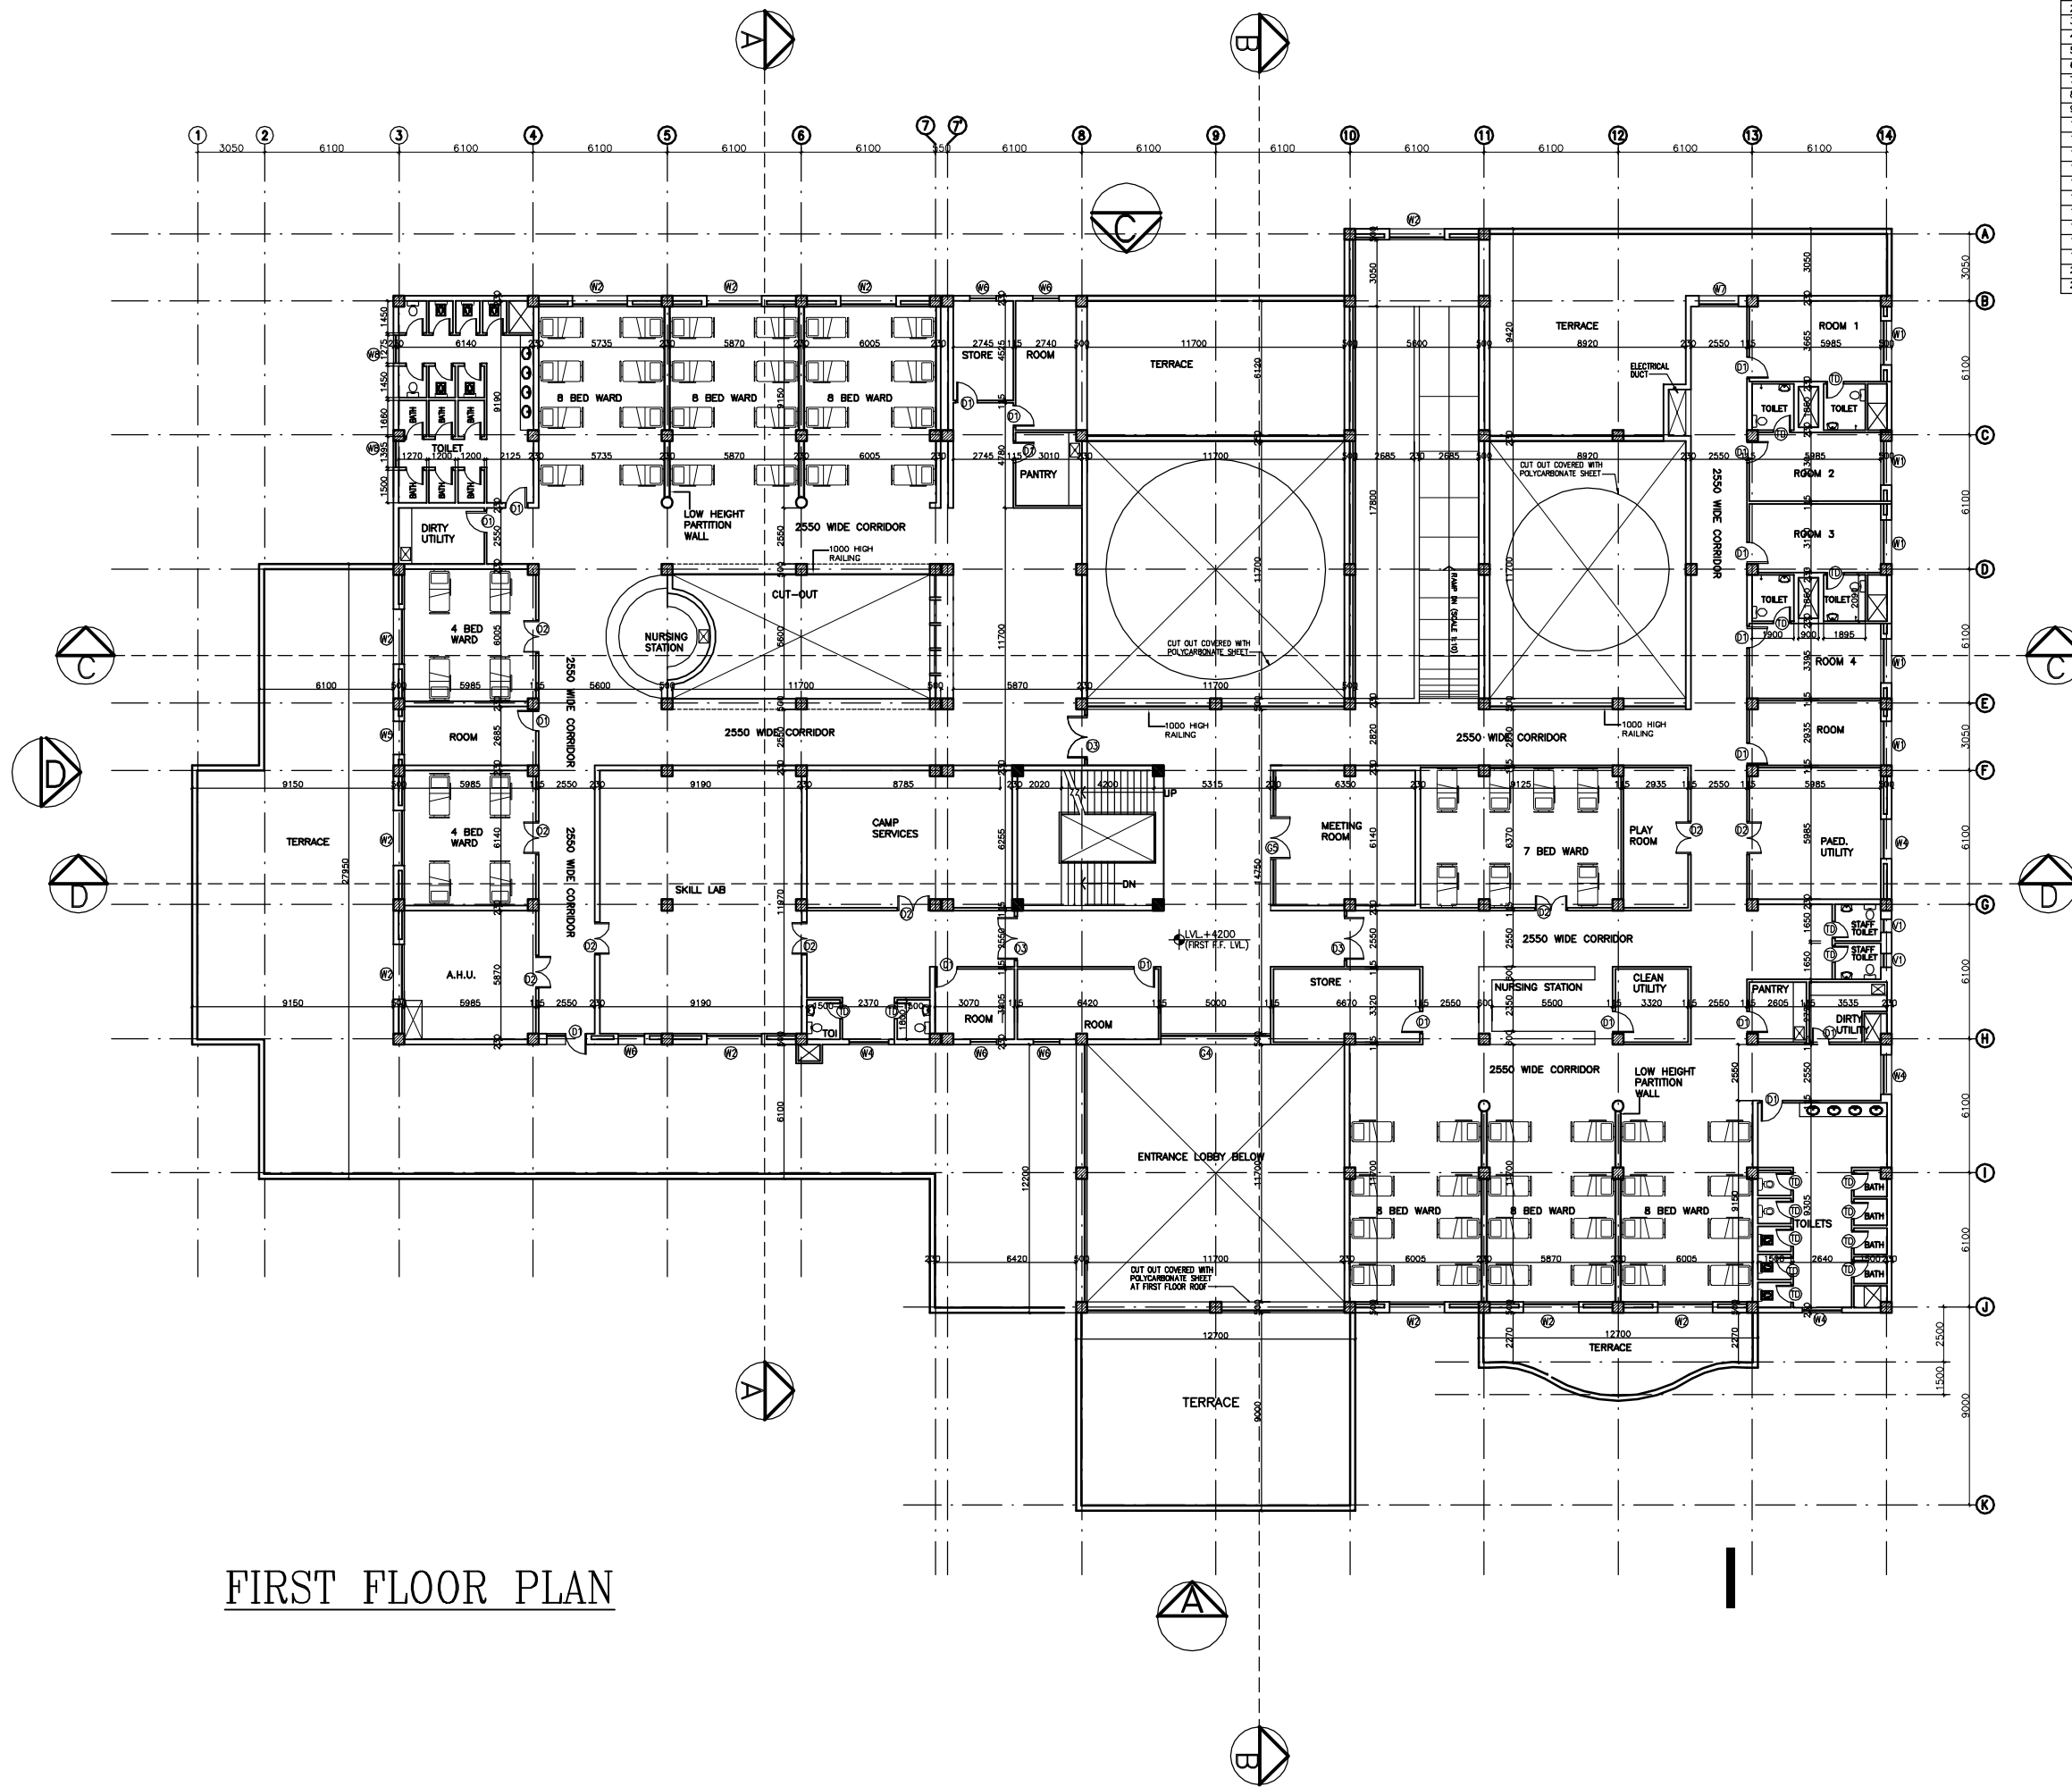

FIRST FLOOR PLAN

S.NO.	TYPE	WIDTH	CILL	LINTEL	REMARKS
1	D1	1000	—	2150	
2	D2	1500	—	2150	
3	D3	2000	—	2150	
4	D5	1350	—	2150	
5	TD	750	—	2150	TOILET DOOR
6	DW1	5600	00	BEAM BOTTOM	
7	G1	4000	00	BEAM BOTTOM	
8	DG2	5600	00	BEAM BOTTOM	
9	DG3	5600	00	BEAM BOTTOM	
10	G4	5000	00	BEAM BOTTOM	
11	G5	5600	00	2150	
12	W1	2000	900	BEAM BOTTOM	
13	W2	2500	900	BEAM BOTTOM	
14	W3	2400	900	BEAM BOTTOM	
15	W4	1800	900	BEAM BOTTOM	
16	W5	1500	900	BEAM BOTTOM	
17	W6	1200	900	BEAM BOTTOM	
18	W7	900	900	BEAM BOTTOM	
19	W8	1275	1200	2150	
20	V1	600	2150	BEAM BOTTOM	
21	F1	1500	2150	BEAM BOTTOM	

This drawing with all its contents is the sole intellectual property of the Hospital Services Consultancy Corporation (India) Ltd. Copying of this drawing or part thereof, or its use in any form whatsoever without the written permission of HSCC is prohibited.

NOTES

REV DATE DESCRIPTION

REVISION

PROJECT

RMNCH PROJECT

Proposed
100 Bedded Hospital
at
CHATTISGARH

TITLE

FIRST
FLOOR PLAN
(COVERED AREA=2050 SQ. MT.)

working DRAWINGS
(ARCHITECTURE)

HSCC/100 BED/TD/003
Drawing No.

R-0
Rev.

Job No. 1:150 Scale 27-05-2013 Date

App by Rev. by Prep. by

This drawing with all its contents is the sole intellectual property of the Hospital Services Consultancy Corporation (India) Ltd. Copying of this drawing or part thereof or its use in any form whatsoever without the written permission of HSCC is prohibited.

NOTES

REV	DATE	DESCRIPTION

PROJECT
RMNCH PROJECT
Proposed
100 Bedded Hospital
at
CHATTISGARH

TITLE
TERRACE
FLOOR PLAN


working DRAWINGS
(ARCHITECTURE)

HSCC/100 BED/TD/003
Drawing No. R-0
Rev.

Job No. 1:150
Scale 27-05-2013
Date

App by Rev. by Prep. by

HSCC (INDIA) LIMITED
(A GOVERNMENT OF INDIA ENTERPRISES)
HSCC
NEW DELHI INDIA

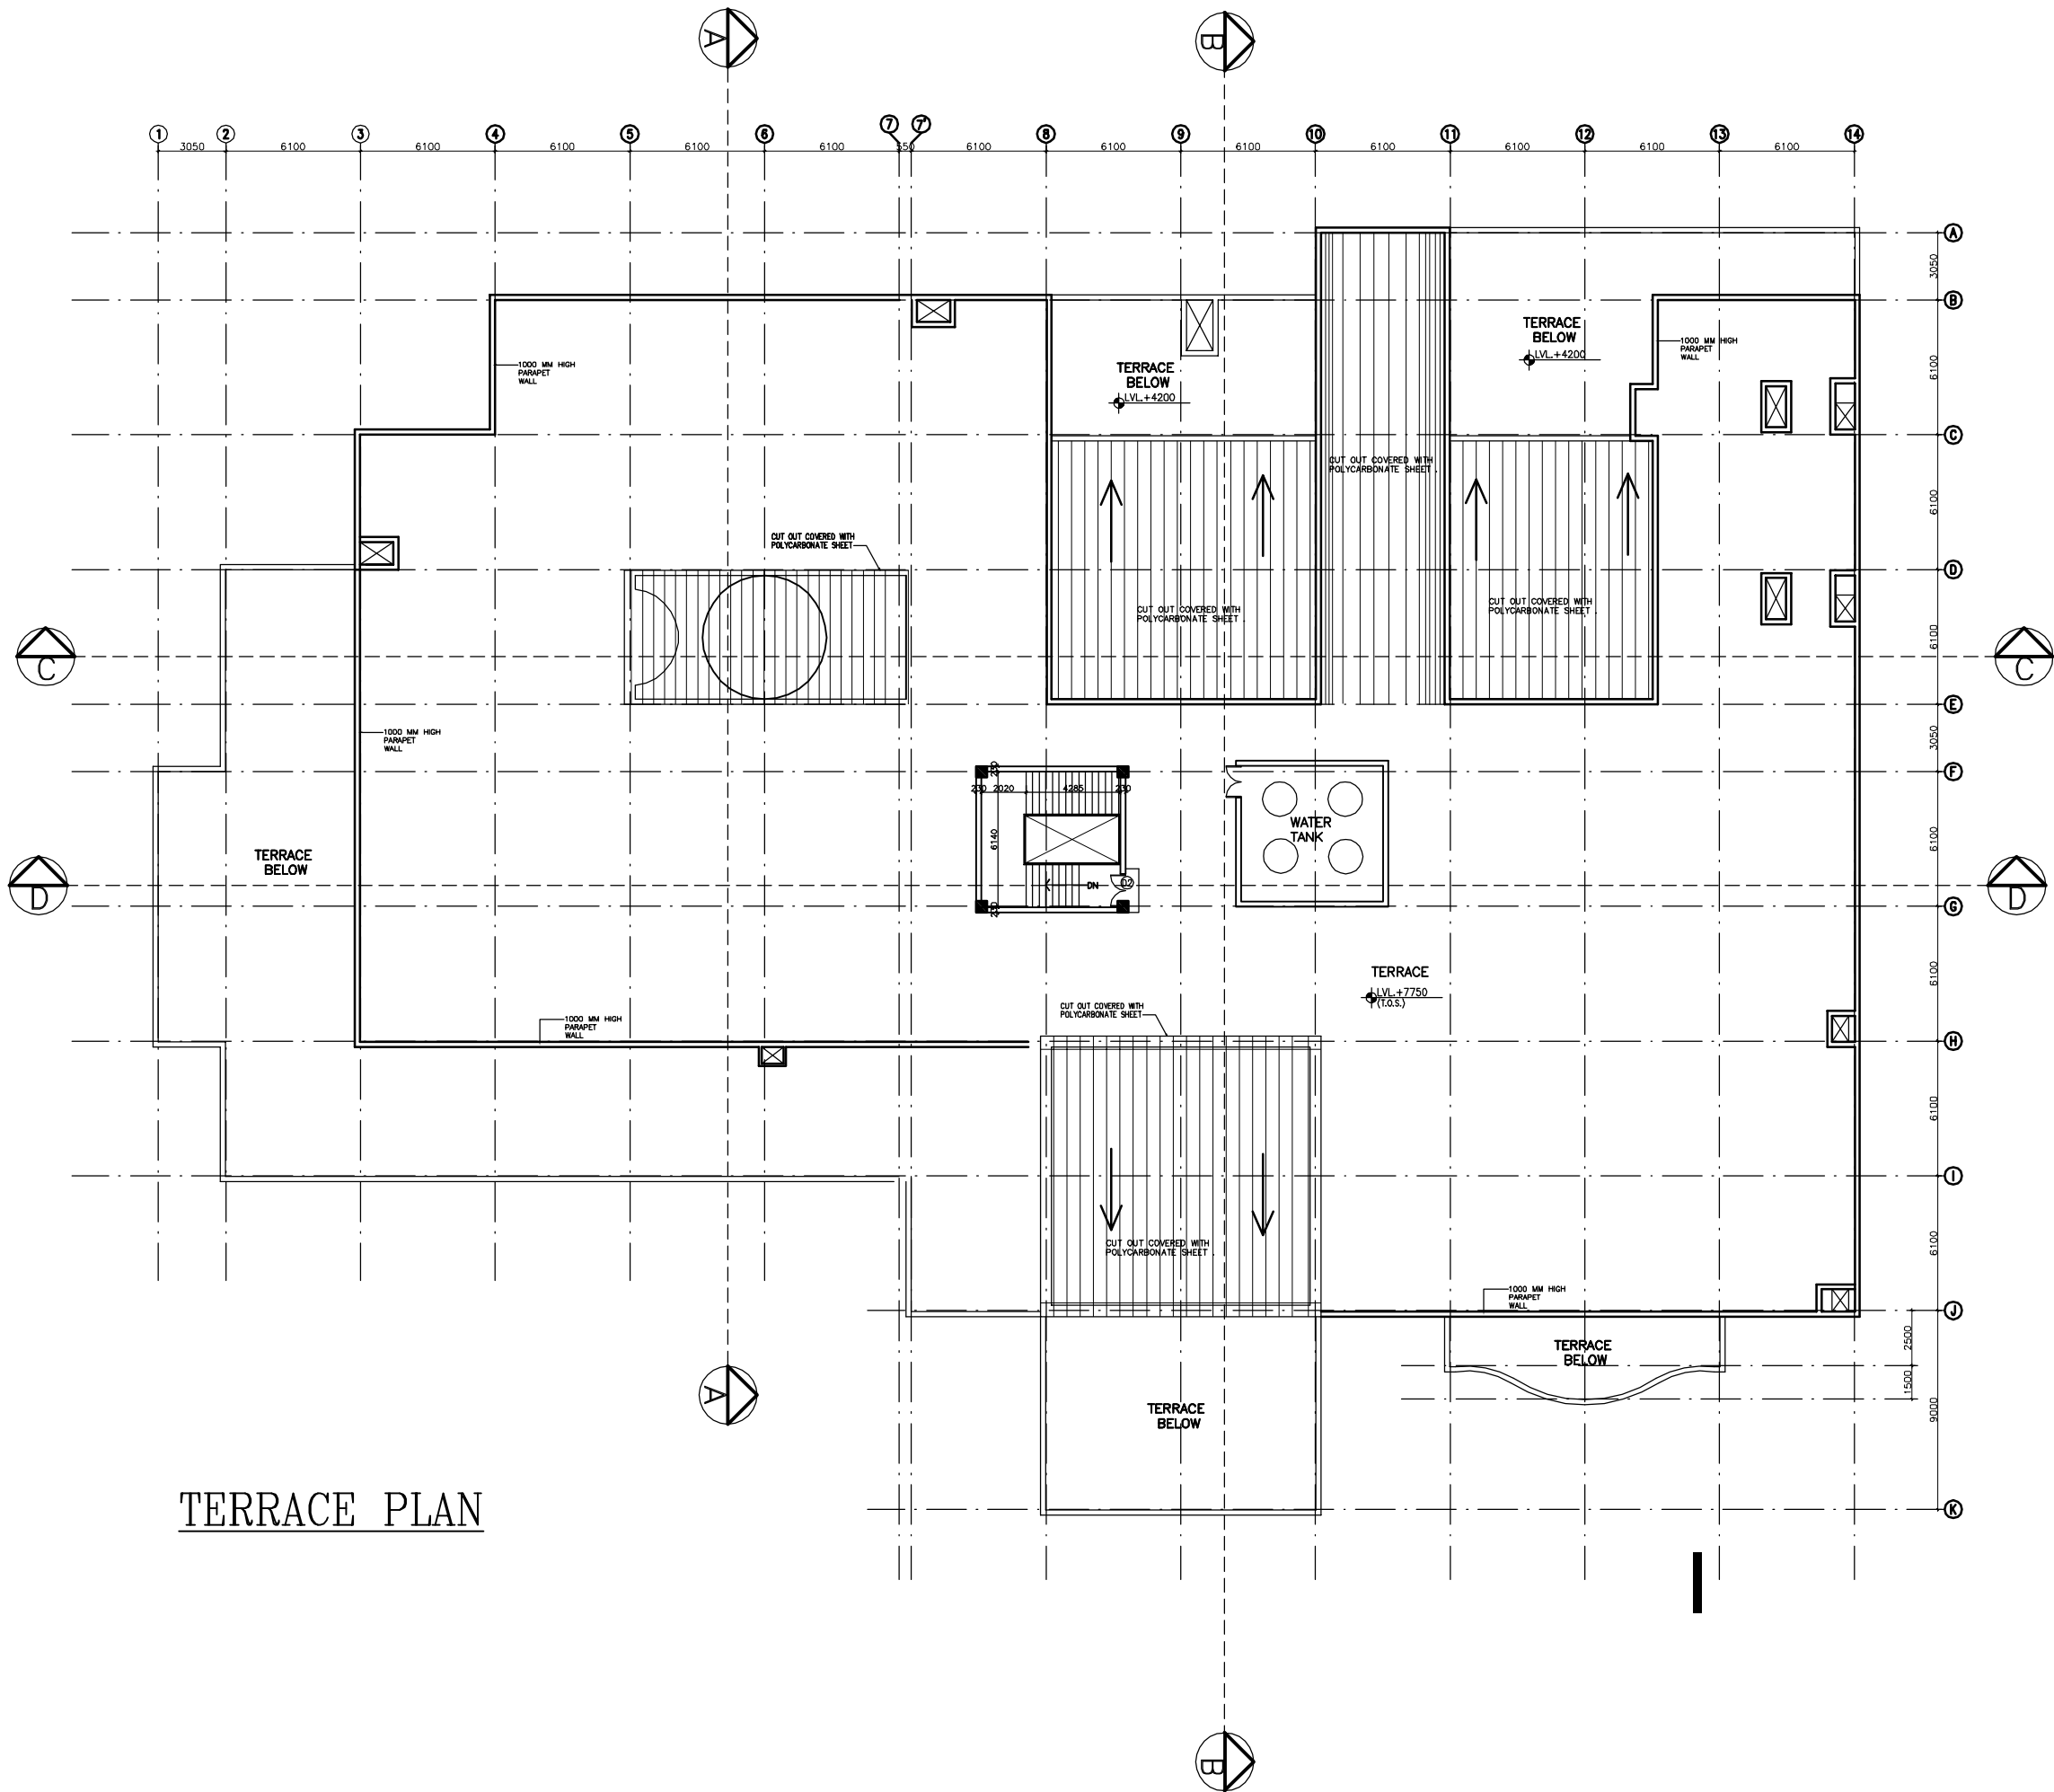

TERRACE PLAN

This drawing with all its contents is the sole intellectual property of the Hospital Services Consultancy Corporation (India) Ltd. Copying of this drawing or part thereof or its use in any form whatsoever without the written permission of HSCC is prohibited.

NOTES

REV	DATE	DESCRIPTION
REVISION		

PROJECT

RMNCH PROJECT
Proposed
100 Bedded Hospital
at
CHATTISGARH

TITLE


ELEVATION
working DRAWINGS
(ARCHITECTURE)

HSCC/100 BED/TD/004 Drawing No.		R-0 Rev.
Job No.	1:150 Scale	27-05-2013 Date
App. by	Rev. by	Prep. by

HSCC (INDIA) LIMITED
(A GOVERNMENT OF INDIA ENTERPRISES)
HSCC
NEW DELHI INDIA




ELEVATION A

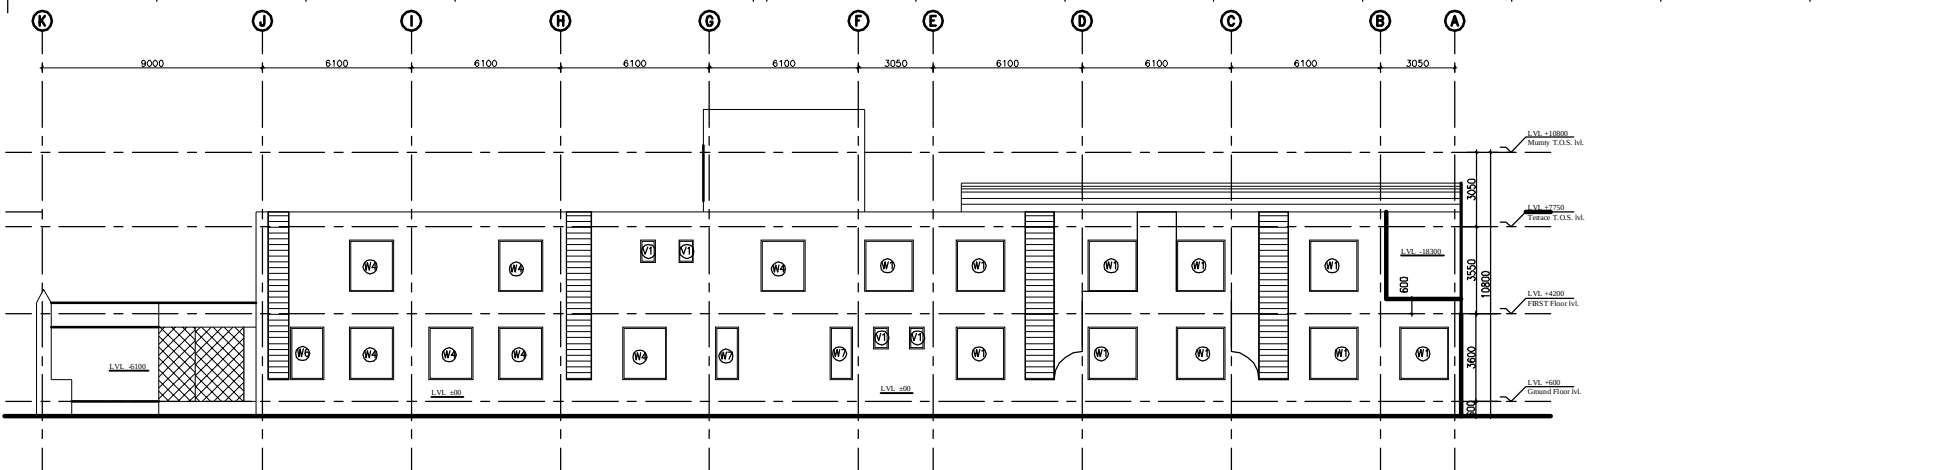


ELEVATION B




ELEVATION C

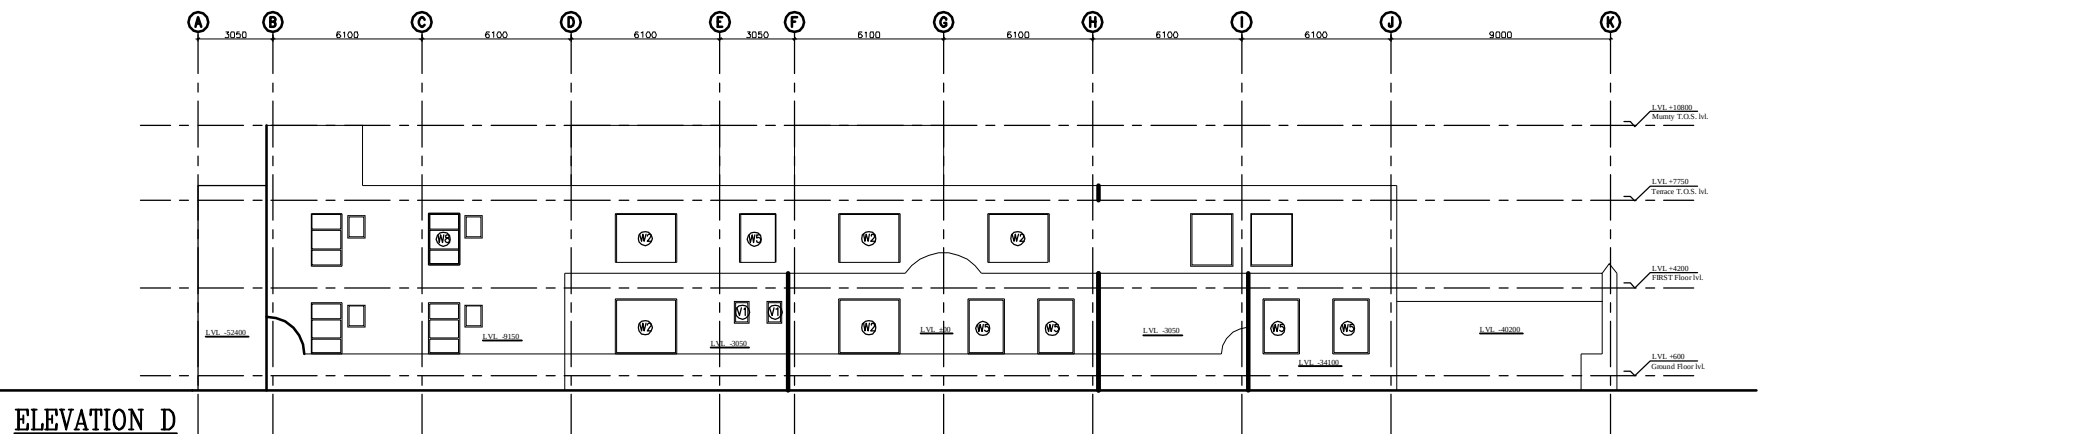


ELEVATION D

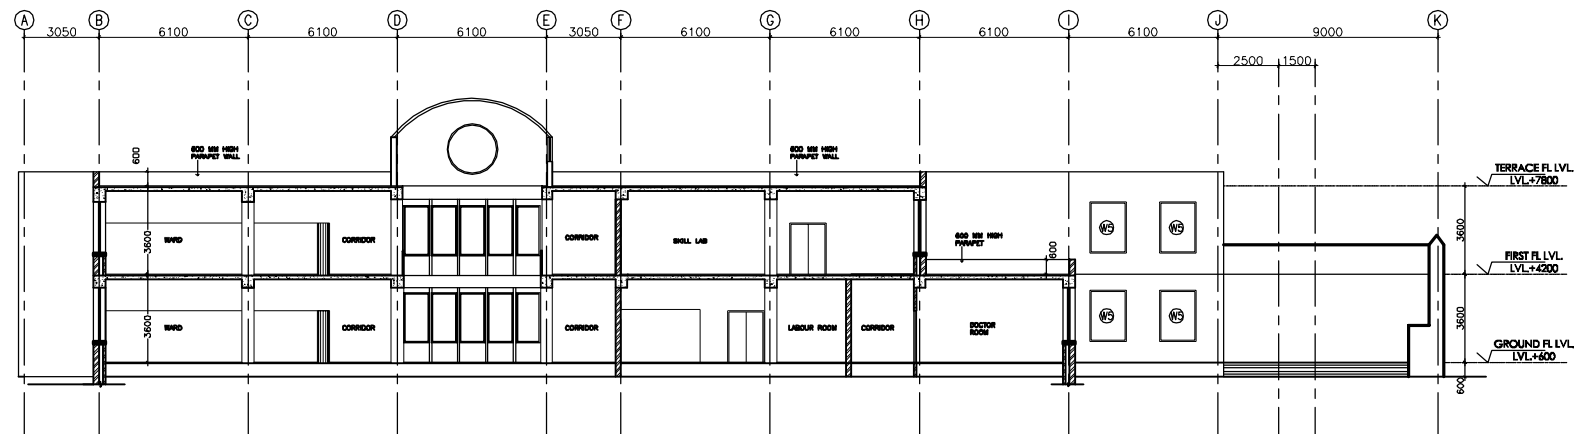


SECTION A-A

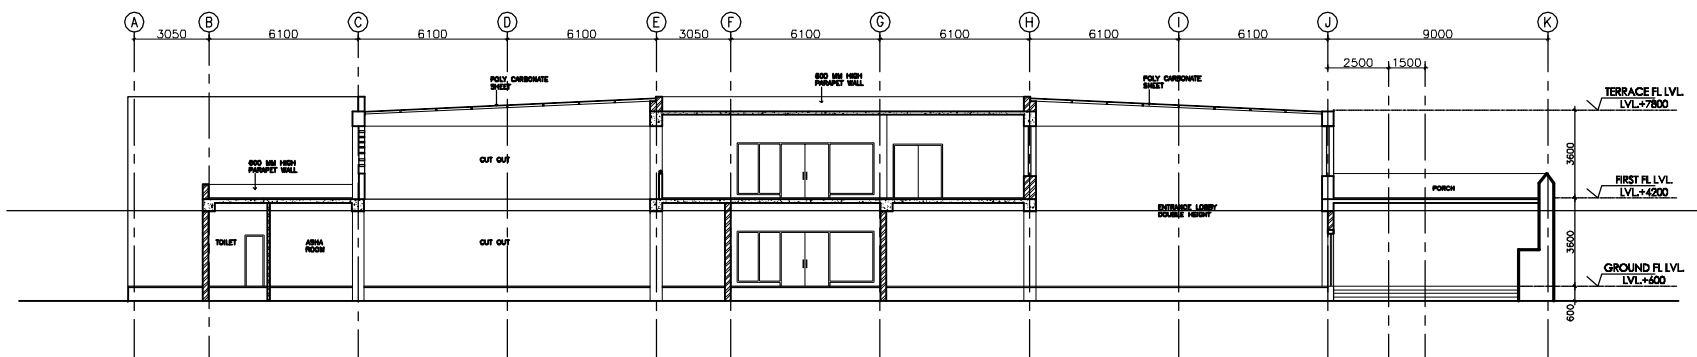

SECTION B-B

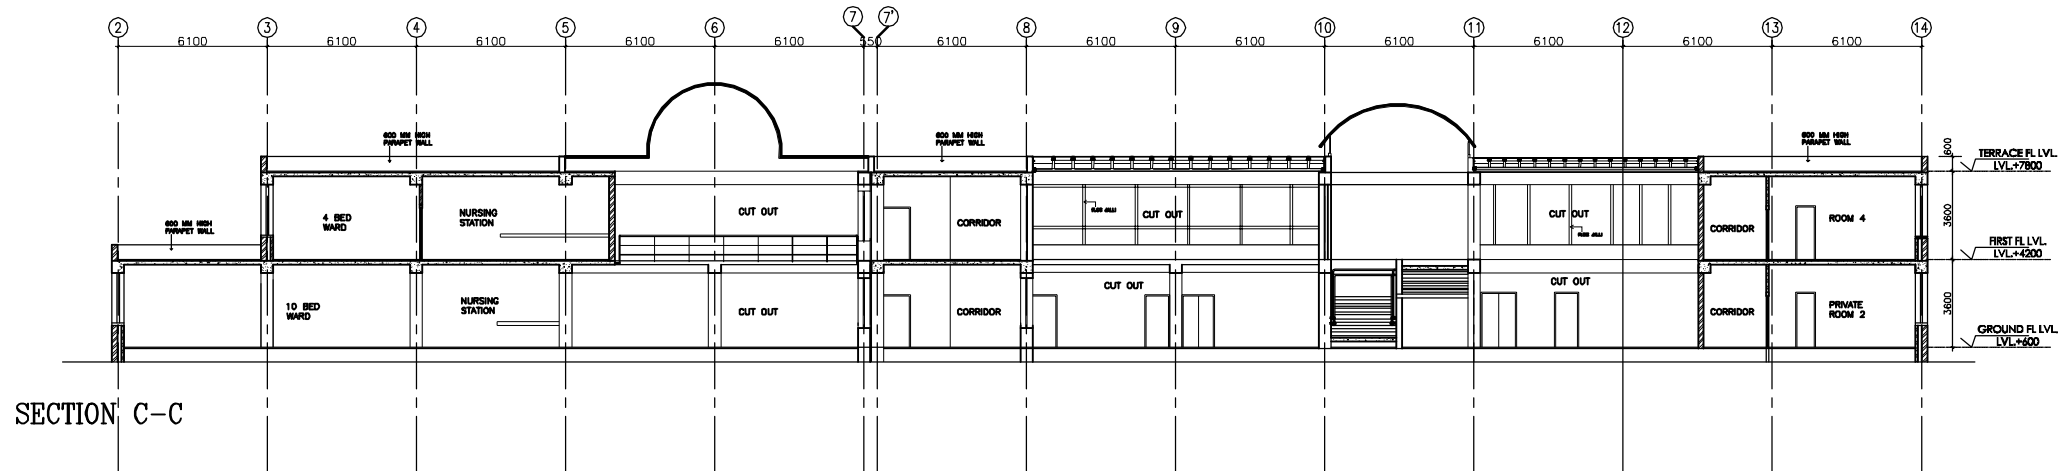

SECTION C-C

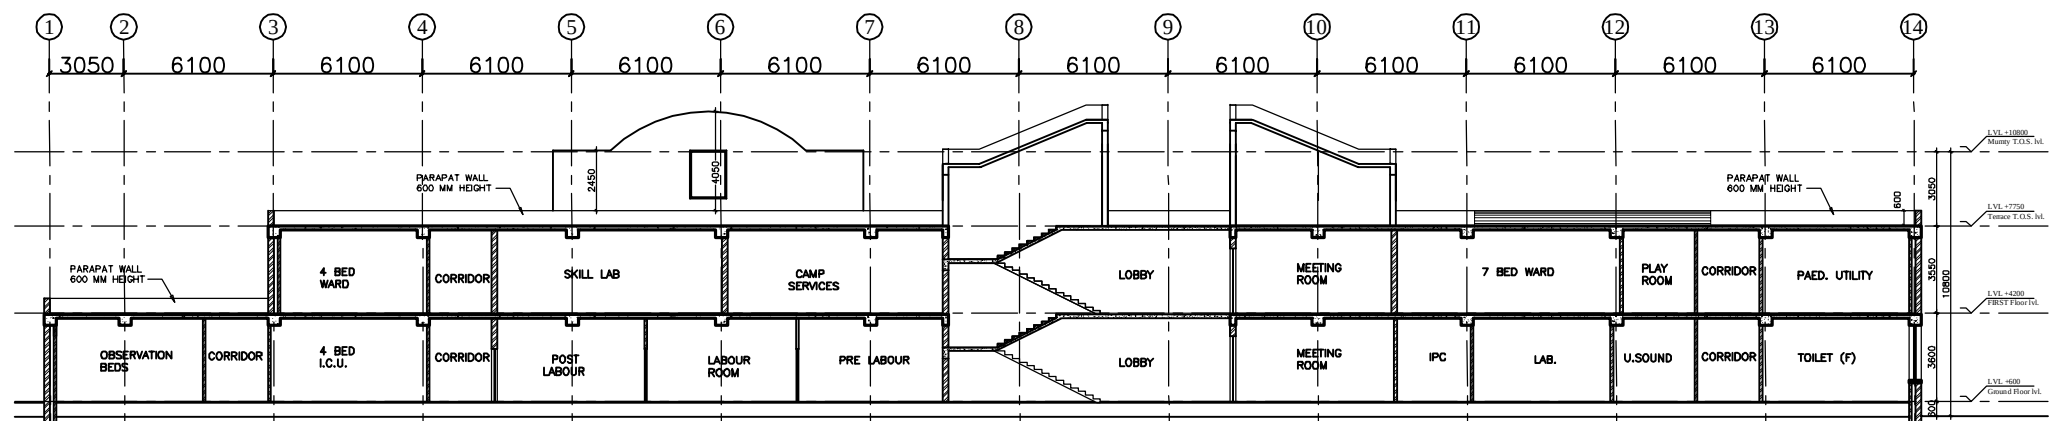

SECTION D-D

This drawing with all its contents is the sole intellectual property of the Hospital Services Consultancy Corporation (India) Ltd. Copying of this drawing or part thereof or its use in any form whatsoever without the written permission of HSCC is prohibited.

NOTES

REV	DATE	DESCRIPTION
REVISION		

PROJECT

RMNCH PROJECT

Proposed
100 Bedded Hospital
at
SARGUJA, CHATTISGARH

TITLE

SECTIONS

working DRAWINGS
(ARCHITECTURE)

HSCC/100 BED/TD/005
Drawing No.

R-0
Rev.

Job No.

1:150
Scale

27-05-2013
Date

App by

Rev. by



Prep. by

HSCC (INDIA) LIMITED
(A GOVERNMENT OF INDIA ENTERPRISES)

HSCC
NEW DELHI INDIA

NOTES

1. ALL DIMENSIONS ARE IN mm & LVLS IN m.
2. READ IN CONJUNCTION WITH RELEVANT ARCH. DRG.
3. FINISHED FLOOR LVL TO BE CONFIRMED AS/ARCH. DRGS, THE SLAB TOP LEVEL TO BE WORKED OUT SUITABLY CONSIDERING FLOOR FINISH THICKNESS.
4. CLEAR COVER OF R/F TO BE AS BELOW:-
FOUNDATION = 50mm
COLUMN = 40mm
BEAM = 30mm
SLAB = 25mm
5. CONC. MIX. TO BE M-25 FOR ALL RCC WORK AS PER IS:456-2000
6. ALL R/F BARS TO BE Fe500 Mpa. HYSD OR TMT STEEL AS PER IS:1786.
7. ALL LAP LENGTHS = 50xSMALLER BAR ϕ . ALL LAPS TO PLANNED SUITABLY AS PER SITE REQUIREMENT.
8. DEVELOPEMENT LENGTH = 50xBAR ϕ .
9. SBC ASSUMED 120 kN/M² AT 2.0 METER BELOW N.G.L.

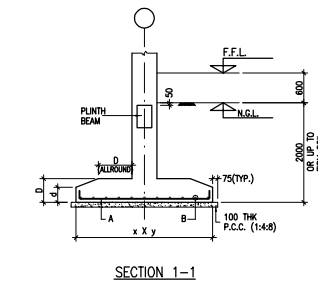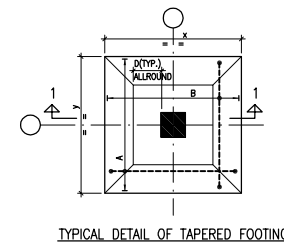

FOOTING SCHEDULE

S.No	MKD.	SIZE(x/y)	THK. (d)	THK. (D)	REMARKS
1	F1	1500x1500	200	300	TAPERED
2	F2	1800x1800	250	350	TAPERED
3	F3	2250x2250	250	400	TAPERED
4	F4	2750x2750	250	450	TAPERED
5	F5	3000x3000	300	500	TAPERED
6	F6	3200x3200	300	550	TAPERED
7	F7	3700x3700	300	600	TAPERED
8	CF1	2400x14650	-	600	COMBINED
9	CF2	4000x6250	-	600	COMBINED

FOUNDATION LAYOUT PLAN

OVERALL REVISED AS PER ARCH.

FOR TENDER

REVISION

PROJECT

PROPOSED
100 BEDDED HOSPITAL
RMNCH PROJECT,

CHATTISGARH

TITLE

FOUNDATION LAYOUT PLAN

HSCC/RMNCH/D&E/ST-T-1001

Drawing No. REV. 1

HSCC/RMNCH 1:150 APRIL-2013
JOB No. SCALE DATE

APPROVED REVIEWED PREPARED

HSCC INDIA LTD.
(A GOVERNMENT OF INDIA ENTERPRISE)

HSCC
NEW DELHI INDIA



This drawing with all its contents is the sole intellectual property of the Hospital Services Consultancy Corporation (India) Ltd. Copying of this drawing or part thereof or its use in any form whatsoever without the written permission of HSCC is prohibited.

NOTES

1. ALL DIMENSIONS ARE IN mm & LVLS IN m.
2. READ IN CONJUNCTION WITH RELEVANT ARCH. DRG.
3. FINISHED FLOOR LVL TO BE CONFIRMED AS/ARCH. DRGS, THE SLAB TOP LEVEL TO BE WORKED OUT SUITABLY CONSIDERING FLOOR FINISH THICKNESS.
4. CLEAR COVER OF R/F TO BE AS BELOW:-
FOUNDATION = 50mm
COLUMN = 40mm
BEAM = 30mm
SLAB = 25mm
5. CONC. MIX. TO BE M-25 FOR ALL RCC WORK AS PER IS:456-2000
6. ALL R/F BARS TO BE Fe500 Mpa. HYSD OR TMT STEEL AS PER IS:1786.
7. ALL LAP LENGTHS = 50xSMALLER BAR ϕ . ALL LAPS TO PLANNED SUITABLY AS PER SITE REQUIREMENT.
8. DEVELOPEMENT LENGTH = 50xBAR ϕ .

REV	DATE	DESCRIPTION
1	01.04.13	OVERALL REVISED AS PER ARCH.
0	27.02.13	FOR TENDER

REVISION

PROJECT

PROPOSED
100 BEDDED HOSPITAL
RMNCH PROJECT,

CHATTISGARH

TITLE


PLINTH BEAM FRAMING PLAN

HSCC/RMNCH/D&E/ST-T-1003


Drawing No.	REV. 1
HSCC/RMNCH JOB No.	1:150 SCALE APRIL-2013 DATE
APPROVED	REVIEWED PREPARED

HSCC INDIA LTD.
(A GOVERNMENT OF INDIA ENTERPRISE)

HSCC
NEW DELHI INDIA

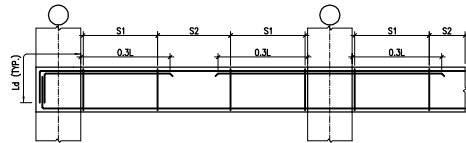

TYP. BEAM R/F DETAILS

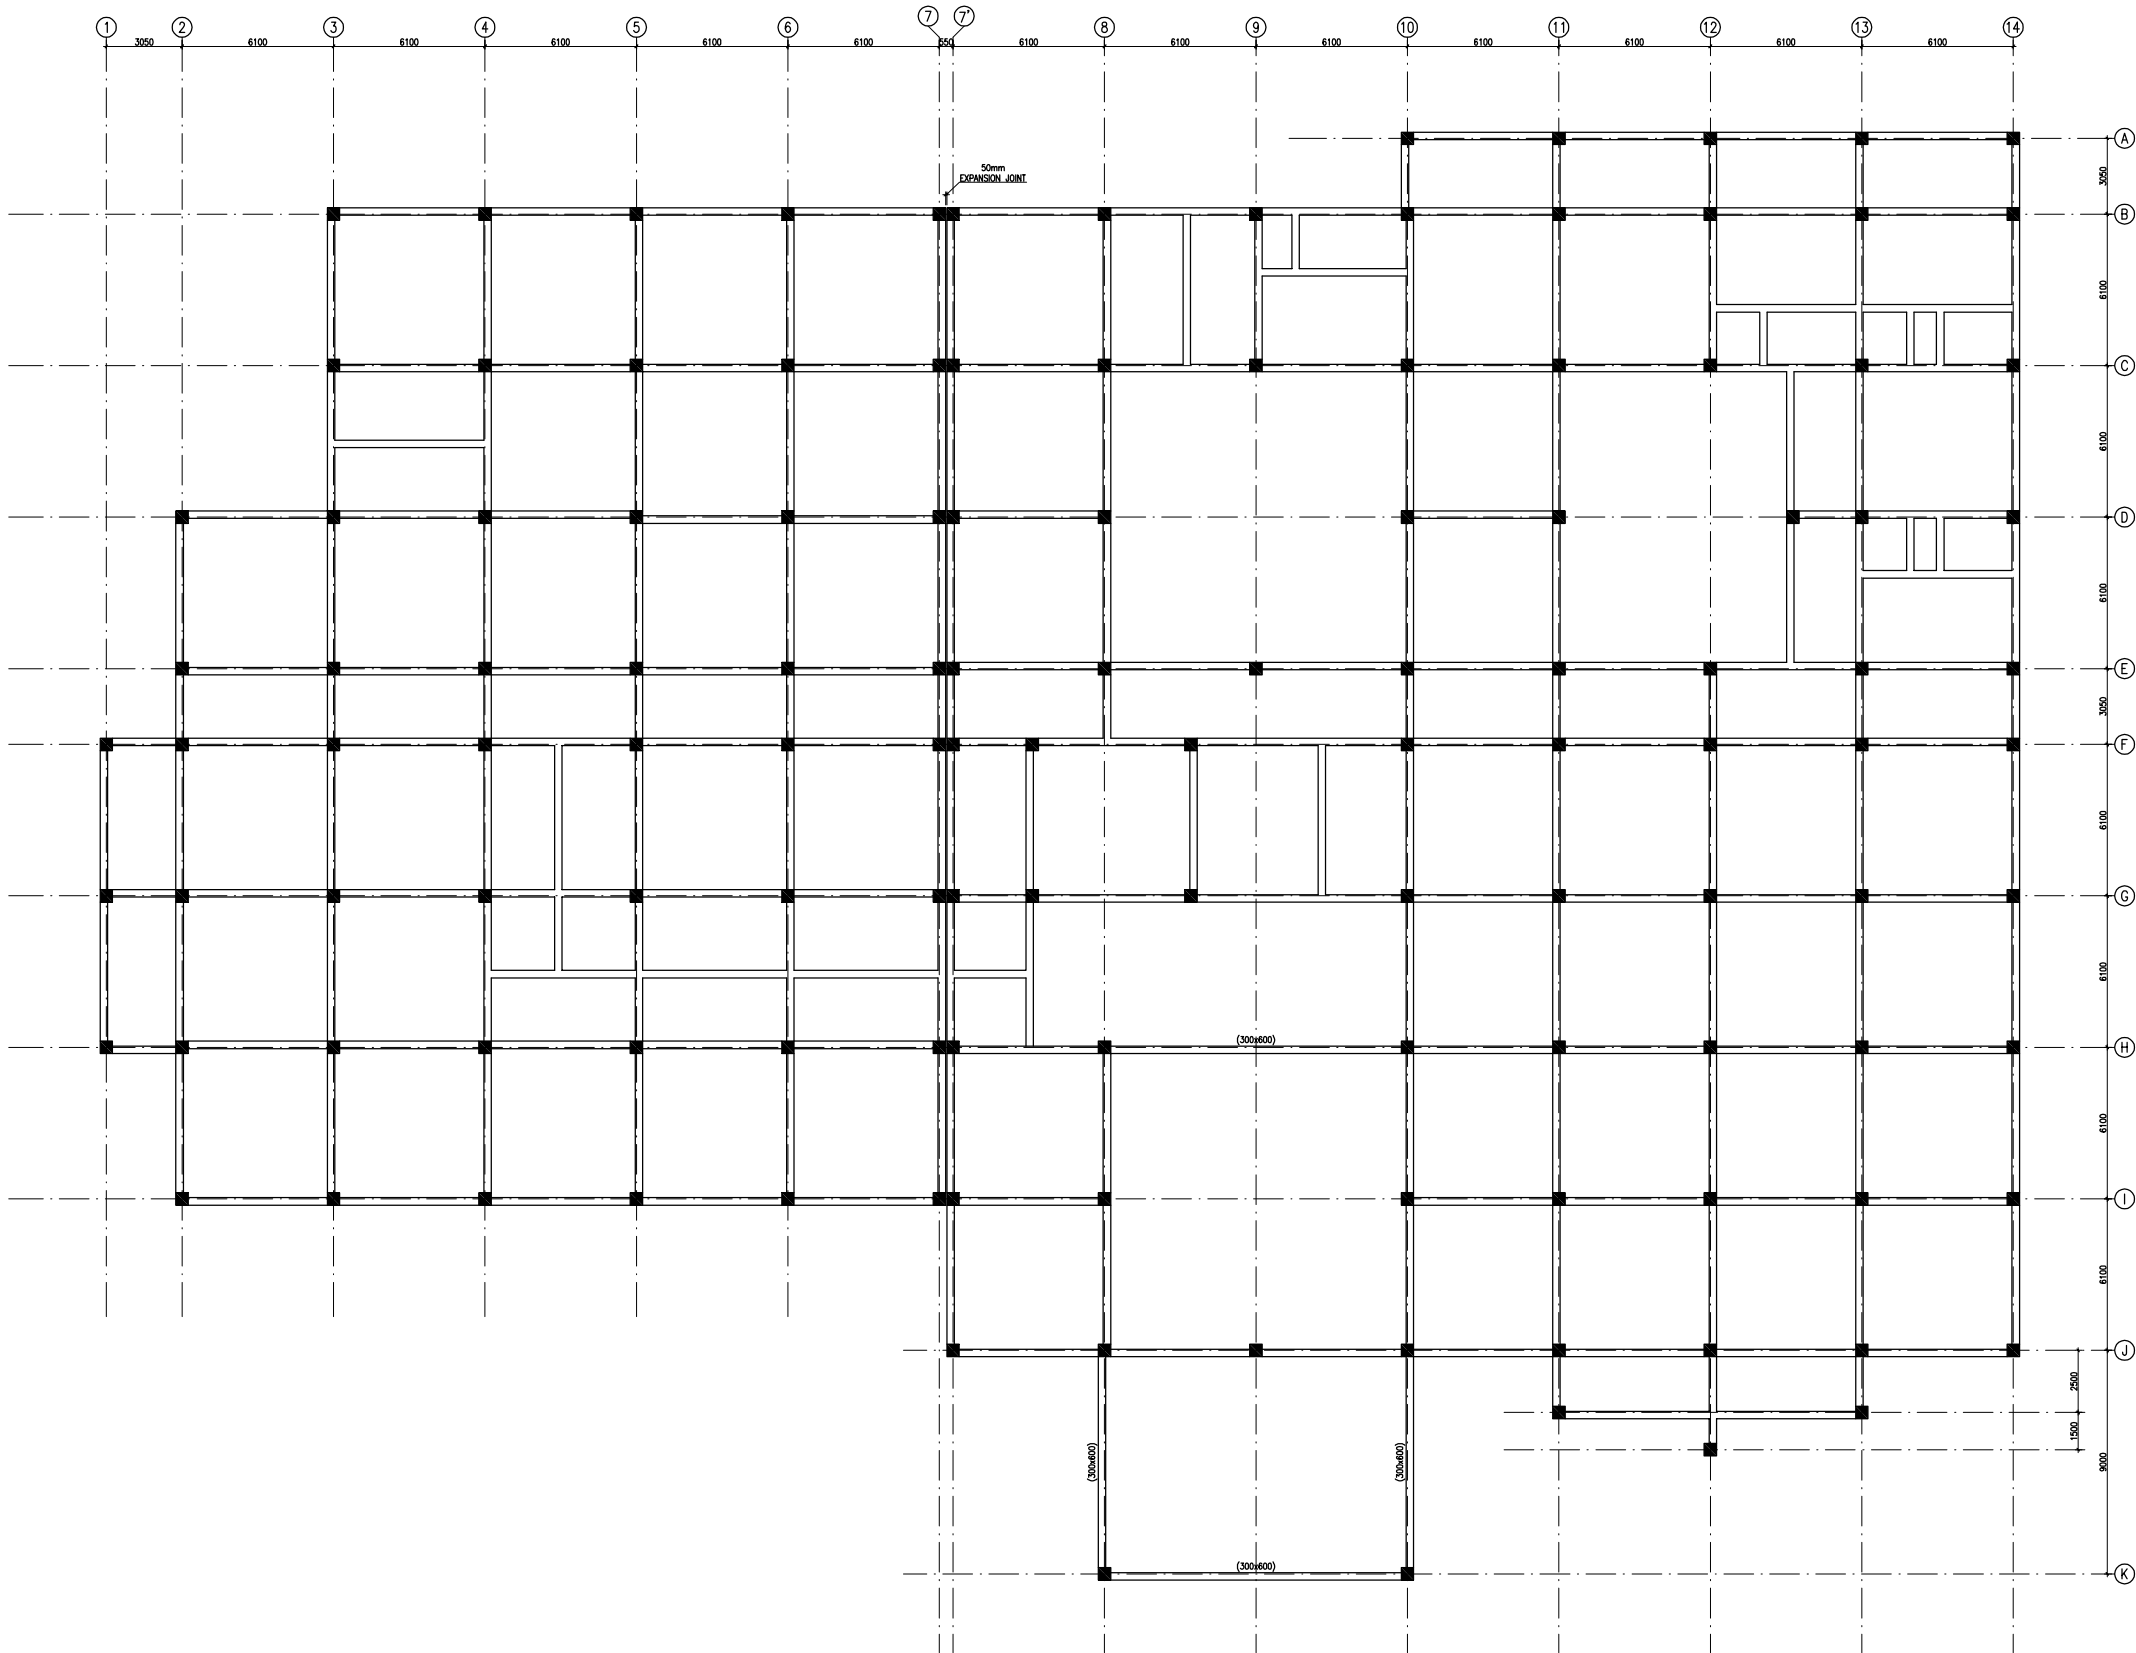

PLINTH BEAM FRAMING PLAN
(ALL BEAMS SIZE 300x450 UNLS.)

- NOTES
1. ALL DIMENSIONS ARE IN mm & LVLS IN m.

2. READ IN CONJUNCTION WITH RELEVANT ARCH. DRG.

3. FINISHED FLOOR LVL TO BE CONFIRMED AS/ARCH. DRGS, THE SLAB TOP LEVEL TO BE WORKED OUT SUITABLY CONSIDERING FLOOR FINISH THICKNESS.

4. CLEAR COVER OF R/F TO BE AS BELOW:-

FOUNDATION

= 50mm

COLUMN

= 40mm

BEAM

= 30mm

SLAB

= 25mm

5. CONC. MIX. TO BE M-25 FOR ALL RCC WORK AS PER IS:456-2000

6. ALL R/F BARS TO BE Fe500 Mpa. HYSD OR TMT STEEL AS PER IS:1786.

7. ALL LAP LENGTHS = 50xSMALLER BAR ϕ . ALL LAPS TO PLANNED SUITABLY AS PER SITE REQUIREMENT.

8. DEVELOPEMENT LENGTH = 50xBAR ϕ .

1	01.04.13	OVERALL REVISED AS PER ARCH.
0	27.02.13	FOR TENDER
REV	DATE	DESCRIPTION

REVISION

PROJECT

PROPOSED
100 BEDDED HOSPITAL
RMNCH PROJECT,


CHATTISGARH

TITLE

COLUMN LAYOUT PLAN

HSCC/RMNCH/D&E/ST-T-1002

Drawing No.	REV. 1
HSCC/RMNCH JOB No.	1:150 SCALE
APRIL-2013 DATE	
APPROVED	REVIEWED
PREPARED	

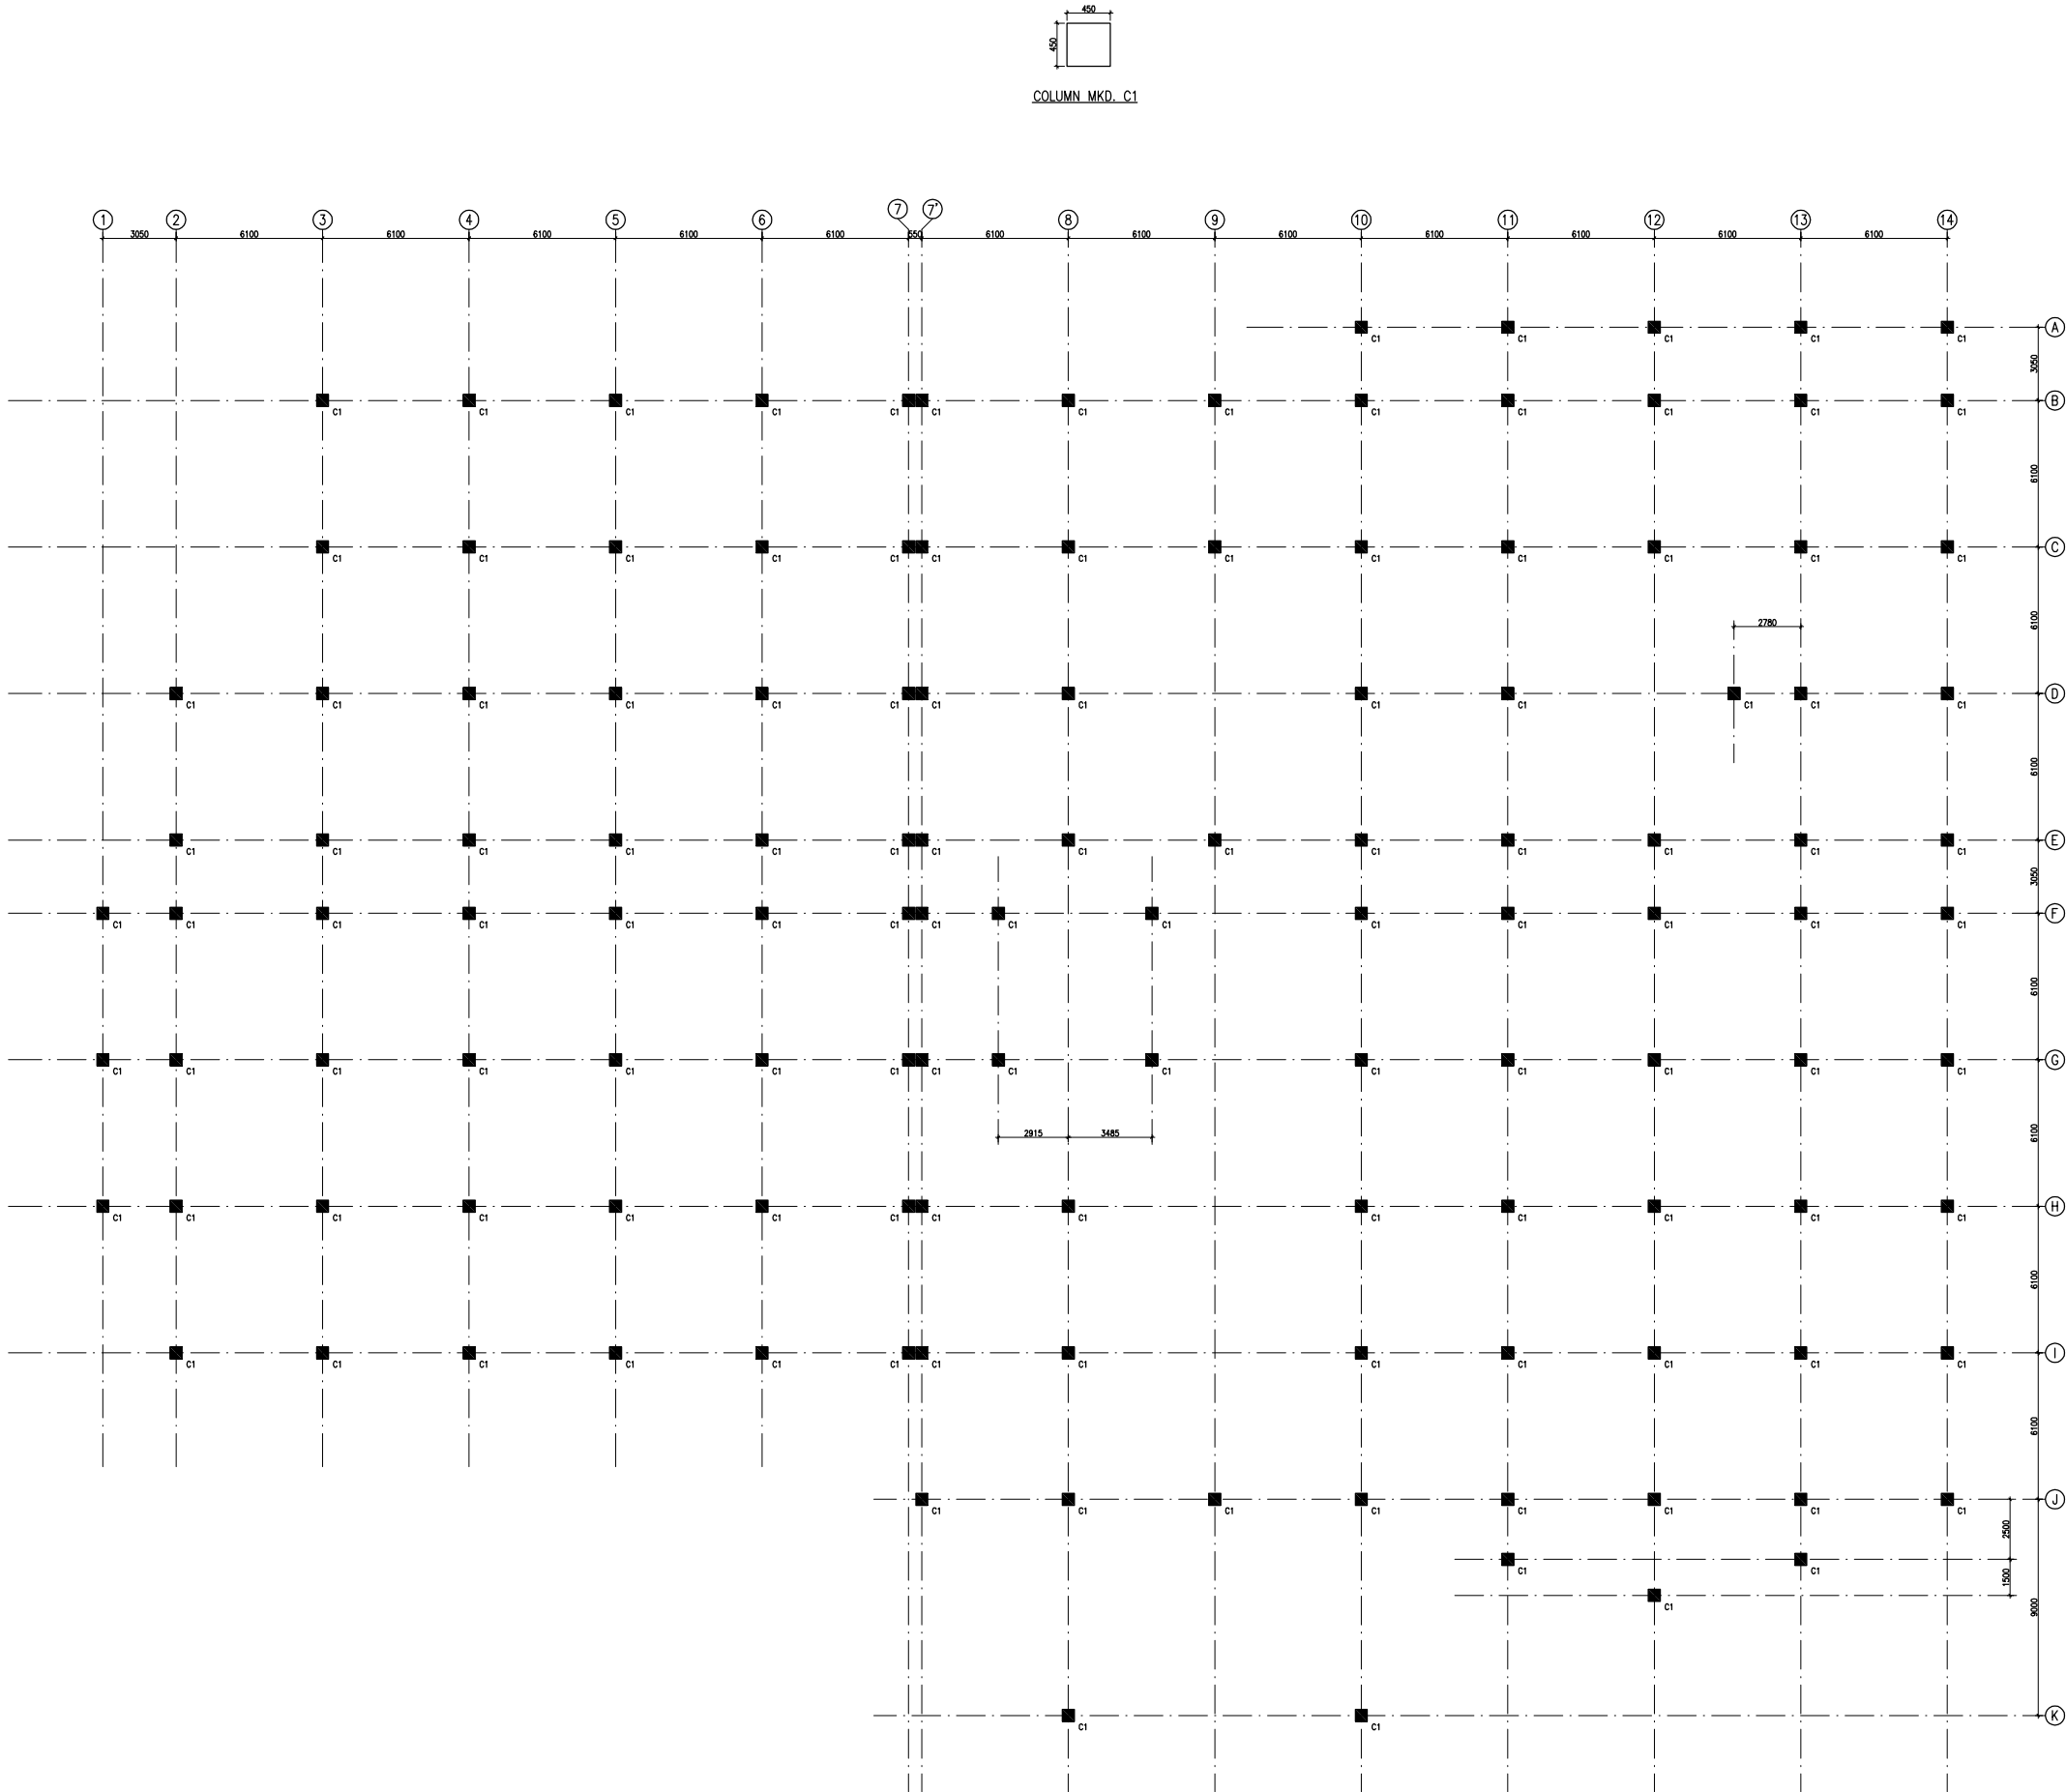

COLUMN LAYOUT PLAN



This drawing with all its contents is the sole intellectual property of the Hospital Services Consultancy Corporation (India) Ltd. Copying of this drawing or part thereof or its use in any form whatsoever without the written permission of HSCC is prohibited.

NOTES

1. ALL DIMENSIONS ARE IN mm & LVLS IN m.
2. READ IN CONJUNCTION WITH RELEVANT ARCH. DRG.
3. FINISHED FLOOR LVL TO BE CONFIRMED AS/ARCH. DRGS, THE SLAB TOP LEVEL TO BE WORKED OUT SUITABLY CONSIDERING FLOOR FINISH THICKNESS.
4. CLEAR COVER OF R/F TO BE AS BELOW:-
FOUNDATION = 50mm
COLUMN = 40mm
BEAM = 30mm
SLAB = 25mm
5. CONC. MIX. TO BE M-25 FOR ALL RCC WORK AS PER IS:456-2000
6. ALL R/F BARS TO BE Fe500 Mpa. HYSD OR TMT STEEL AS PER IS:1786.
7. ALL LAP LENGTHS = 50xSMALLER BAR ϕ . ALL LAPS TO PLANNED SUITABLY AS PER SITE REQUIREMENT.
8. DEVELOPEMENT LENGTH = 50xBAR ϕ .

REV	DATE	DESCRIPTION
1	01.04.13	OVERALL REVISED AS PER ARCH.
0	27.02.13	FOR TENDER

REVISION

PROJECT

PROPOSED
100 BEDDED HOSPITAL
RMNCH PROJECT,

CHATTISGARH

TITLE


FIRST FLOOR BEAM FRAMING PLAN

HSCC/RMNCH/D&E/ST-T-1004


Drawing No.	REV. 1
HSCC/RMNCH JOB No.	1:150 SCALE APRIL-2013 DATE
APPROVED	REVIEWED
PREPARED	

HSCC INDIA LTD.
(A GOVERNMENT OF INDIA ENTERPRISE)


HSCC
NEW DELHI INDIA

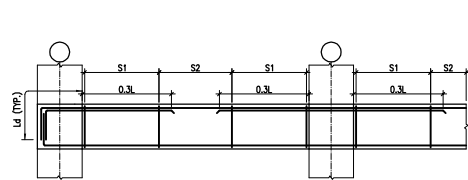


TYP. BEAM R/F DETAILS

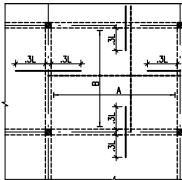

TYP. SLAB R/F DETAIL

 

TYP. SUNKEN SLAB R/F DETAIL

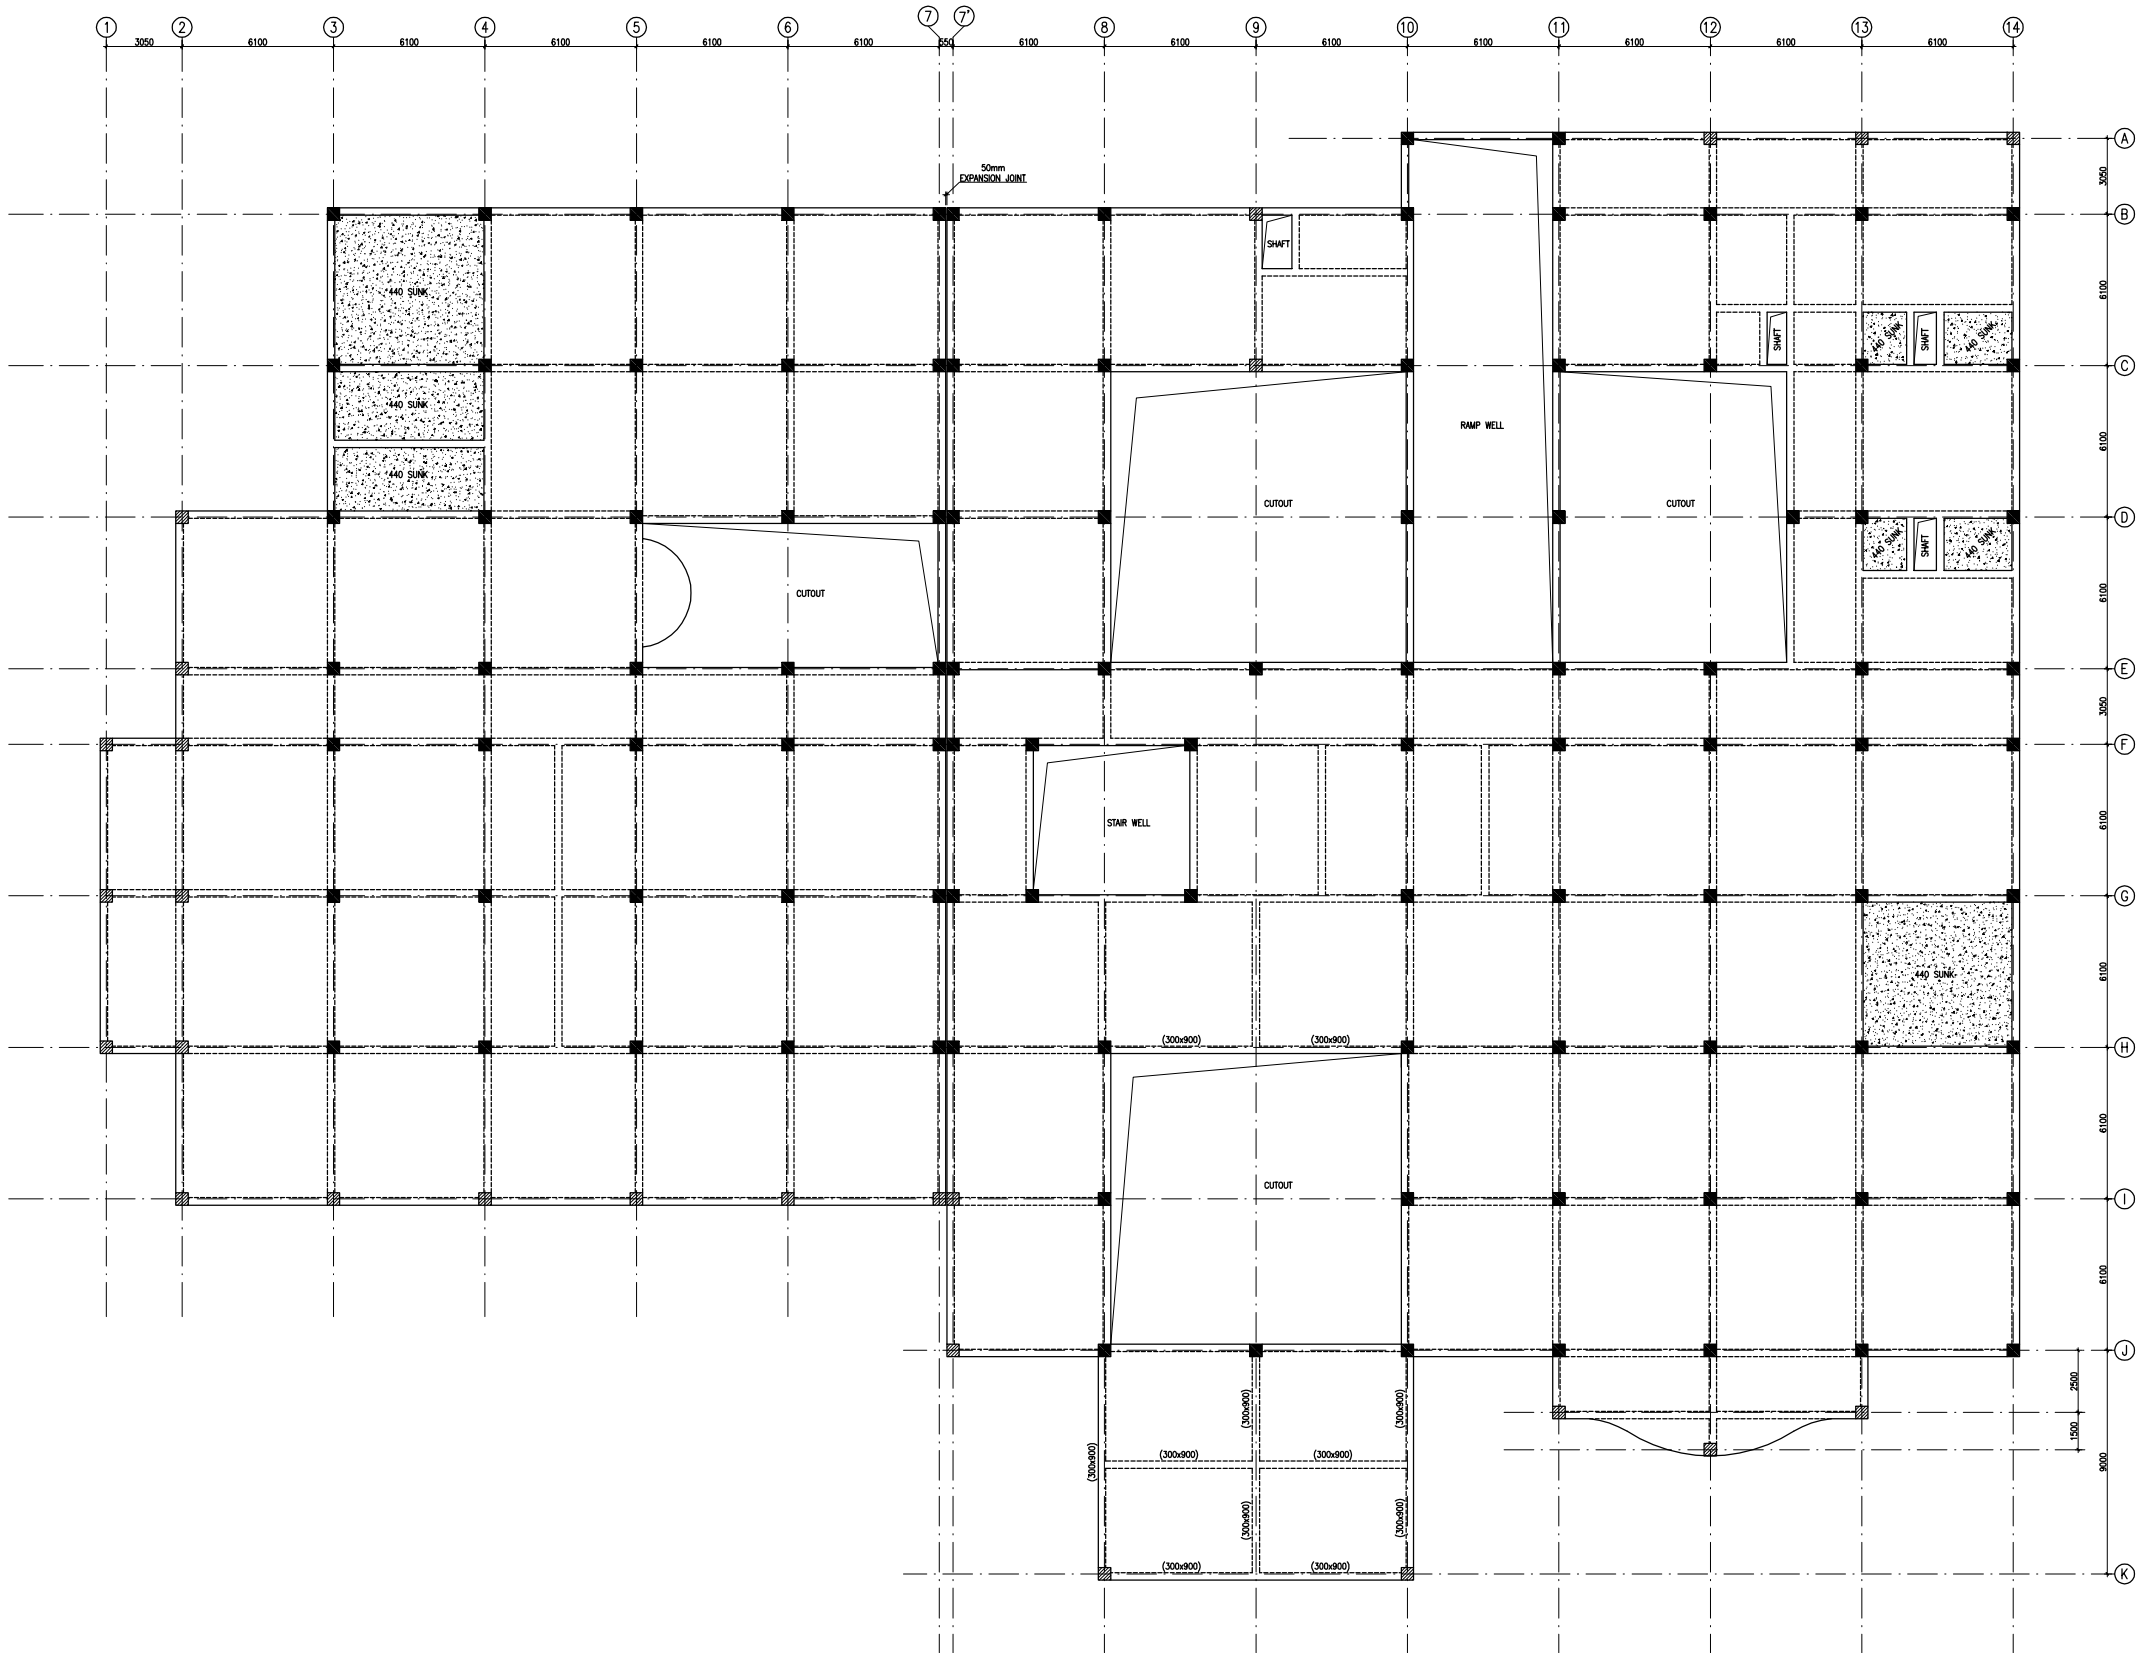

FIRST FLOOR BEAM FRAMING PLAN
(ALL BEAMS SIZE 300x900 U.N.G.) & (SLAB THICKNESS 160mm U.N.G.)



This drawing with all its contents is the sole intellectual property of the Hospital Services Consultancy Corporation (India) Ltd. Copying of this drawing or part thereof or its use in any form whatsoever without the written permission of HSCC is prohibited.

NOTES

1. ALL DIMENSIONS ARE IN mm & LVLS IN m.
2. READ IN CONJUNCTION WITH RELEVANT ARCH. DRG.
3. FINISHED FLOOR LVL TO BE CONFIRMED AS/ARCH. DRGS, THE SLAB TOP LEVEL TO BE WORKED OUT SUITABLY CONSIDERING FLOOR FINISH THICKNESS.
4. CLEAR COVER OF R/F TO BE AS BELOW:-
FOUNDATION = 50mm
COLUMN = 40mm
BEAM = 30mm
SLAB = 25mm
5. CONC. MIX. TO BE M-25 FOR ALL RCC WORK AS PER IS:456-2000
6. ALL R/F BARS TO BE Fe500 Mpa. HYSD OR TMT STEEL AS PER IS:1786.
7. ALL LAP LENGTHS = 50xSMALLER BAR ϕ . ALL LAPS TO PLANNED SUITABLY AS PER SITE REQUIREMENT.
8. DEVELOPEMENT LENGTH = 50xBAR ϕ .

1	01.04.13	OVERALL REVISED AS PER ARCH.
0	27.02.13	FOR TENDER

REV	DATE	DESCRIPTION
-----	------	-------------

REVISION

PROJECT

PROPOSED
100 BEDDED HOSPITAL
RMNCH PROJECT,

CHATTISGARH

TITLE


TERRACE LVL. BEAM FRAMING PLAN

HSCC/RMNCH/D&E/ST-T-1005


Drawing No.	REV. 1
HSCC/RMNCH JOB No.	1:150 SCALE
APRIL-2013 DATE	
APPROVED	REVIEWED
PREPARED	

HSCC INDIA LTD.
(A GOVERNMENT OF INDIA ENTERPRISE)


HSCC
NEW DELHI INDIA

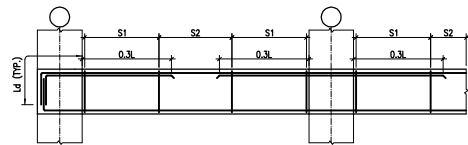


TYP. BEAM R/F DETAILS

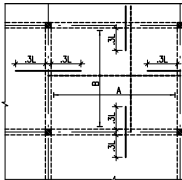


TYP. SLAB R/F DETAIL

 

TYP. SUNKEN SLAB R/F DETAIL

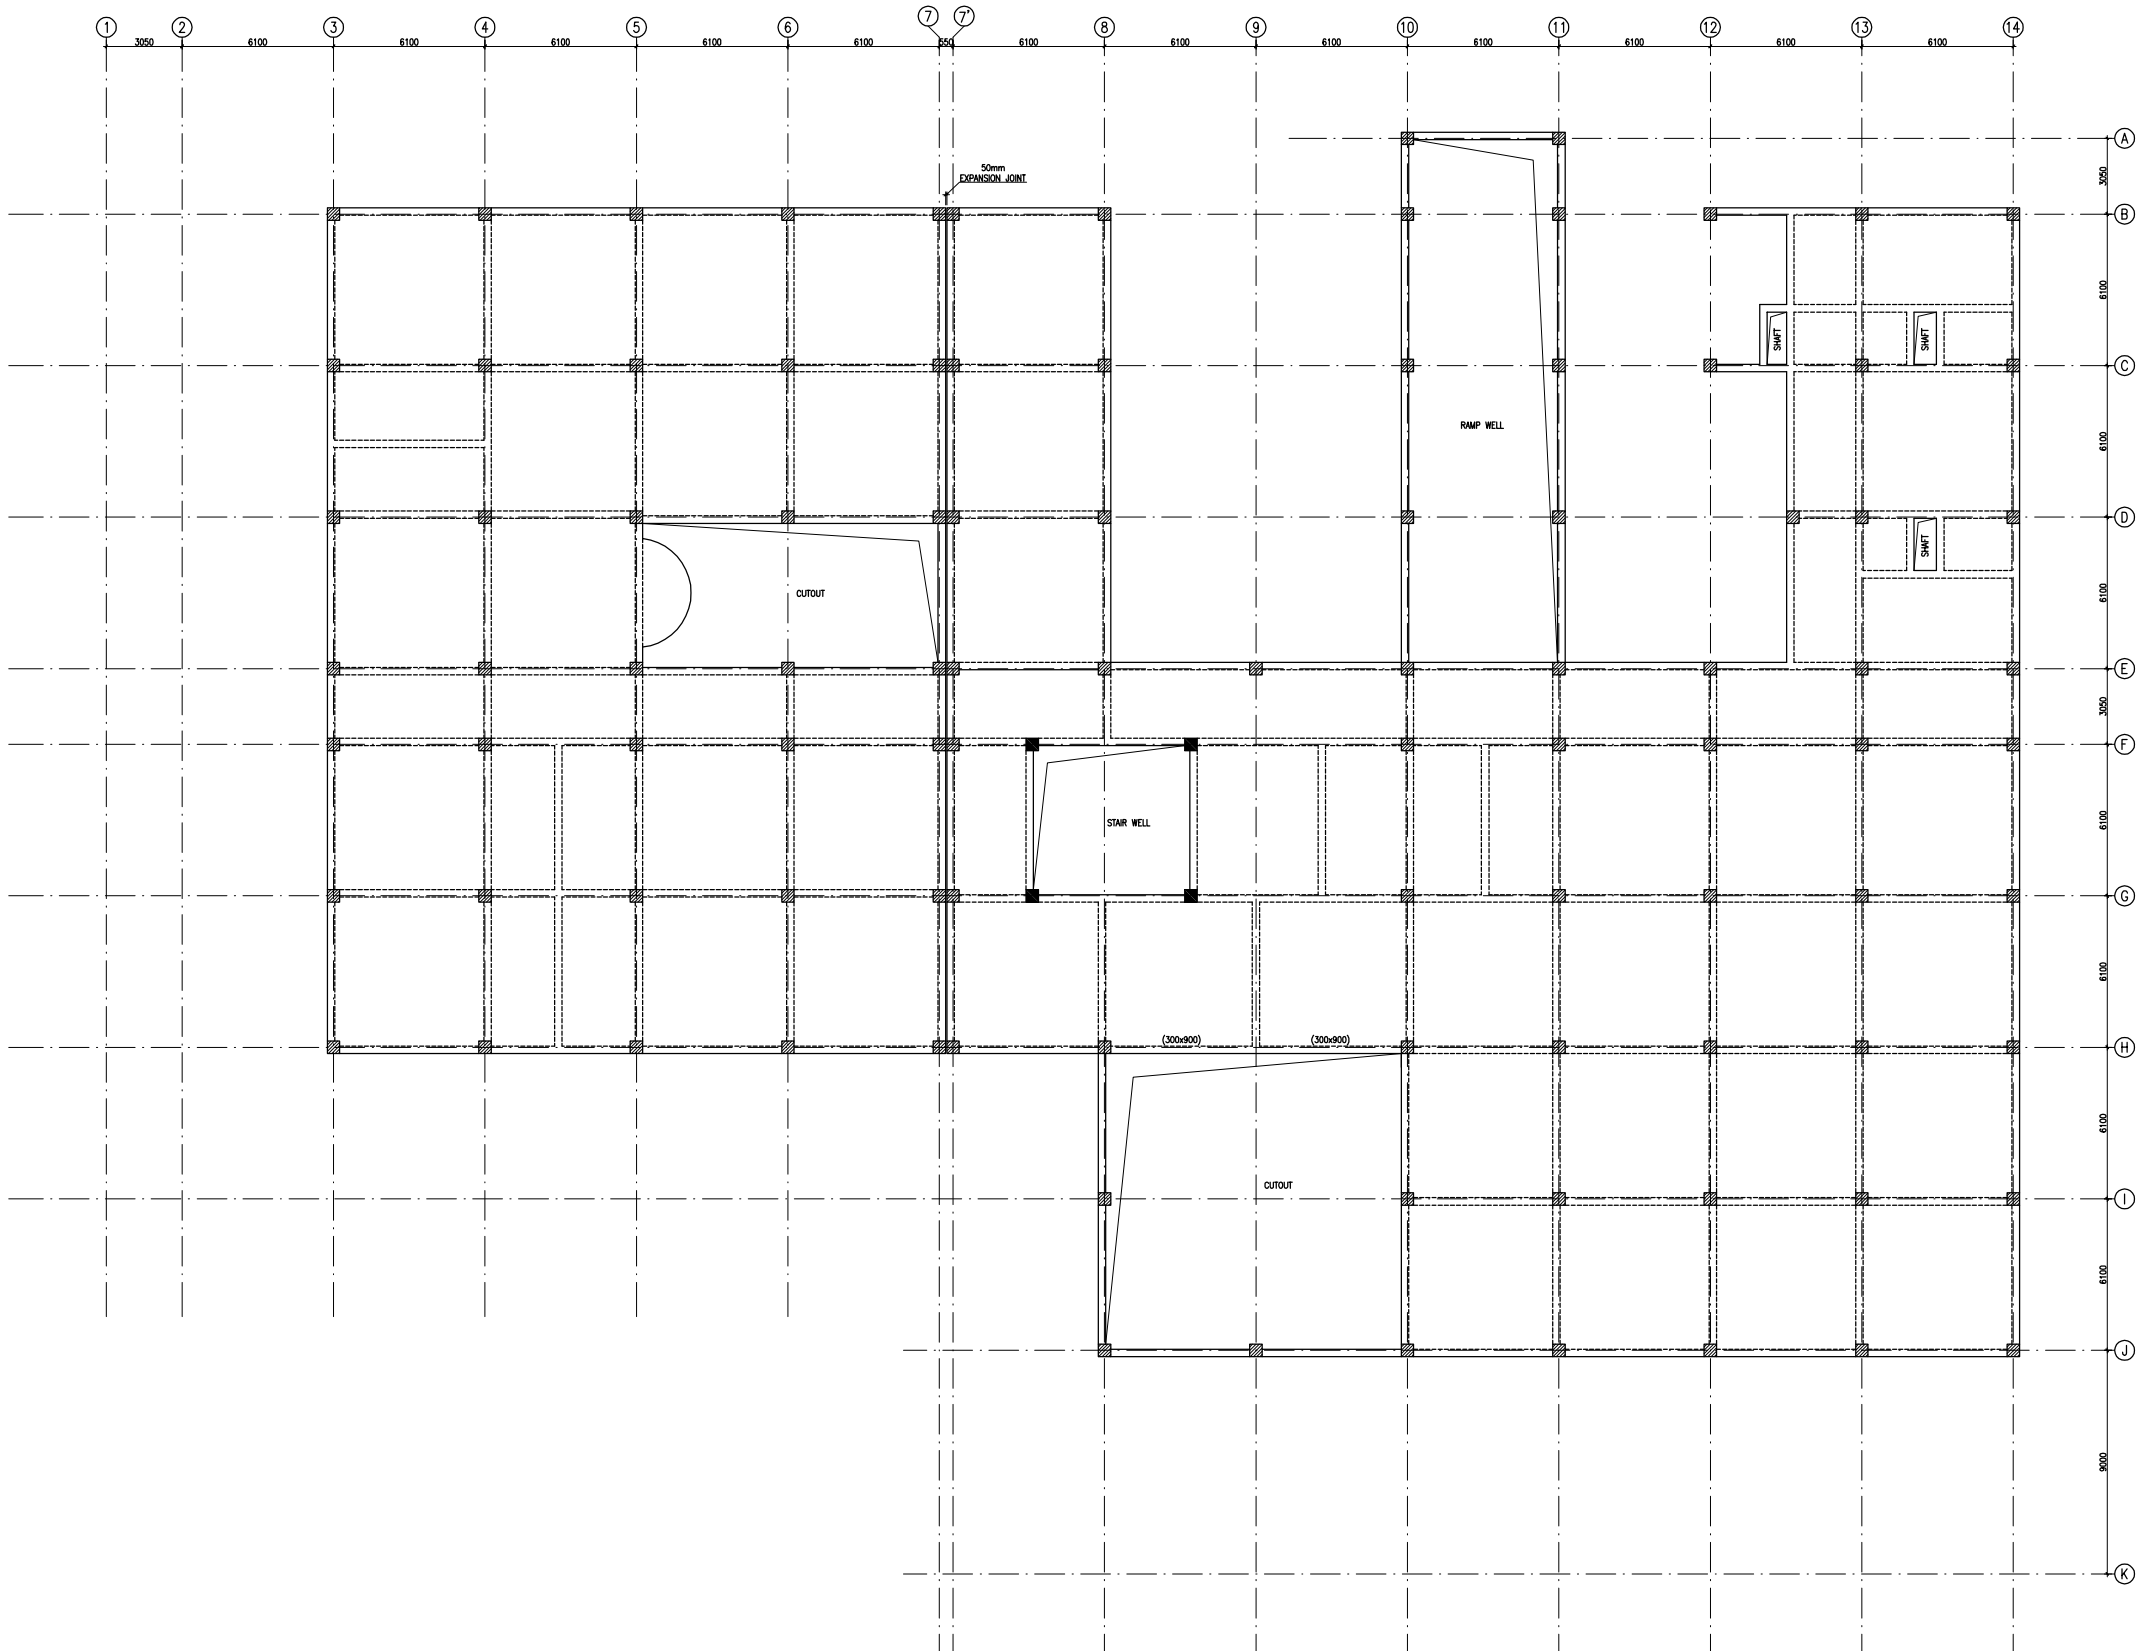

TERRACE LVL. BEAM FRAMING PLAN
(ALL BEAMS SIZE 300x600 U.N.O.) & (SLAB THICKNESS 160mm U.N.O.)

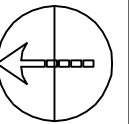

This drawing with all its contents is the sole intellectual property of the Hospital Services Consultancy Corporation (India) Ltd. Copying of this drawing or part thereof for its use in any form whatsoever without the written permission of HSCC is prohibited.

NOTES

1. DRAWINGS TO BE READ NOT MEASURED
2. PARTITION WALL IN TOILETS UP TO LINTEL HEIGHT

LEGEND:

1	100 Ø CI SOIL & VENT PIPE
2	100Ø CL.WASTE & VENT PIPE
3	100Ø CI. SOIL PIPE
4	100Ø CI. WASTE PIPE
5	50Ø GI/CPVC SOIL PIPE
6	40Ø GI/CPVC WASTE PIPE for lab, Urinal
7	32Ø GI/CPVC WASTE PIPE For W.B.
8	Ø CPVC UTW DN.TAKE
9	Ø CPVC TW DN.TAKE
10	100 Ø S.W. PIPE
11	100 Ø R.W. PIPE
12	100 Ø HDPE LAB WASTE PIPE
13	50 Ø HDPE LAB WASTE PIPE
F.T	FLOOR TRAP 100x100
F.D	FLOOR DRAIN 50Ø
FCO	FLOOR CLEAN OUT
COP	CLEAN OUT PLUG
⊗	VALVE
MH	MANHOLE (900x800)mm
GT	GULLY TRAP(300x300)mm

REVISION

NO.	DESCRIPTION

PROJECT

PROPOSED
100 BEDDED HOSPITAL

RMNCH PROJECT,
CHATTISGARH

TITLE PLUMBING

TENDER DRAWING

GROUND
FLOOR PLAN

HSCC/D&E/TD/RMNCH/PL-01


Drawing No. Rev.

Job No. 1:300 Scale 05-04-2013 Date

R.TYAGI App by R.SUR Rev. by S.BHATT Prep. by

HSCC (INDIA) LIMITED
(A GOVERNMENT OF INDIA ENTERPRISES)


HSCC
NEW DELHI INDIA

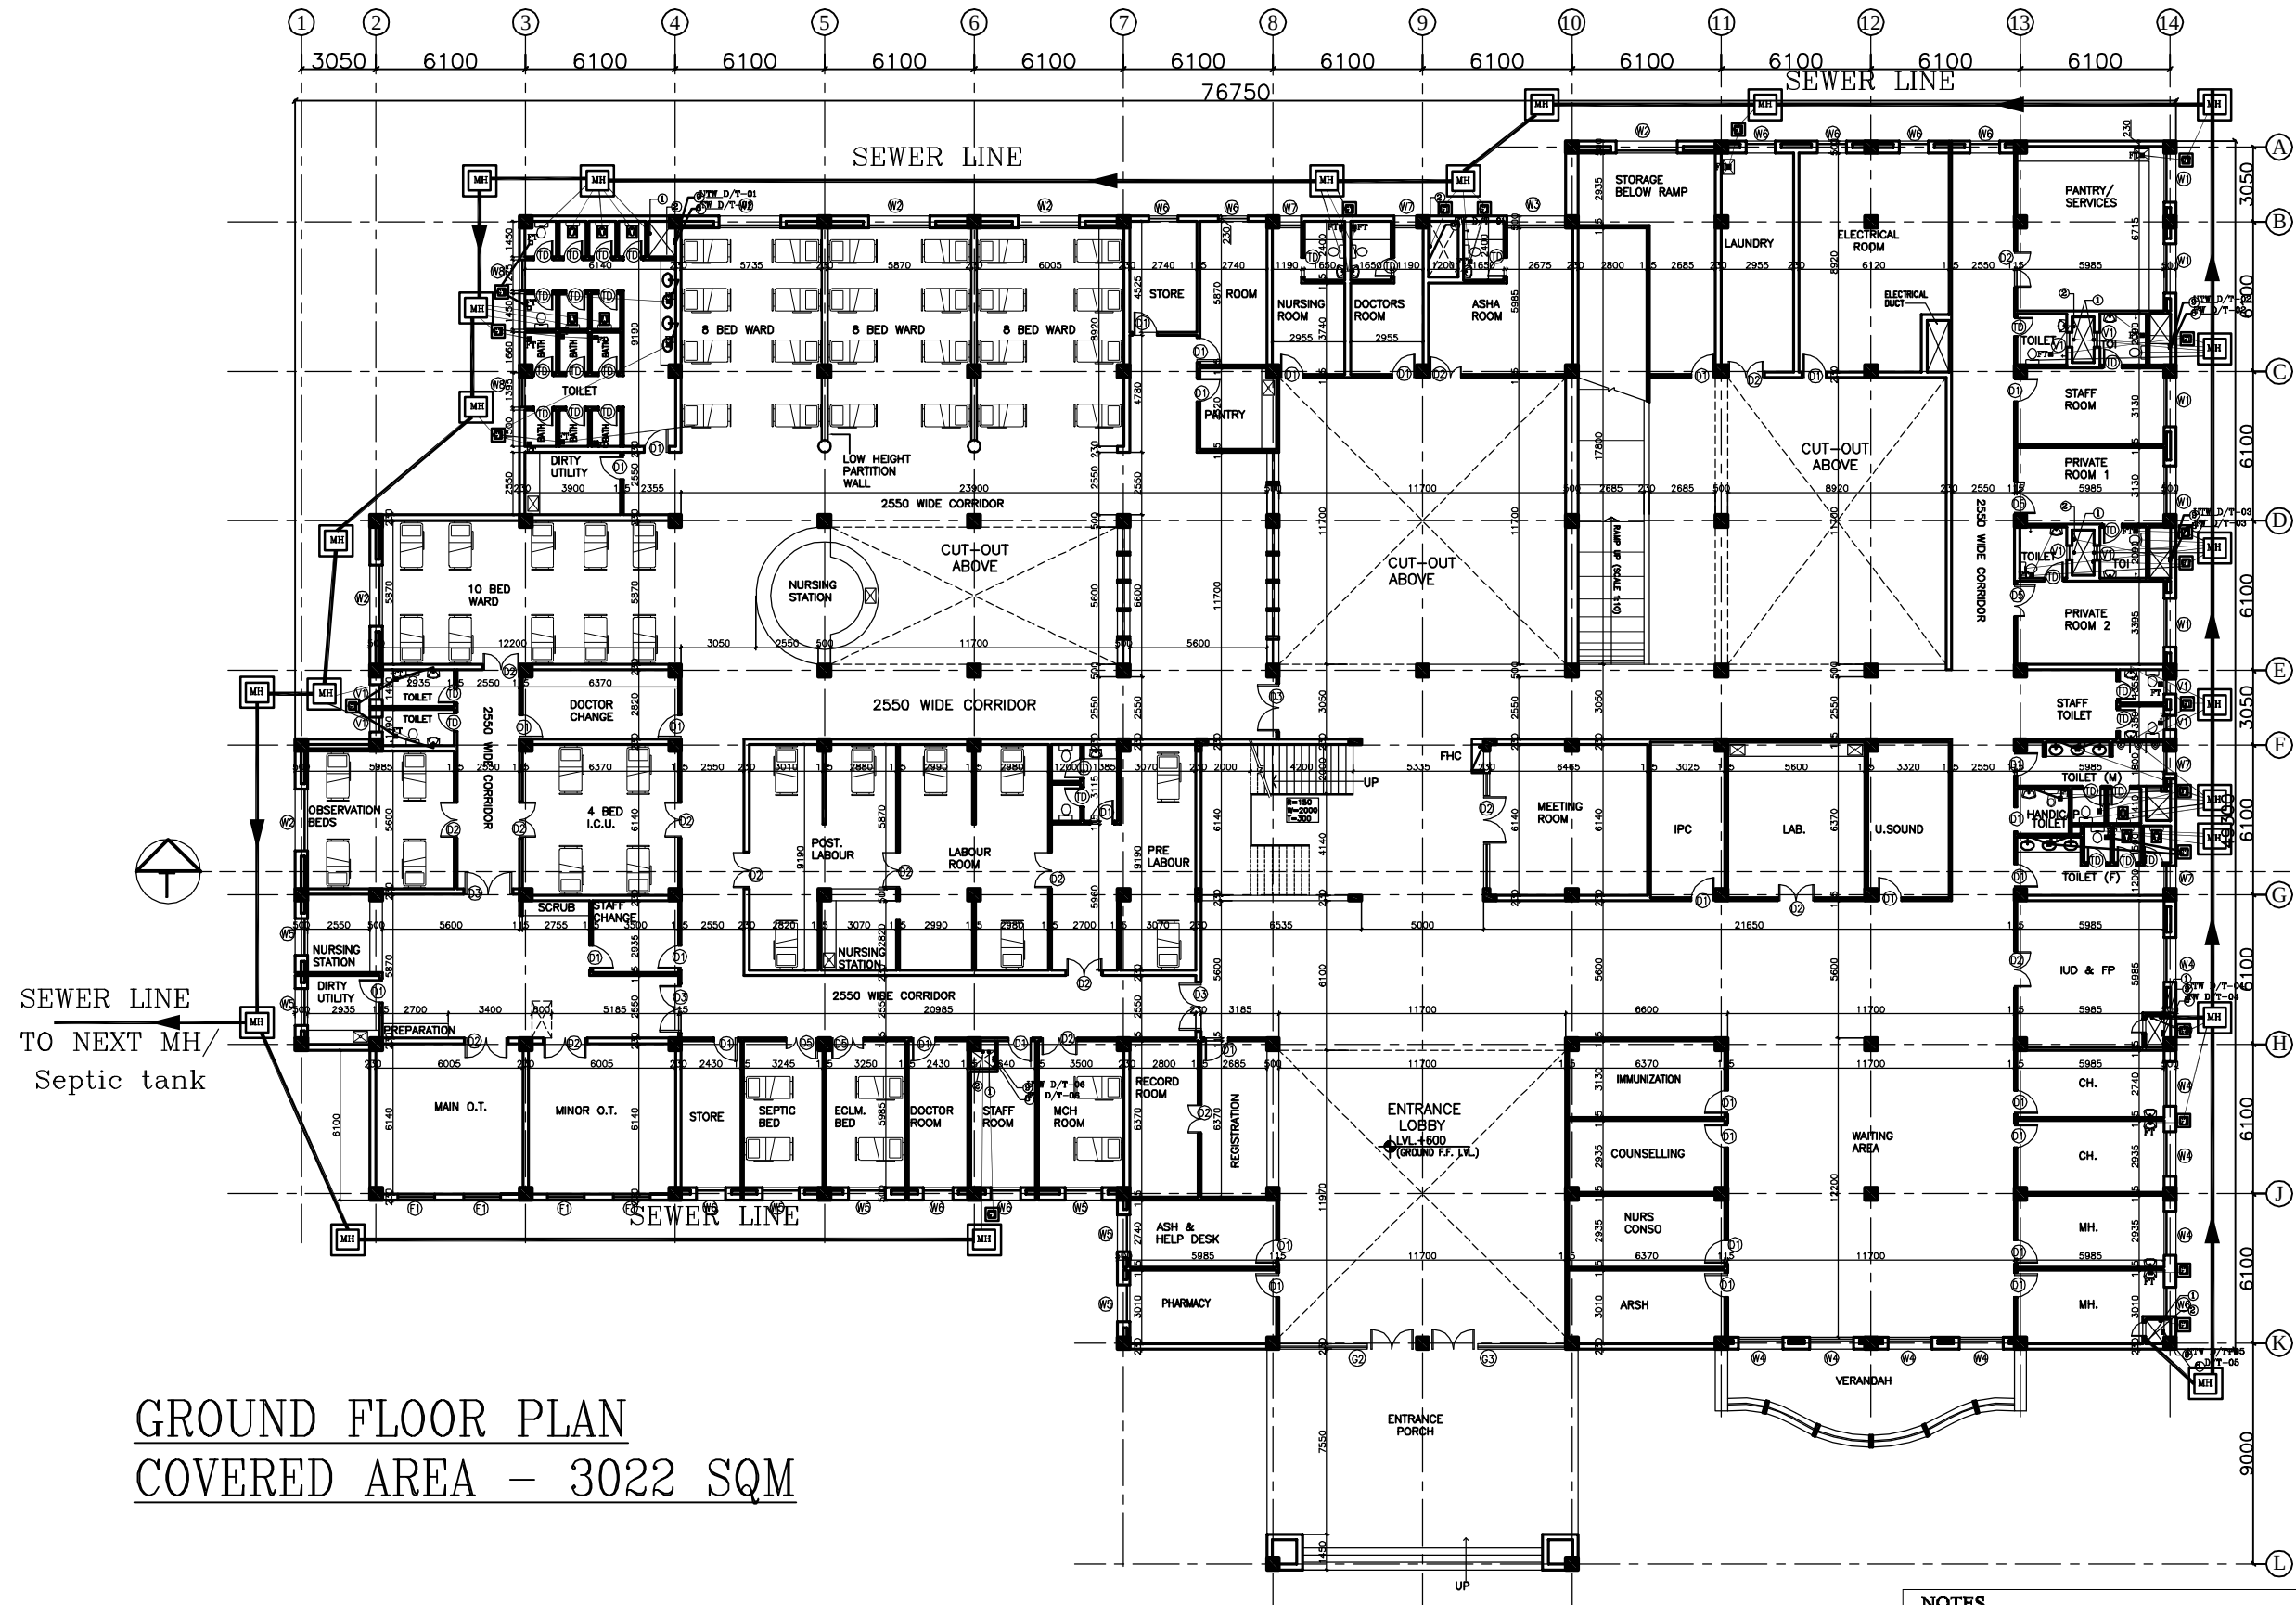

GROUND FLOOR PLAN
COVERED AREA - 3022 SQM

NOTES

1. BASED ON THIS DRAWING EXECUTING AGENCY WILL PREPARE SHOP DRAWING AFTER INCORPORATING THE CHANGES AS PER SITE CONDITION FOR THE APPROVAL OF HSCC BEFORE START OF WORK.
2. THE NUMBER & LOCATION OF FIXTURES & WET POINT TO BE FINALIZED BEFORE EXECUTION WITH CLINT OFFICER,S INCHARGE..

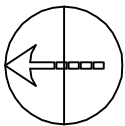

This drawing with all its contents is the sole intellectual property of the Hospital Services Consultancy Corporation (India) Ltd. Copying of this drawing or part thereof or its use in any form whatsoever without the written permission of HSCC is prohibited.

NOTES

1. DRAWINGS TO BE READ NOT MEASURED
2. PARTITION WALL IN TOILETS UP TO LINTEL HEIGHT

LEGEND:

1	100 Ø CI SOIL & VENT PIPE
2	100Ø CI.WASTE & VENT PIPE
3	100Ø CI. SOIL PIPE
4	100Ø CI. WASTE PIPE
5	50Ø GI/ CPVC SOIL PIPE
6	40Ø GI/ CPVC WASTE PIPE for Sink,Urine
7	32Ø GI /CPVC WASTE PIPE For W.B.
8	Ø CPVC UTW DN.TAKE
9	Ø CPVC TW DN.TAKE
10	100 Ø S.W. PIPE
11	100 Ø R.W. PIPE
12	100 Ø HDPE.LAB WASTE PIPE
13	50 Ø HDPE.LAB WASTE PIPE
F.T	FLOOR TRAP 100x100
F.D	FLOOR DRAIN 50Ø
FCO	FLOOR CLEAN OUT
COP	CLEAN OUT PLUG
VALVE	VALVE
MH	MANHOLE (900x800)mm
GT	GULLY TRAP(300X300)mm

REVISION	DESCRIPTION

PROJECT

PROPOSED
100 BEDDED HOSPITAL

RMNCH PROJECT,
CHATTISGARH

TITLE PLUMBING

TENDER DRAWING

FIRST
FLOOR PLAN


HSCC/D&E/TD/RMNCH/PL-02

Drawing No. Rev

Job No. 1:300 Scale 05-04-2013 Date

R.TYAGI App by R.SUR Rev. by S.BHATT Prep. by


HSCC (INDIA) LIMITED
(A GOVERNMENT OF INDIA ENTERPRISES)
HSCC
NEW DELHI INDIA

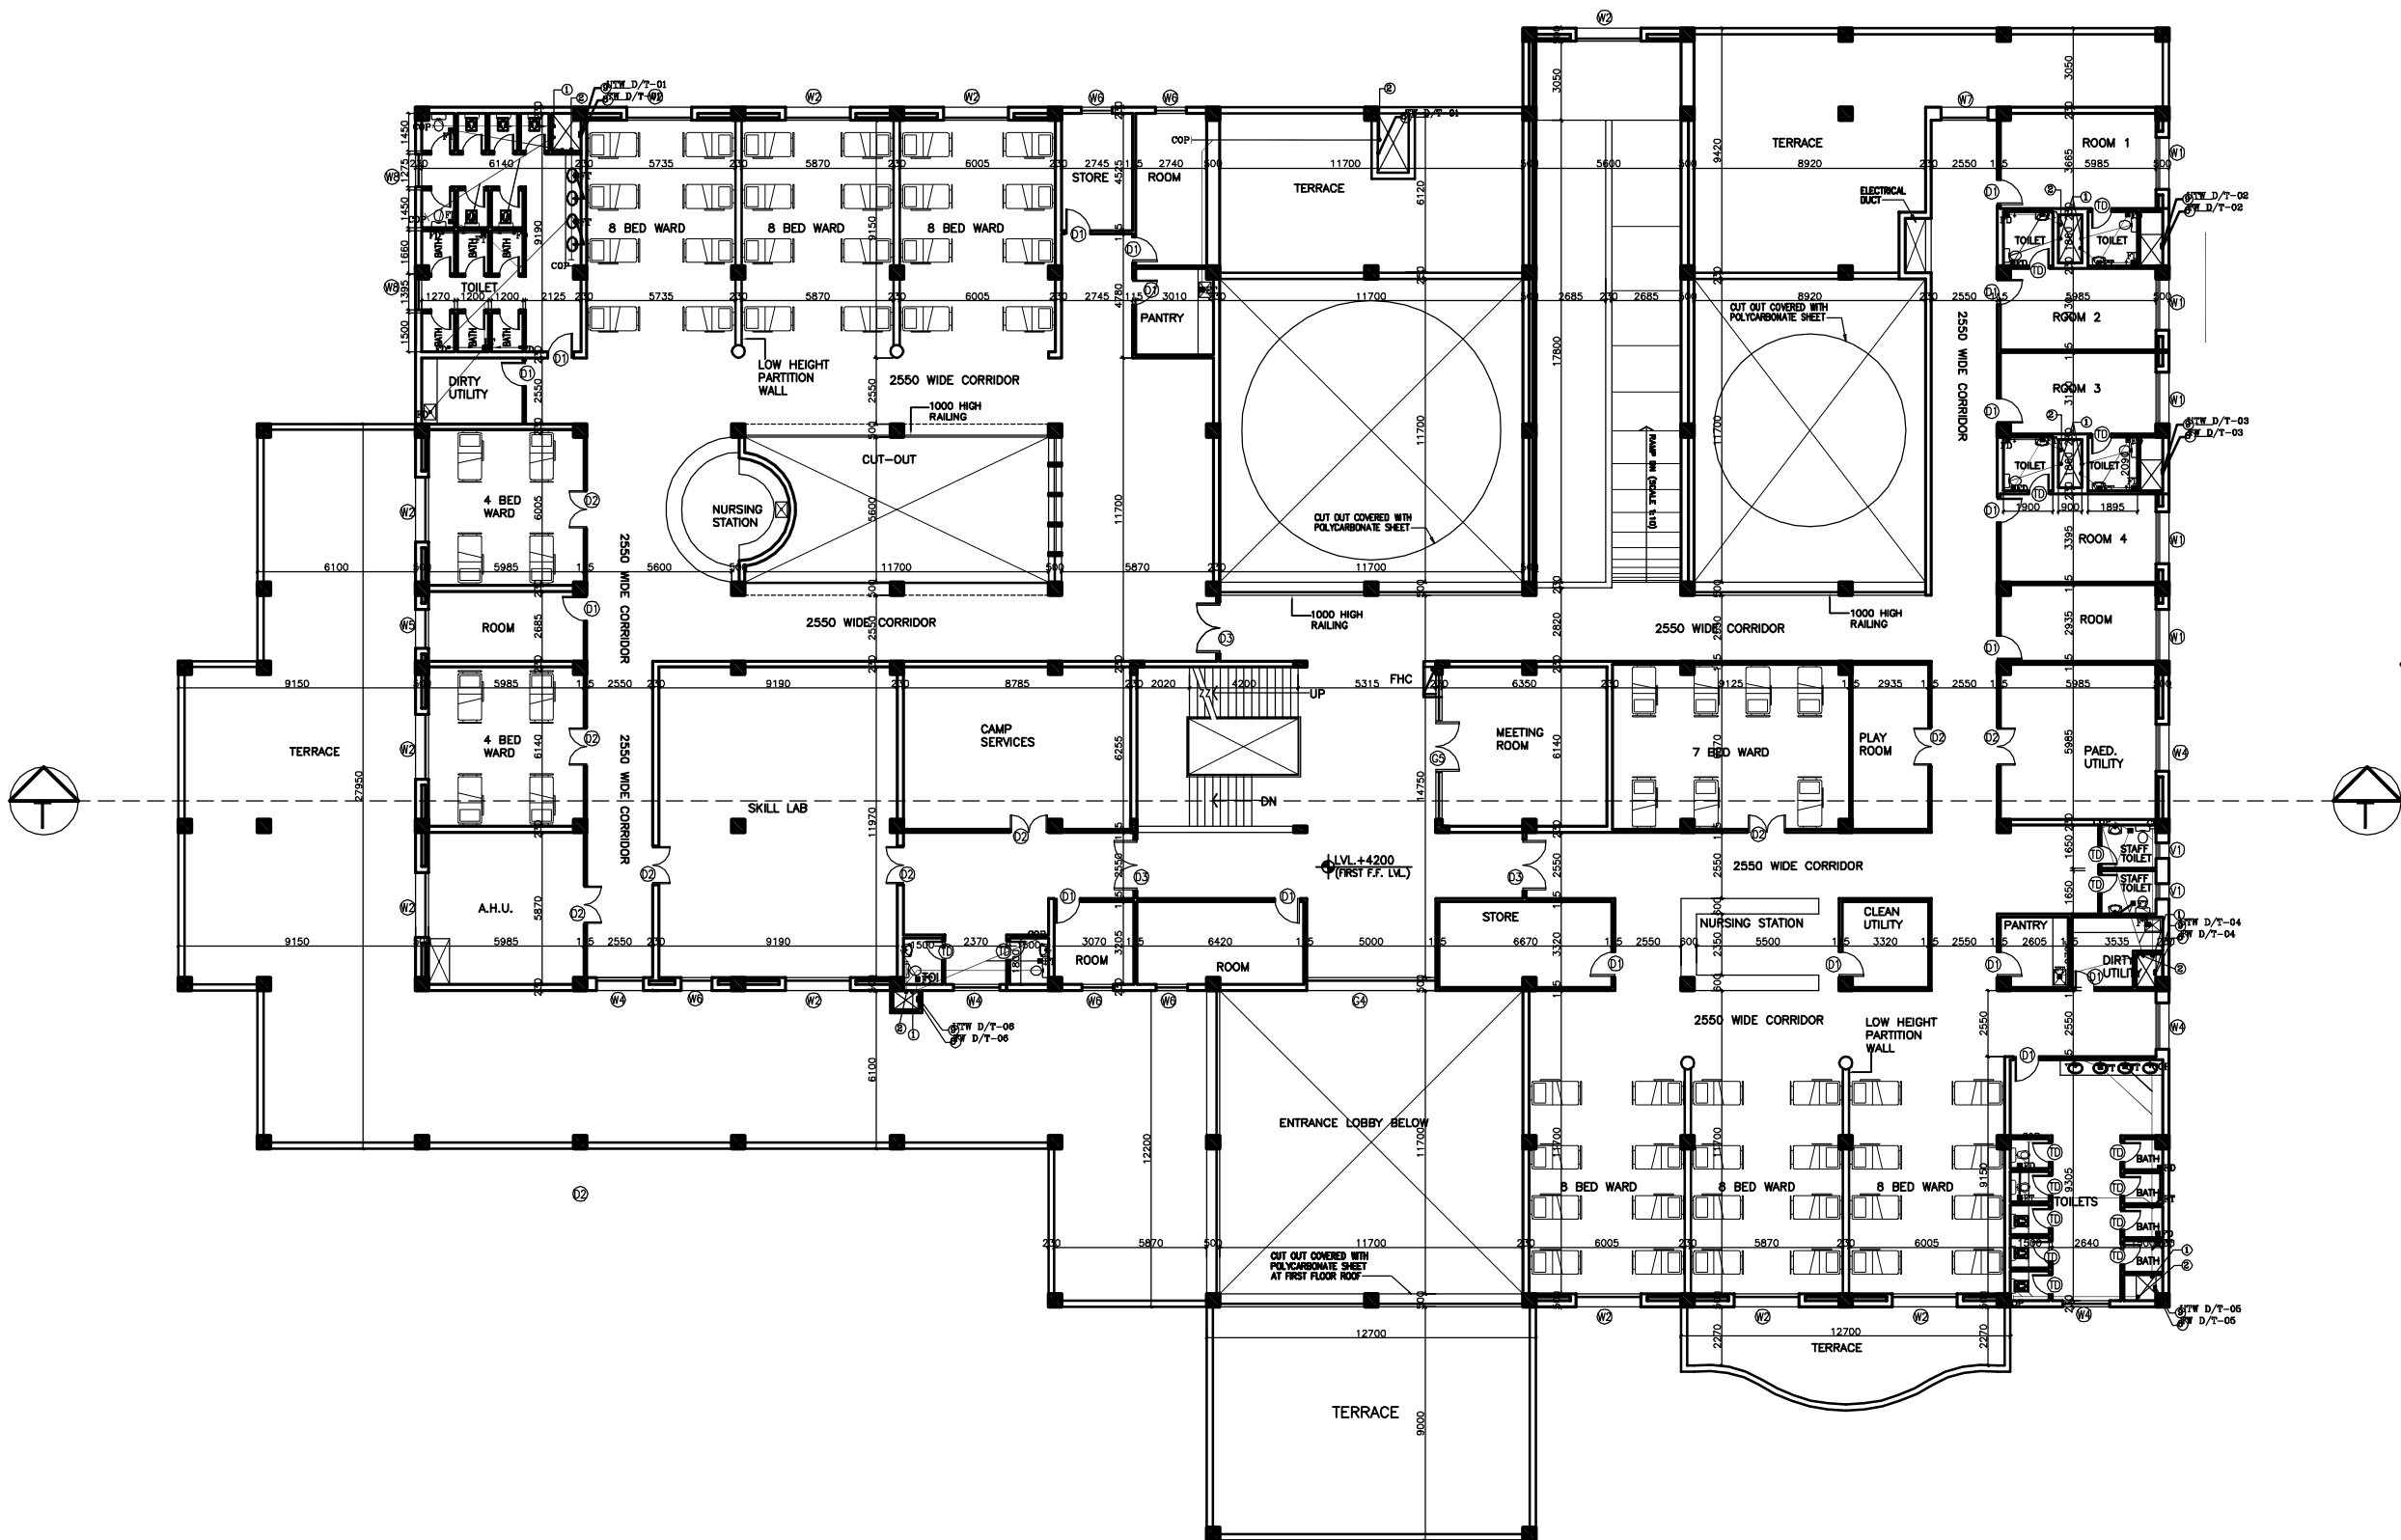

FIRST FLOOR PLAN
COVERED AREA – 2050 SQM

NOTES

1. BASED ON THIS DRAWING EXECUTING AGENCY WILL PREPARE SHOP DRAWING AFTER INCORPORATING THE CHANGES AS PER SITE CONDITION FOR THE APPROVAL OF HSCC BEFORE START OF WORK.
2. THE NUMBER & LOCATION OF FIXTURES & WET POINT TO BE FINALIZED BEFORE EXECUTION WITH CLINT OFFICER,S INCHARGE..

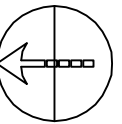

This drawing with all its contents is the sole intellectual property of the Hospital Services Consultancy Corporation (India) Ltd. Copying of this drawing or part thereof for its use in any form whatsoever without the written permission of HSCC is prohibited.

NOTES

- DRAWINGS TO BE READ NOT MEASURED
- PARTITION WALL IN TOILETS UP TO LINTEL HEIGHT

LEGEND:

1	100 Ø CI SOIL & VENT PIPE
2	100Ø CL.WASTE & VENT PIPE
3	100Ø CI. SOIL PIPE
4	100Ø CI. WASTE PIPE
5	50Ø GI/ CPVC SOIL PIPE
6	40Ø GI/ CPVC WASTE PIPE for Urinal, Lab, sink
7	32Ø GI/CPVC WASTE PIPE For W.B.
8	Ø CPVC UTW DN.TAKE
9	Ø CPVC TW DN.TAKE
10	100 Ø S.W. PIPE
11	100 Ø R.W. PIPE
12	100 Ø HDPE.LAB WASTE PIPE
13	50 Ø HDPE.LAB WASTE PIPE
F.T	FLOOR TRAP 100x100
F.D	FLOOR DRAIN 50Ø
F.CO	FLOOR CLEAN OUT
COP	CLEAN OUT PLUG
⊗	VALVE
MH	MANHOLE (900x800)mm
GT	GULLY TRAP(300X300)mm

REVISION	DESCRIPTION

PROJECT

PROPOSED
100 BEDDED HOSPITAL

**RMNCH PROJECT,
CHATTISGARH**

TITLE PLUMBING

TENDER DRAWING

TERRACE
FLOOR PLAN


HSCC/D&E/TD/RMNCH/PL-03

Drawing No. Rev.

Job No. 1:300 Scale 05-04-2013 Date

R.TYAGI App by R.SUR Rev. by S.BHATT Prep. by

HSCC (INDIA) LIMITED
(A GOVERNMENT OF INDIA ENTERPRISES)
HSCC
NEW DELHI INDIA

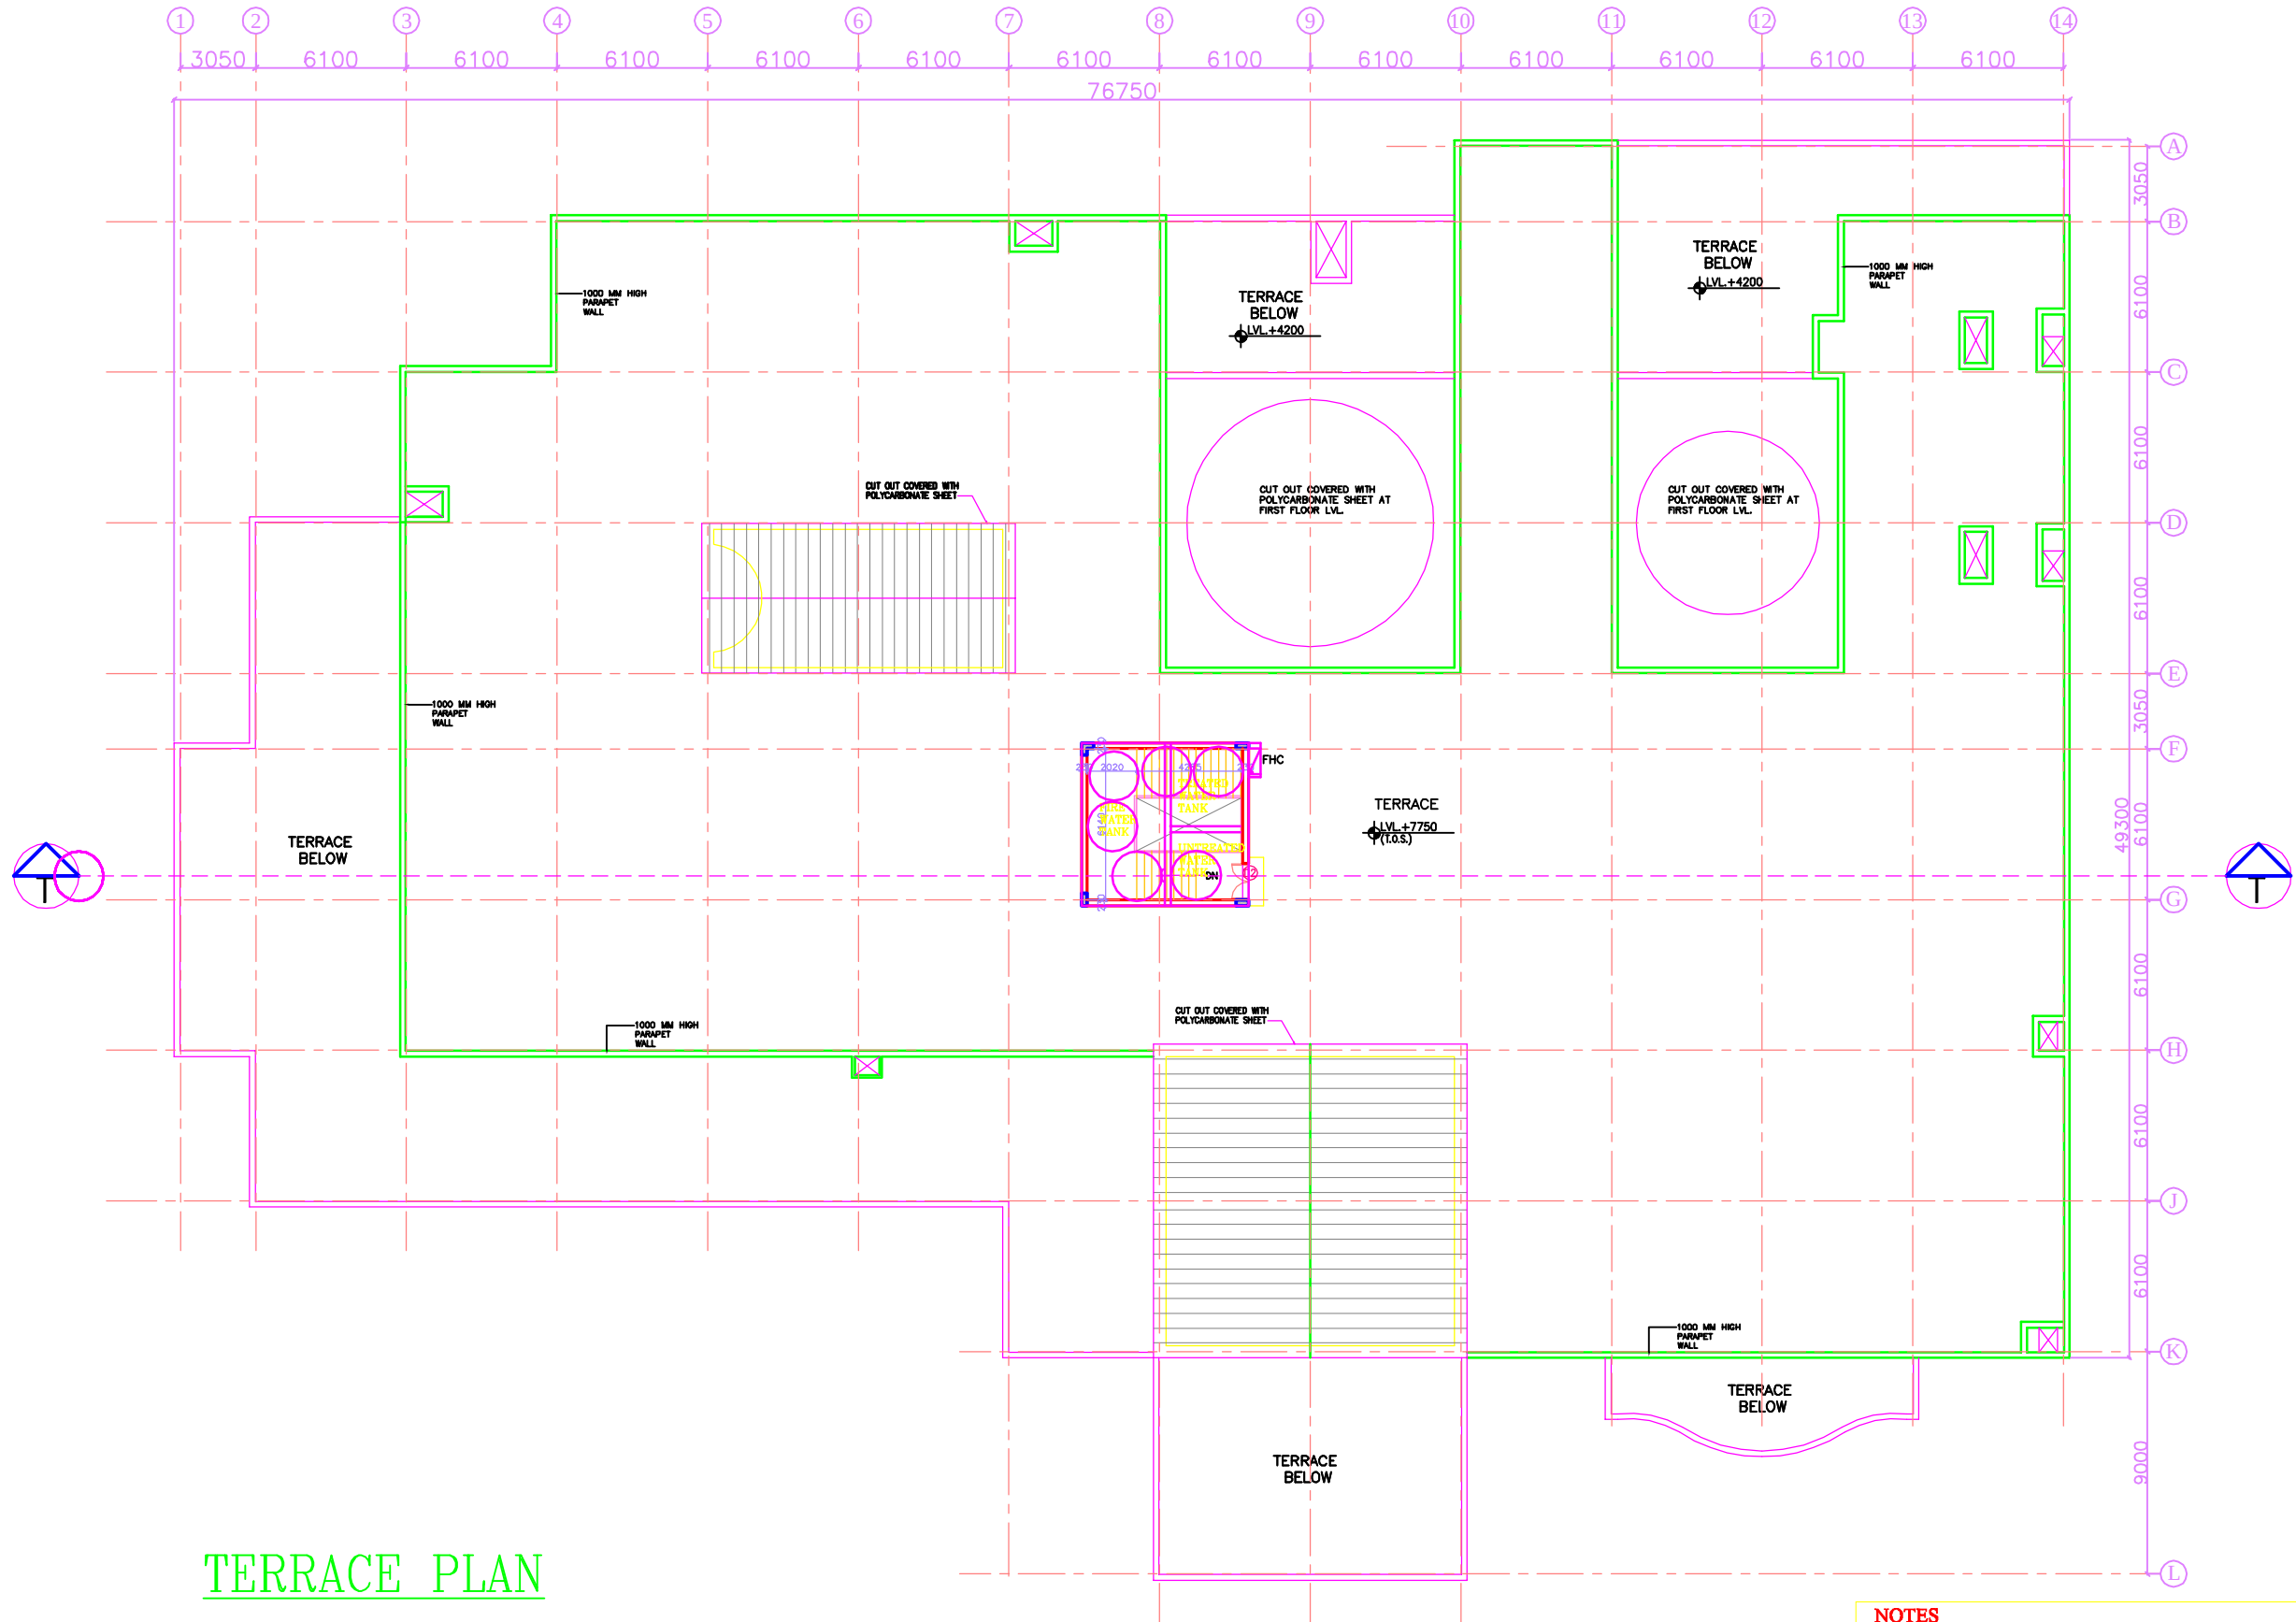

TERRACE PLAN

NOTES

- BASED ON THIS DRAWING EXECUTING AGENCY WILL PREPARE SHOP DRAWING AFTER INCORPORATING THE CHANGES AS PER SITE CONDITION FOR THE APPROVAL OF HSCC BEFORE START OF WORK.
- THE NUMBER & LOCATION OF FIXTURES & WET POINT TO BE FINALIZED BEFORE EXECUTION WITH CLINT OFFICER,S INCHARGE..

NOTES

REV	DATE	DESCRIPTION
-----	------	-------------

REVISION

PROJECT

RMNCH PROJECT
Proposed
100 Bedded Hospital
AT
CHATTISGARH

TITLE

MODEL PLANS

GROUND

FLOOR PLAN

ELECTRICAL LAYOUT

(COVERED AREA=3022 SQ. MT.)

HSCC/D&E/TD/EL-101
Drawing No.

R-0
Rev.

HSCC/-
Job No.


NTS
Scale

Date

App by

Rev. by

Prep. by

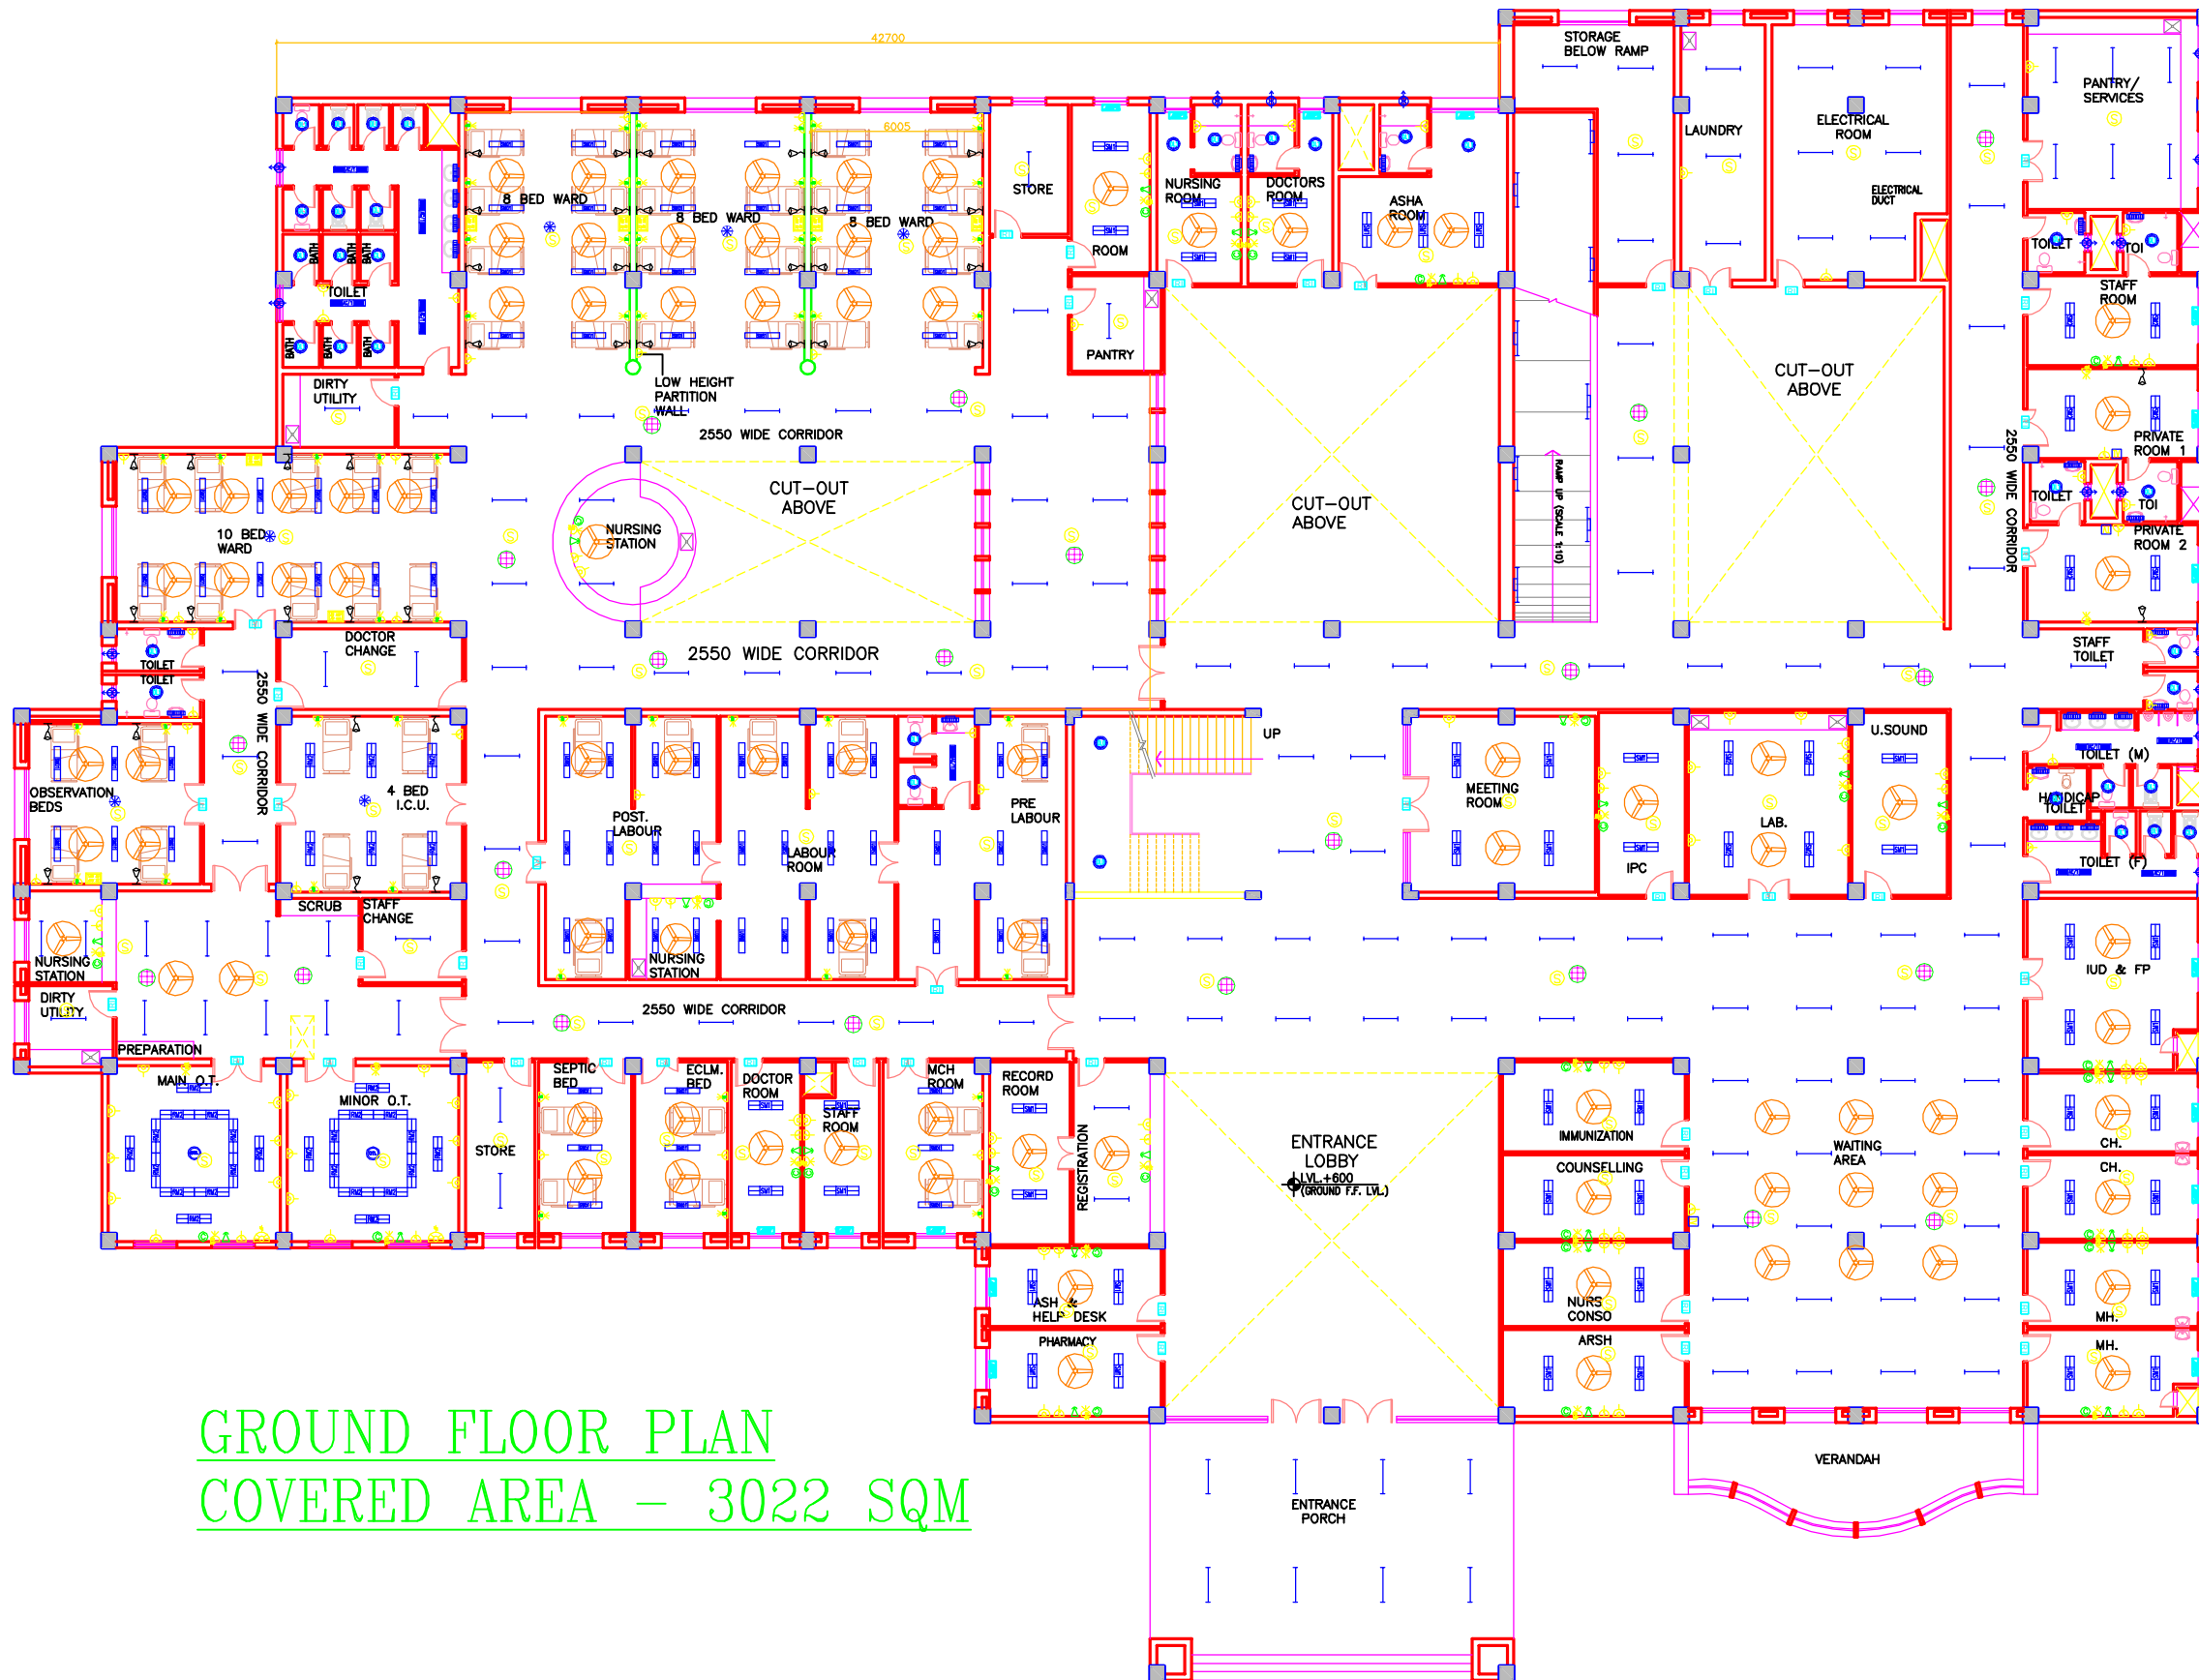

GROUND FLOOR PLAN
COVERED AREA - 3022 SQM

NOTES

PROJECT
RMNCH PROJECT
Proposed
100 Bedded Hospital
AT
CHATTISGARH

pp by Rev. by Prep. by

This drawing with all its contents is the sole intellectual property of the Hospital Services Consultancy Corporation (India) Ltd. Copying of this drawing or part thereof or its use in any form whatsoever without the written permission of HSCC is prohibited.

NOTES

REV	DATE	DESCRIPTION
REVISION		

PROJECT

RMNCH PROJECT
Proposed
100 Bedded Hospital
AT
CHATTISGARH


TITLE

MODEL PLANS

TERRACE
PLAN

ELECTRICAL LAYOUT

HSCC/D&E/TD/EL-103 Drawing No.		R-0 Rev.
HSCC/- Job No.	NTS Scale	Date
App by	Rev. by	Prep. by

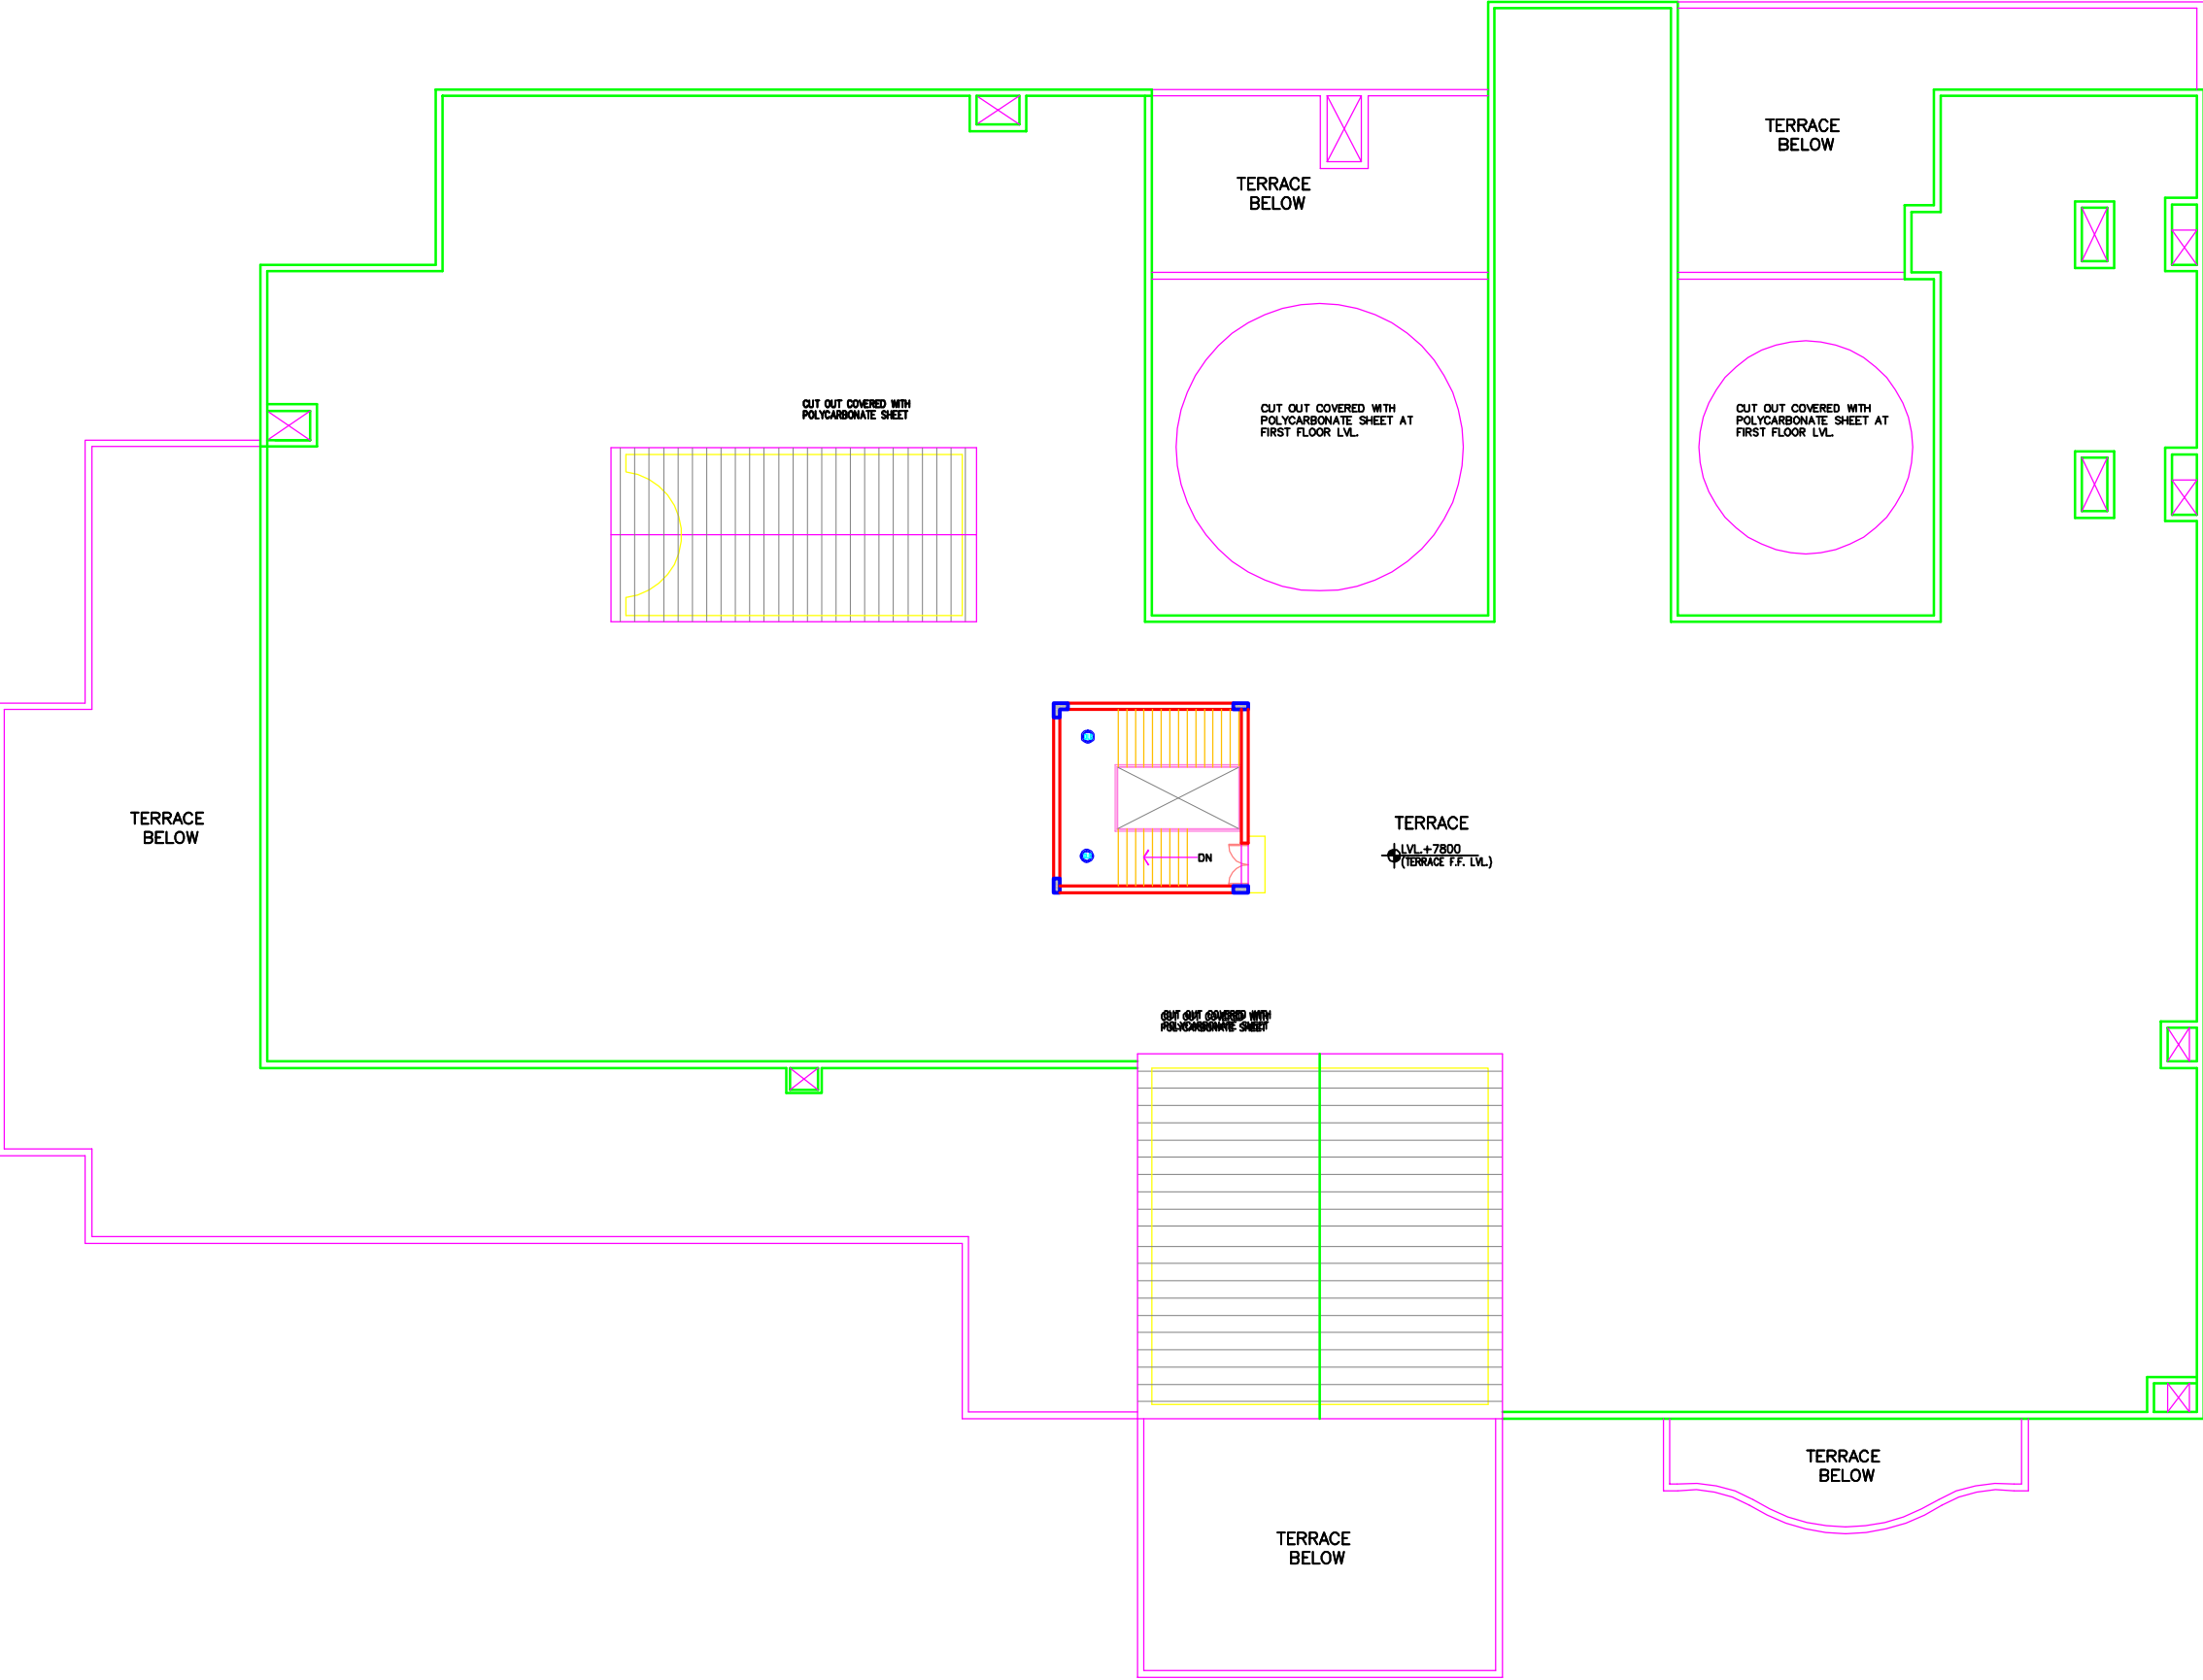



This drawing with all its contents is the sole intellectual property of the Hospital Services Consultancy Corporation (India) Ltd. Copying of this drawing or part thereof for use in any form whatsoever without the written permission of HSCC is prohibited.

NOTES

REV	DATE	DESCRIPTION

PROJECT

Proposed
100 Bedded Hospital
At CHHATTISGARH

TITLE


TENDER DRAWING
GROUND FLOOR PLAN
HVAC LAYOUT
(COVERED AREA=3022 SQ. MT.)

HSCC/D&E/HVAC/NRHM-CG/AC-01 R-0
Drawing No. Rev.

HSCC/- 1:125 25-03-2013
Job No. Scale Date

App by Rev. by Prep. by

HSCC (INDIA) LIMITED
(A GOVERNMENT OF INDIA ENTERPRISES)
HSCC
NEW DELHI INDIA

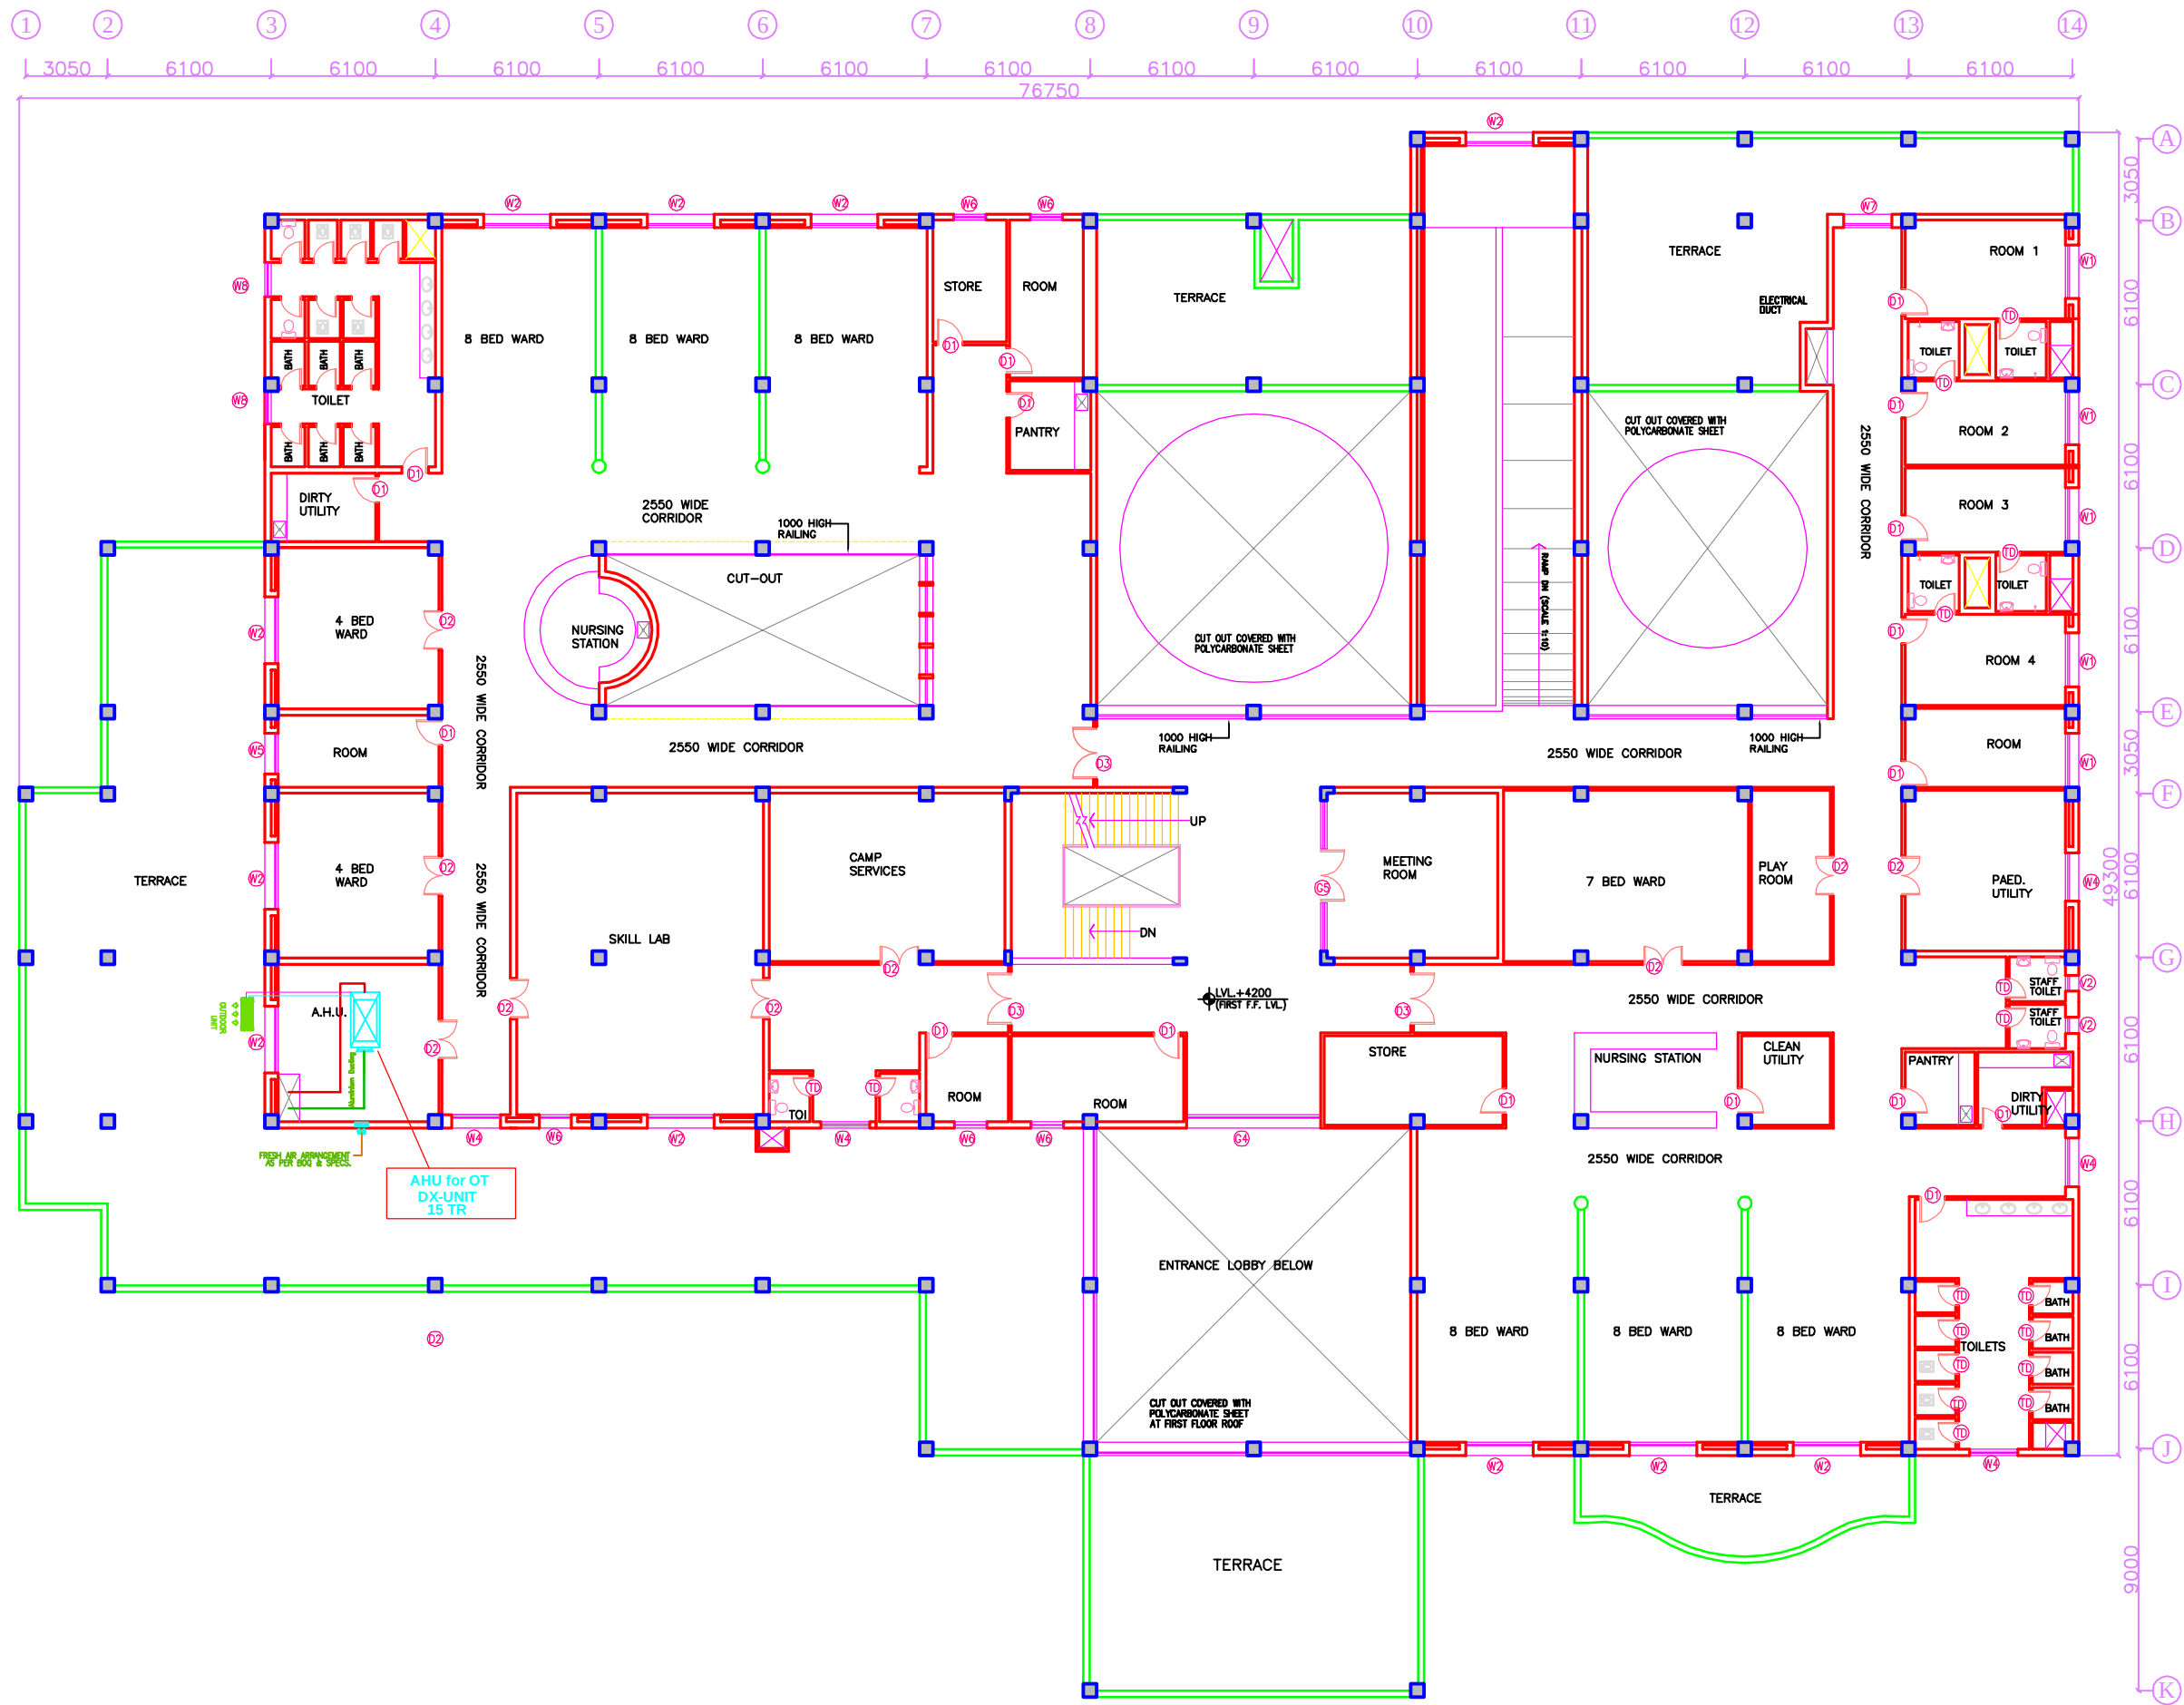

This drawing with all its contents is the sole intellectual property of the Hospital Services Consultancy Corporation (India) Ltd. Copying of this drawing or part thereof for its use in any form whatsoever without the written permission of HSCC is prohibited.

NOTES

REV	DATE	DESCRIPTION

REVISION

PROJECT

Proposed
100 Bedded Hospital
At CHHATTISGARH

TITLE

TENDER DRAWING

FIRST FLOOR PLAN
HVAC LAYOUT

(COVERED AREA=2050 SQ. MT.)

HSCC/D&E/HVAC/NRHM-CG/AC-02 R-0
Drawing No. Rev.

HSCC/- 1:125 19-03-2013
Job No. Scale Date

App by Rev. by Prep. by

HSCC (INDIA) LIMITED
(A GOVERNMENT OF INDIA ENTERPRISES)
HSCC
NEW DELHI INDIA