


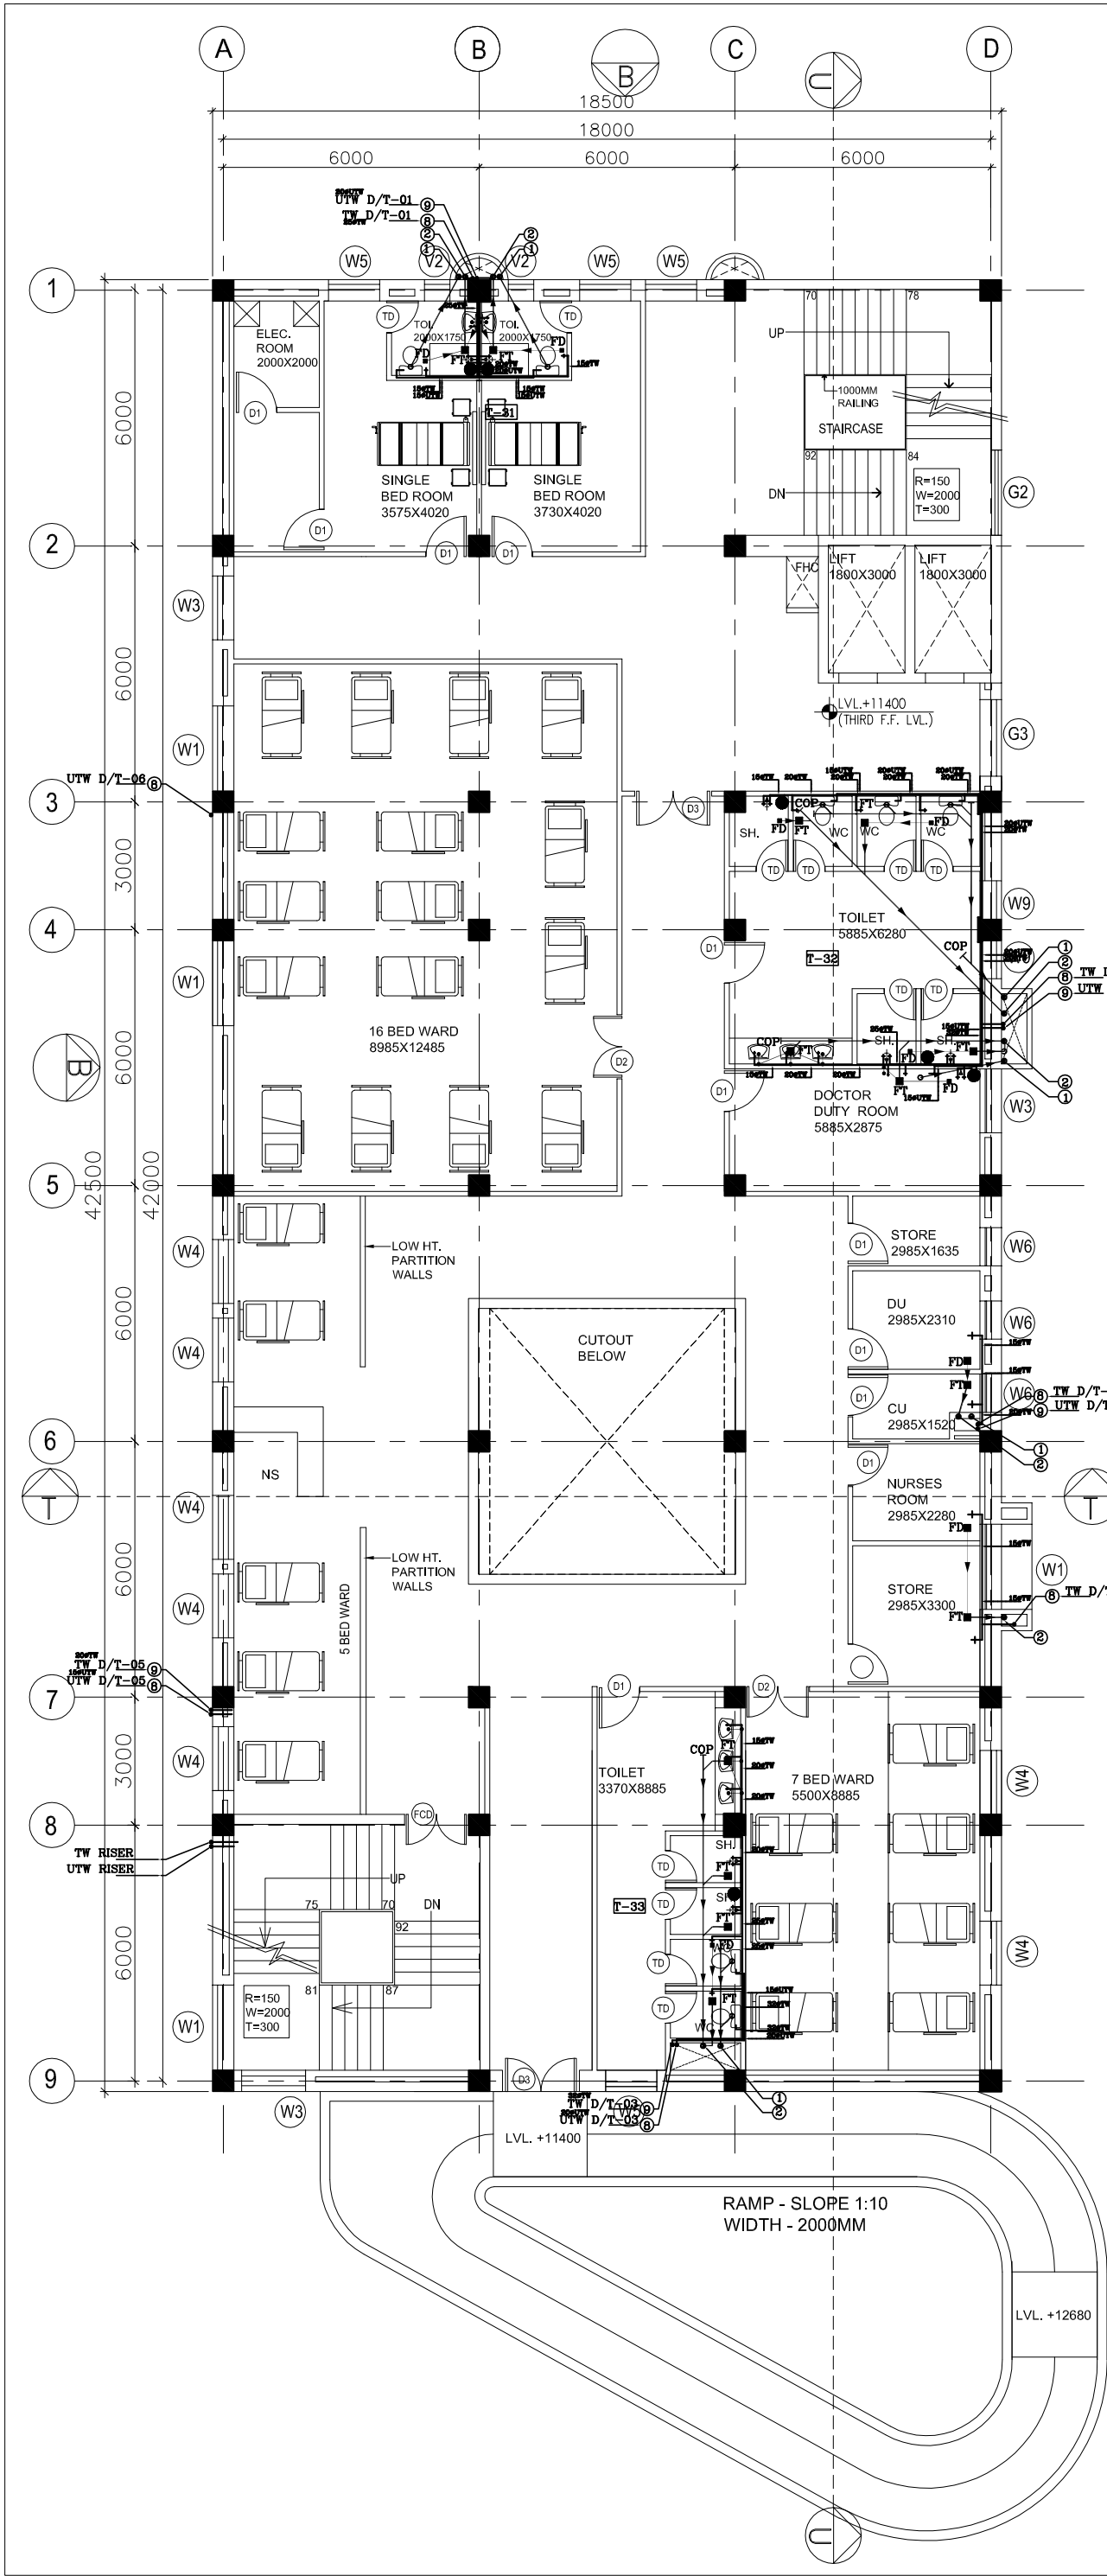

3RD FLOOR PLAN
POST NATAL – 28 BED
MATERNITY WARD +
2 SINGLE ROOMS

This drawing with all its contents is the sole intellectual property of the Hospital Services Consultancy Corporation (India) Ltd. Copying of this drawing or part thereof or its use in any form whatsoever without the written permission of HSCC is prohibited.

NOTES

1. DRAWINGS TO BE READ NOT MEASURED

2. PARTITION WALL IN TOILETS UP TO UNTEL HEIGHT

NOTES

1. BASED ON THIS DRAWING EXECUTING AGENCY WILL PREPARE SHOP DRAWING AFTER INCORPORATING THE CHANGES AS PER SITE CONDITION FOR THE APPROVAL OF HSCC BEFORE START OF WORK.

2. THE NUMBER & LOCATION OF FIXTURES & NET POINT TO BE FINALIZED BEFORE EXECUTION WITH CLINT OFFICERS INCHARGE.

LEGEND:

1	100 Ø CI SOIL & VENT PIPE
2	100Ø CI.WASTE & VENT PIPE
3	100Ø CI. SOIL PIPE
4	100Ø CI. WASTE PIPE
5	50Ø uPVC SOIL PIPE
6	40Ø UPVC WASTE PIPE
7	32Ø uPVC WASTE PIPE
8	Ø UTW DN.TAKE
9	Ø TW DN.TAKE
10	100 Ø S.W. PIPE
11	100 Ø R.W. PIPE
12	100 Ø HDPE.LAB WASTE PIPE
13	50 Ø HDPE.LAB WASTE PIPE
F.T	FLOOR TRAP 100x100
F.D	FLOOR DRAIN 50Ø
FCO	FLOOR CLEAN OUT
COP	CLEAN OUT PLUG
✕	VALVE
MH	MANHOLE (900x800)mm
GT	GULLY TRAP(300X300)mm

REVISION	
NO.	DESCRIPTION

PROJECT

PROPOSED
100 BEDDED HOSPITAL
JAUNPUR

TITLE PLUMBING

TENDER DRAWING

THIRD
FLOOR PLAN

HSCC/D&E/TD/SHAH.JAHANPUR/PL-05

Drawing No. Rev.

Job No.	1:150 Scale	MARCH-2013 Date
---------	----------------	--------------------

R.TYAGI App by	R.SUR Rev. by	S.BHATT Prep. by
-------------------	------------------	---------------------

HSCC (INDIA) LIMITED
(A GOVERNMENT OF INDIA ENTERPRISES)

HSCC

NEW DELHI INDIA