


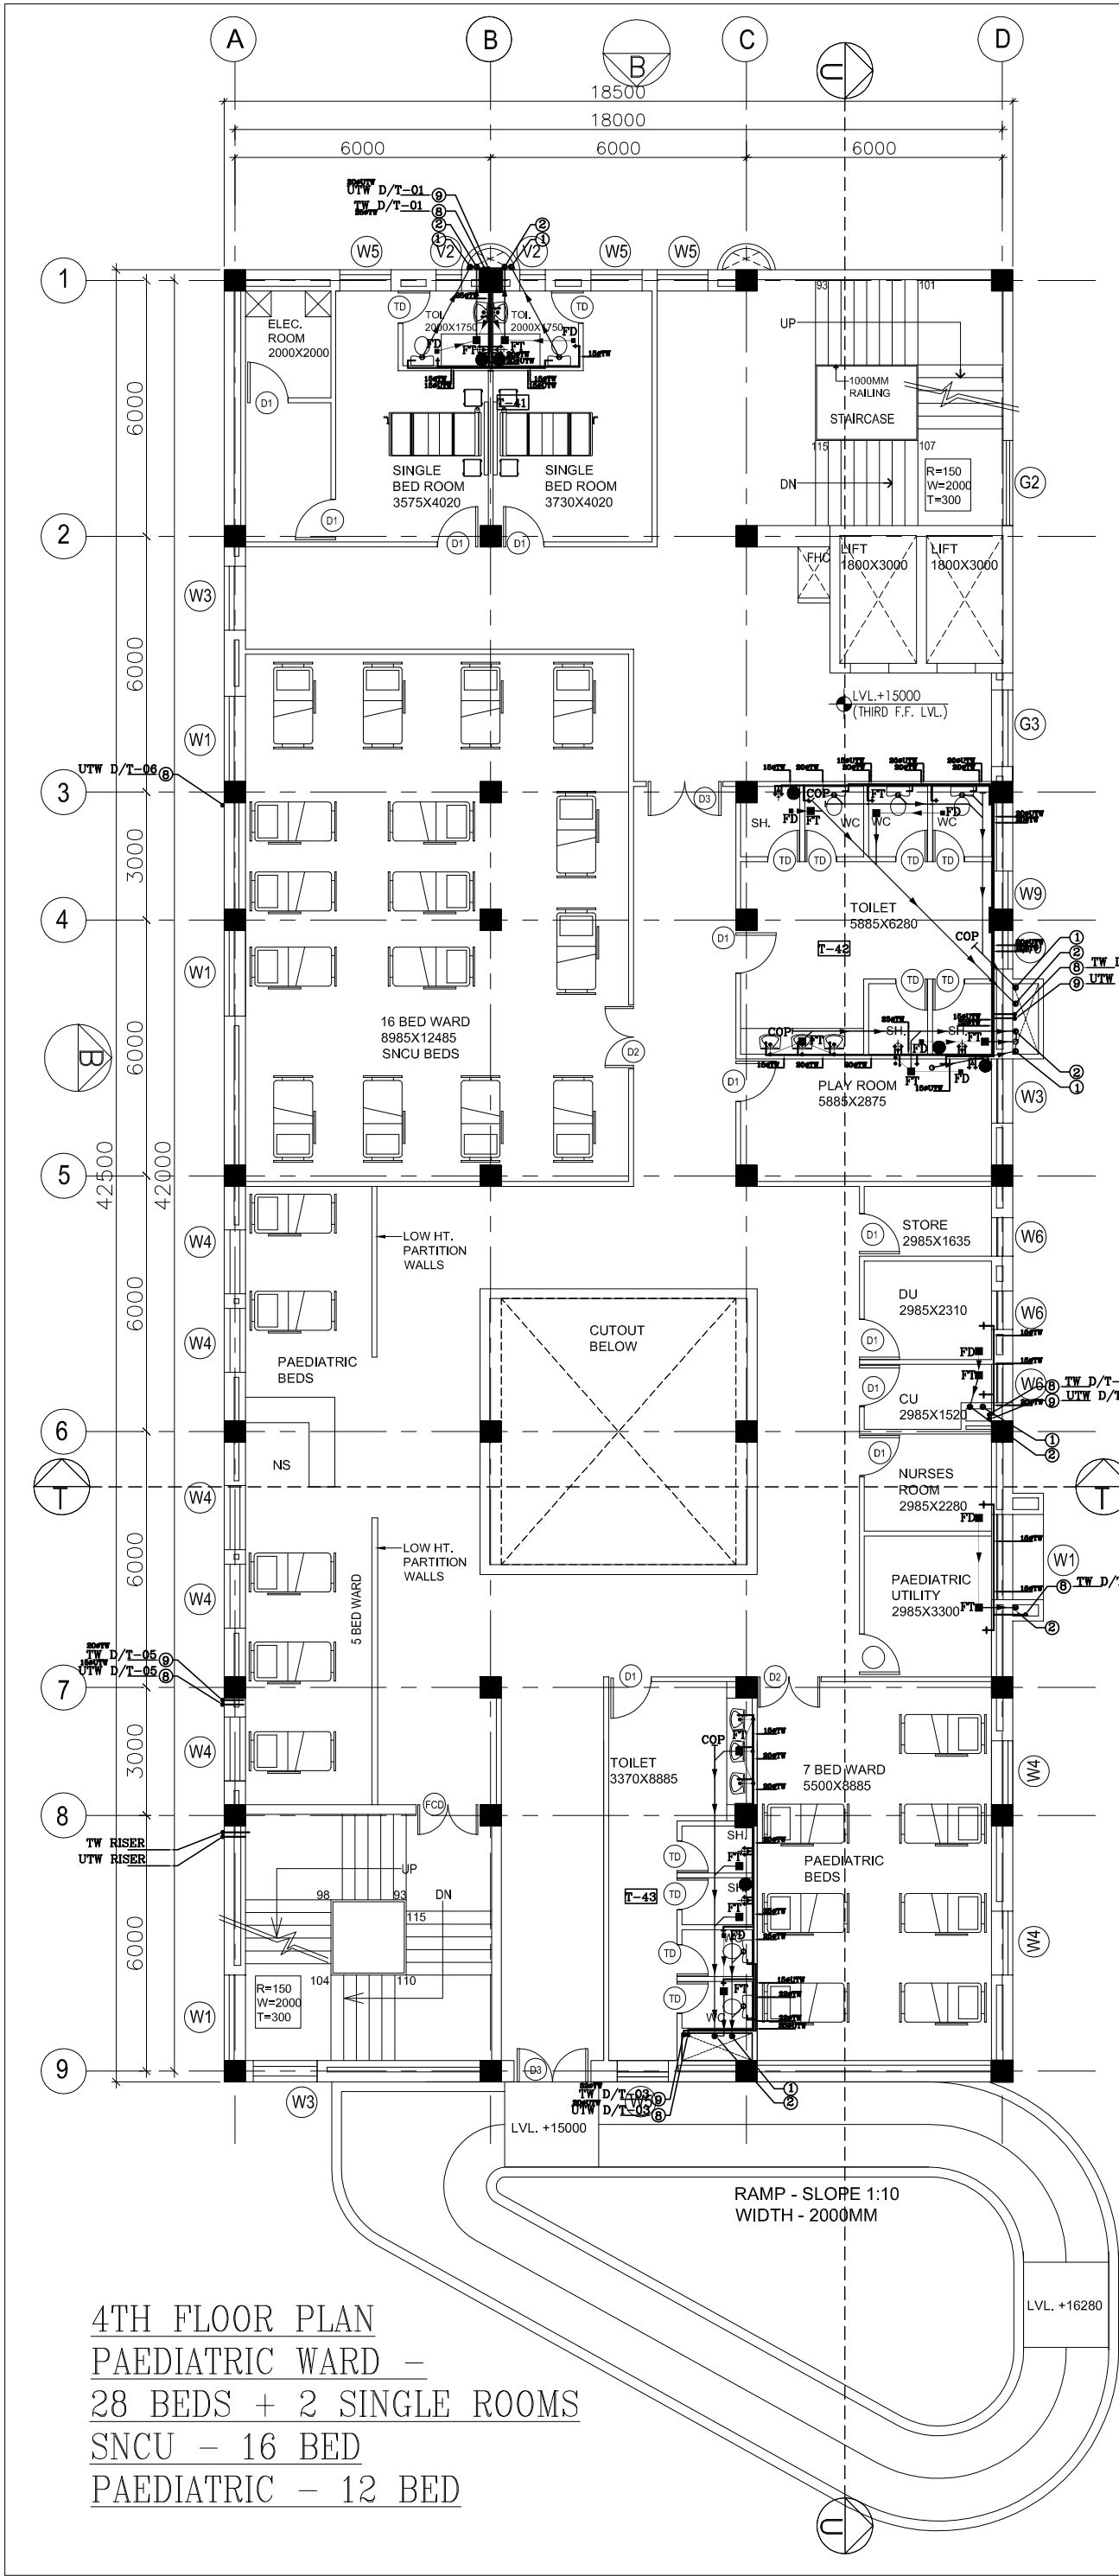

4TH FLOOR PLAN  
PAEDIATRIC WARD –  
28 BEDS + 2 SINGLE ROOMS  
SNCU – 16 BED  
PAEDIATRIC – 12 BED

This drawing with all its contents is the sole intellectual property of the Hospital Services Consultancy Corporation (India) Ltd. Copying of this drawing or part thereof or its use in any form whatsoever without the written permission of HSCC is prohibited.

NOTES

1. DRAWINGS TO BE READ NOT MEASURED
2. PARTITION WALL IN TOILETS UP TO UNTEL HEIGHT

NOTES

1. BASED ON THIS DRAWING EXECUTING AGENCY WILL PREPARE SHOP DRAWING AFTER INCORPORATING THE CHANGES AS PER SITE CONDITION FOR THE APPROVAL OF HSCC BEFORE START OF WORK.
2. THE NUMBER & LOCATION OF FIXTURES & NET POINT TO BE FINALIZED BEFORE EXECUTION WITH CLINT OFFICERS INCHARGE.

LEGEND:

|     |                           |
|-----|---------------------------|
| 1   | 100 Ø CI SOIL & VENT PIPE |
| 2   | 100Ø CI.WASTE & VENT PIPE |
| 3   | 100Ø CI. SOIL PIPE        |
| 4   | 100Ø CI. WASTE PIPE       |
| 5   | 50Ø uPVC SOIL PIPE        |
| 6   | 40Ø uPVC WASTE PIPE       |
| 7   | 32Ø uPVC WASTE PIPE       |
| 8   | Ø UTW DN.TAKE             |
| 9   | Ø TW DN.TAKE              |
| 10  | 100 Ø S.W. PIPE           |
| 11  | 100 Ø R.W. PIPE           |
| 12  | 100 Ø HDPE.LAB WASTE PIPE |
| 13  | 50 Ø HDPE.LAB WASTE PIPE  |
| F.T | FLOOR TRAP 100x100        |
| F.D | FLOOR DRAIN 50Ø           |
| FCO | FLOOR CLEAN OUT           |
| COP | CLEAN OUT PLUG            |
| ✕   | VALVE                     |
| MH  | MANHOLE (900x800)mm       |
| GT  | GULLY TRAP(300X300)mm     |

DESCRIPTION

REVISION

PROJECT

PROPOSED  
100 BEDDED HOSPITAL  
JAUNPUR

TITLE PLUMBING

TENDER DRAWING

FOURTH  
FLOOR PLAN

HSCC/D&E/TD/SHAH.JAHANPUR/PL-06

Drawing No. Rev.

Job No. 1:150 Scale MARCH-2013 Date

R.TYAGI App by R.SUR Rev. by S.BHATT Prep. by

HSCC (INDIA) LIMITED  
(A GOVERNMENT OF INDIA ENTERPRISES)

HSCC  
NEW DELHI INDIA