


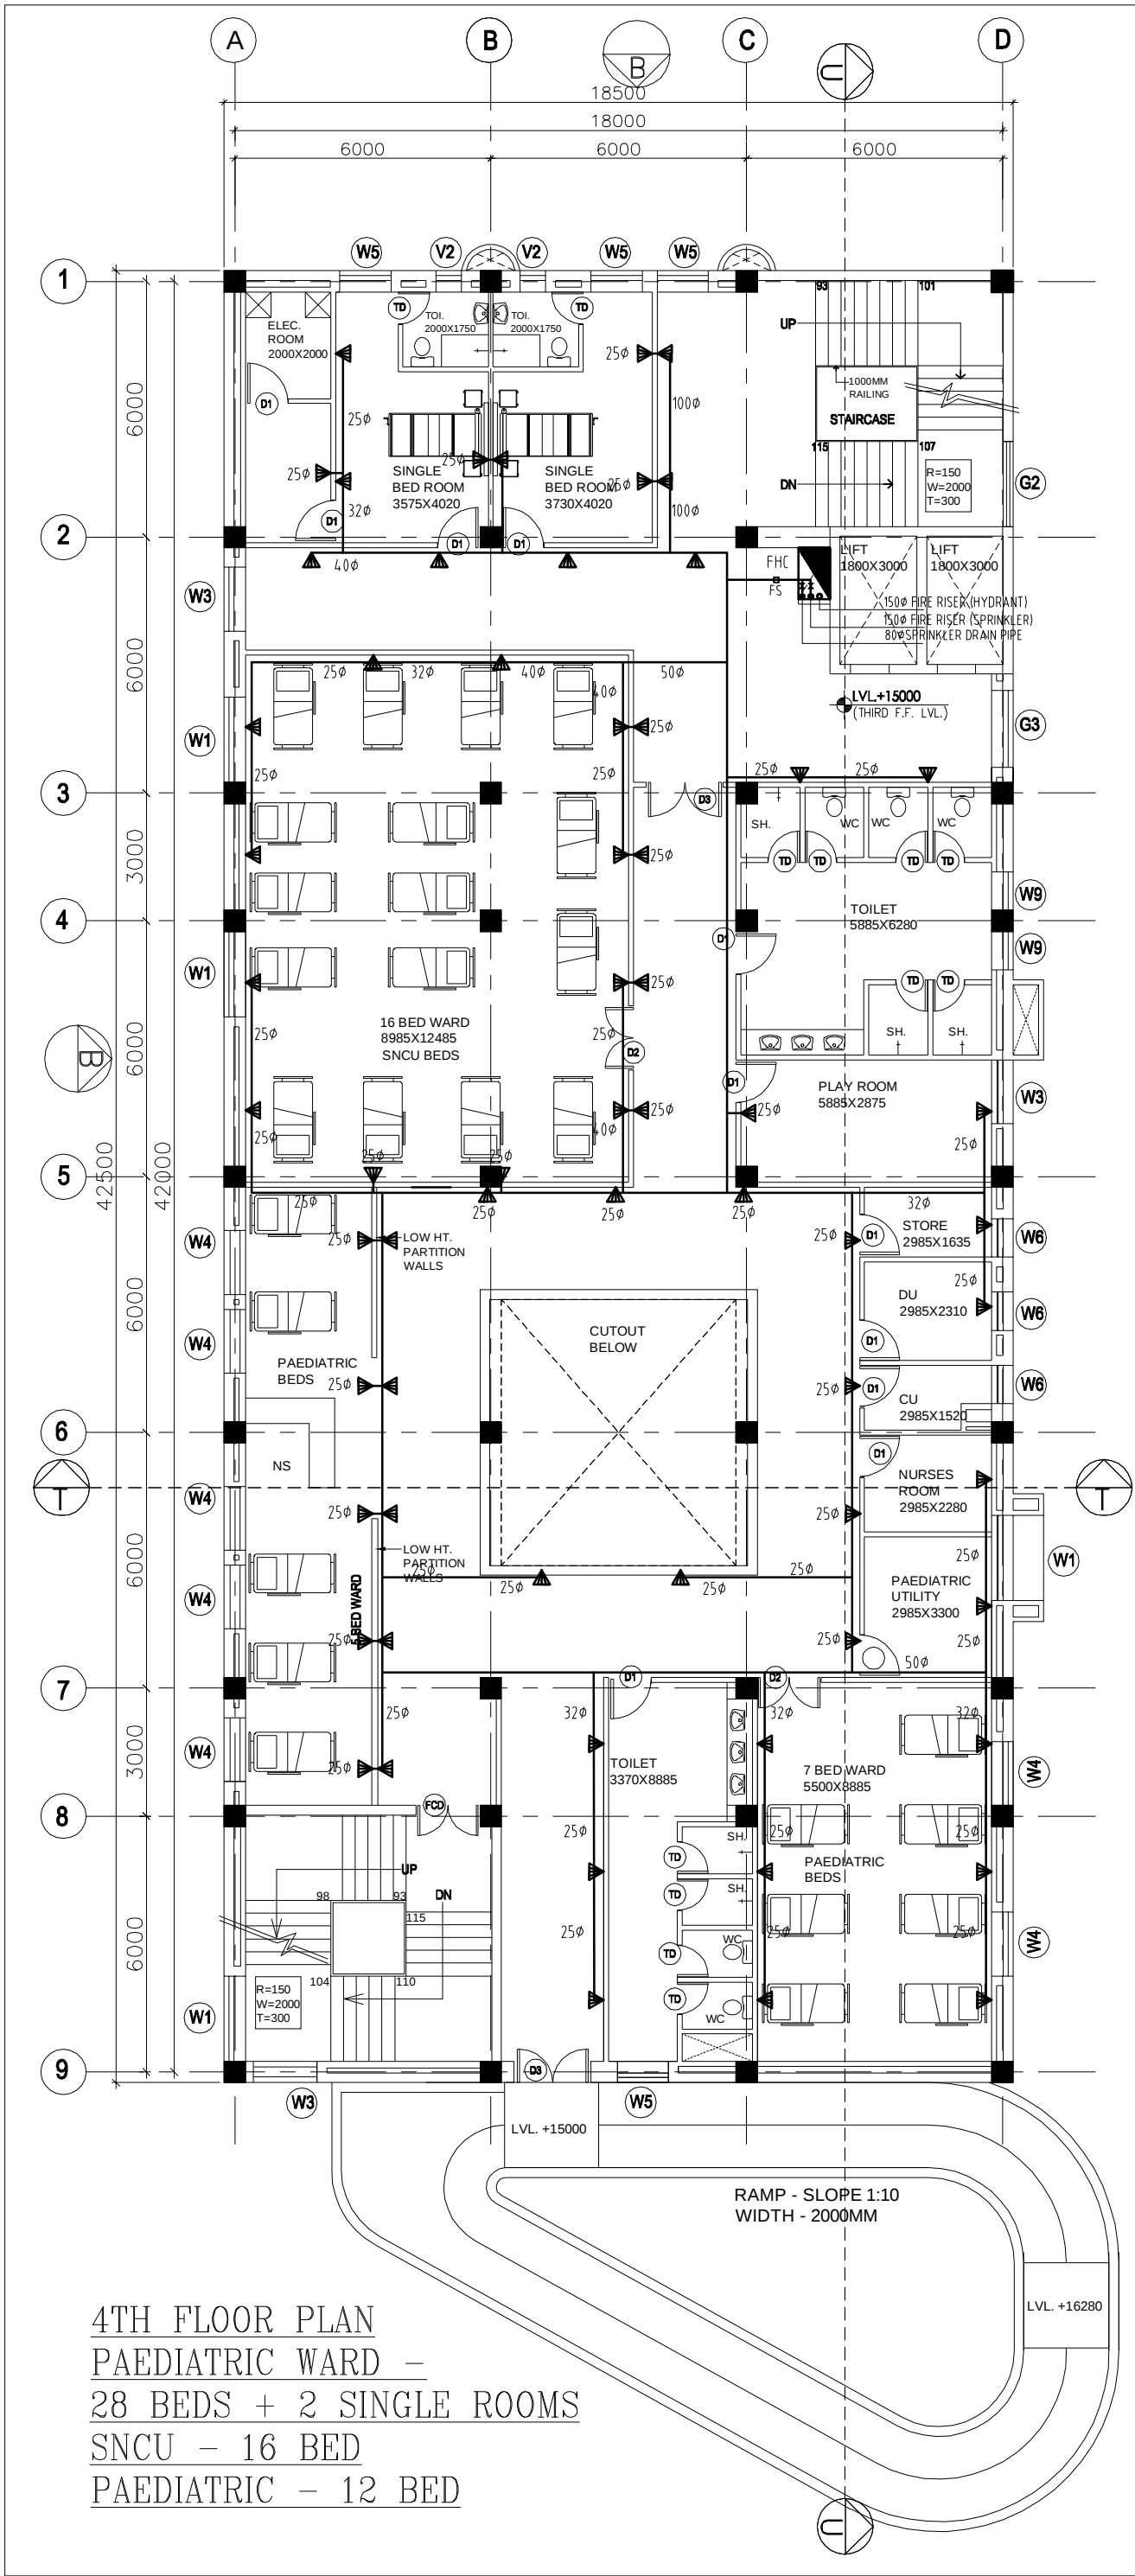

4TH FLOOR PLAN
PAEDIATRIC WARD –
28 BEDS + 2 SINGLE ROOMS
SNCU – 16 BED
PAEDIATRIC – 12 BED

This drawing with all its contents is the sole intellectual property of the Hospital Services Consultancy Corporation (India) Ltd. Copying of this drawing or part thereof or its use in any form whatsoever without the written permission of HSCC is prohibited.

NOTES

1. DRAWINGS TO BE READ NOT MEASURED
2. PARTITION WALL IN TOILETS UP TO LINTEL HEIGHT

NOTES

1. BASED ON THIS DRAWING EXECUTING AGENCY WILL PREPARE SHOP DRAWING AFTER INCORPORATING THE CHANGES AS PER SITE CONDITION FOR THE APPROVAL OF HSCC BEFORE START OF WORK.
2. THE NUMBER & LOCATION OF FIXTURES & FIT POINT TO BE FINALIZED BEFORE EXECUTION WITH CLIENT OFFICIALS INCHARGE..

LEGEND:

S.NO.	DESCRIPTION	SIMBAL
1.	FIRE HOSE CABINET (FHC) (size 1.2Mx0.6Mx2.1M H)	
2.	SPRINKLER (PENDENT TYPE) SPRINKLER (SIDE WALL)	
3.	SPRINKLER PIPE	
4.	INSPECTION TEST VALVE ASSEMBLY	
5.	NON RETURN VALVE	
6.	SLUICE VALVE	
7.	FIRE LINE	

FIRE EXTINGNISHER

WATER TYPE FIRE EXTINGNISHER	
CARBON DIOXIDE TYPE FIRE EXTINGNISHER	
MANUAL CALL BOX	

NOTES ON FIRE FIGHTING

1. Every FHC shall be consisting of as per IS the following:
 - (a) 63mm dia. single headed Hydrant Valve.
 - (b) 2nos. 63mm dia. 15mts long RRL. Hose reel.
 - (c) 20mm dia 36.5mt first aid hose reel with 5mm bore nozzle.
 - (d) 63mm dia.male and female INST type coupling.
 - (e) 20mm dia branch pipe with 20mm nozzle.
- (f) 2 NOS FIRE EXTINGUISHERS

LEGEND FOR VERTICAL PIPE.

- ① 1500 MS FIRE RISER
- ② SPRINKLER RISER
- ③ 50Ø SPRINKLER DRAIN PIPE

REVISION

PROJECT

PROPOSED
100 BEDDED HOSPITAL
JAUNPUR

TITLE FIRE-FIGHTING

TENDER DRAWING

FOURTH
FLOOR PLAN

HSCC/D&E/TD/SHAHJAHANPUR/FIRE-06

Drawing No. Rev.

Job No. 1:150 Scale MARCH-2013 Date

R.TYAGI App by R.SUR Rev. by S.BHATT Prep. by

HSCC (INDIA) LIMITED
(A GOVERNMENT OF INDIA ENTERPRISES)

HSCC
NEW DELHI INDIA