


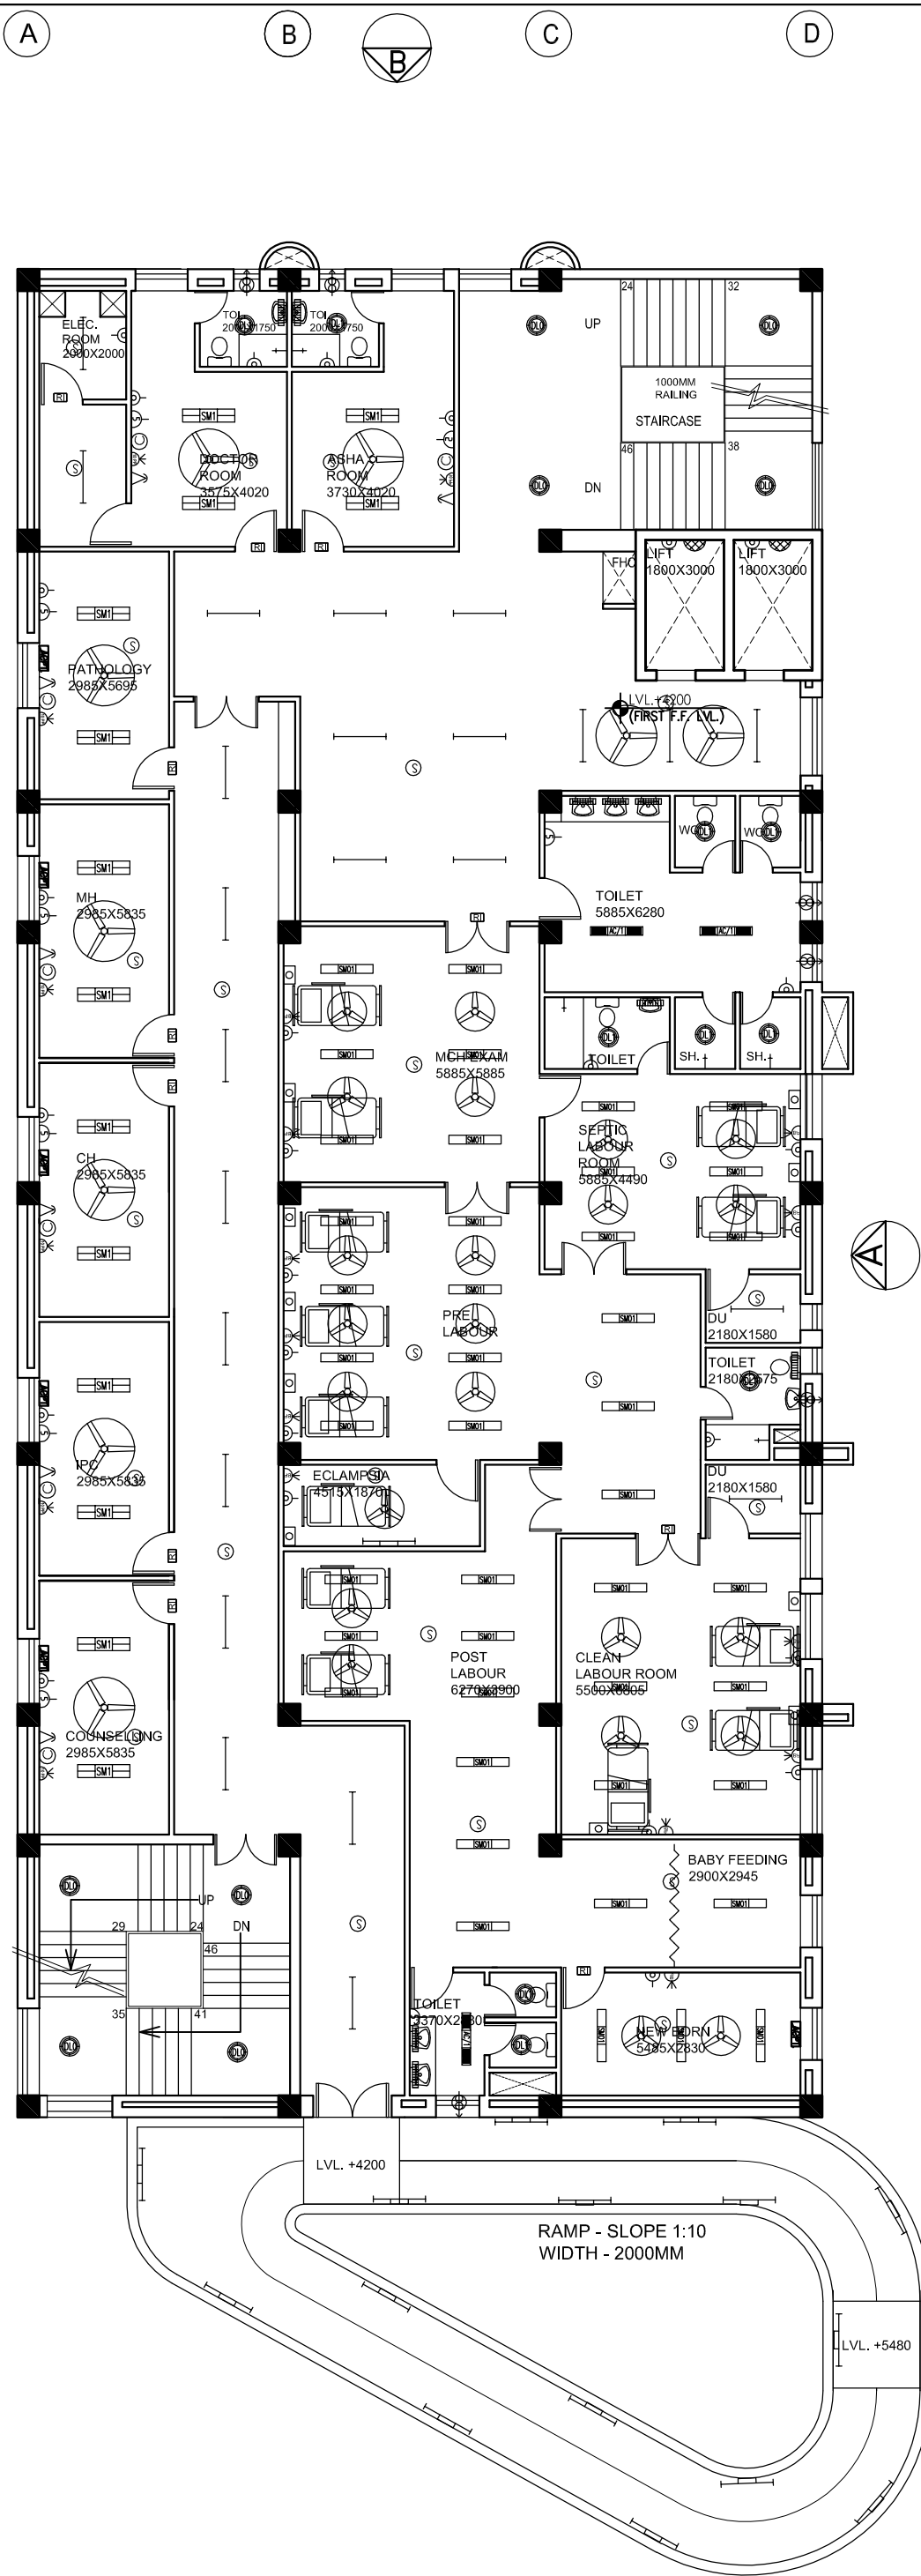

This drawing with all its contents is the sole intellectual property of the Hospital Services Consultancy Corporation (India) Ltd. Copying of this drawing or part thereof or its use in any form whatsoever without the written permission of HSCC is prohibited.

NOTES

1. DRAWINGS TO BE READ NOT MEASURED

2. PARTITION WALL IN TOILETS UP TO LINTEL HEIGHT

REVISION	DESCRIPTION

PROJECT

PROPOSED
100 BEDDED HOSPITAL
JAUNPUR

TITLE

TENDER DRAWING

FIRST
FLOOR PLAN

ELECTRICAL LAYOUT

HSCC/D&E/ID/JUP(JAUNPUR)/EL-203

Drawing No.

Rev.

Job No.	NTS Scale	MARCH-2013 Date

App by	Rev. by	Prep. by

HSCC (INDIA) LIMITED
(A GOVERNMENT OF INDIA ENTERPRISES)

HSCC

NEW DELHI

INDIA

1ST FLOOR PLAN
LABOUR ROOM+OPD