

A B C D

1

2

3

4


5

6

7

8

9

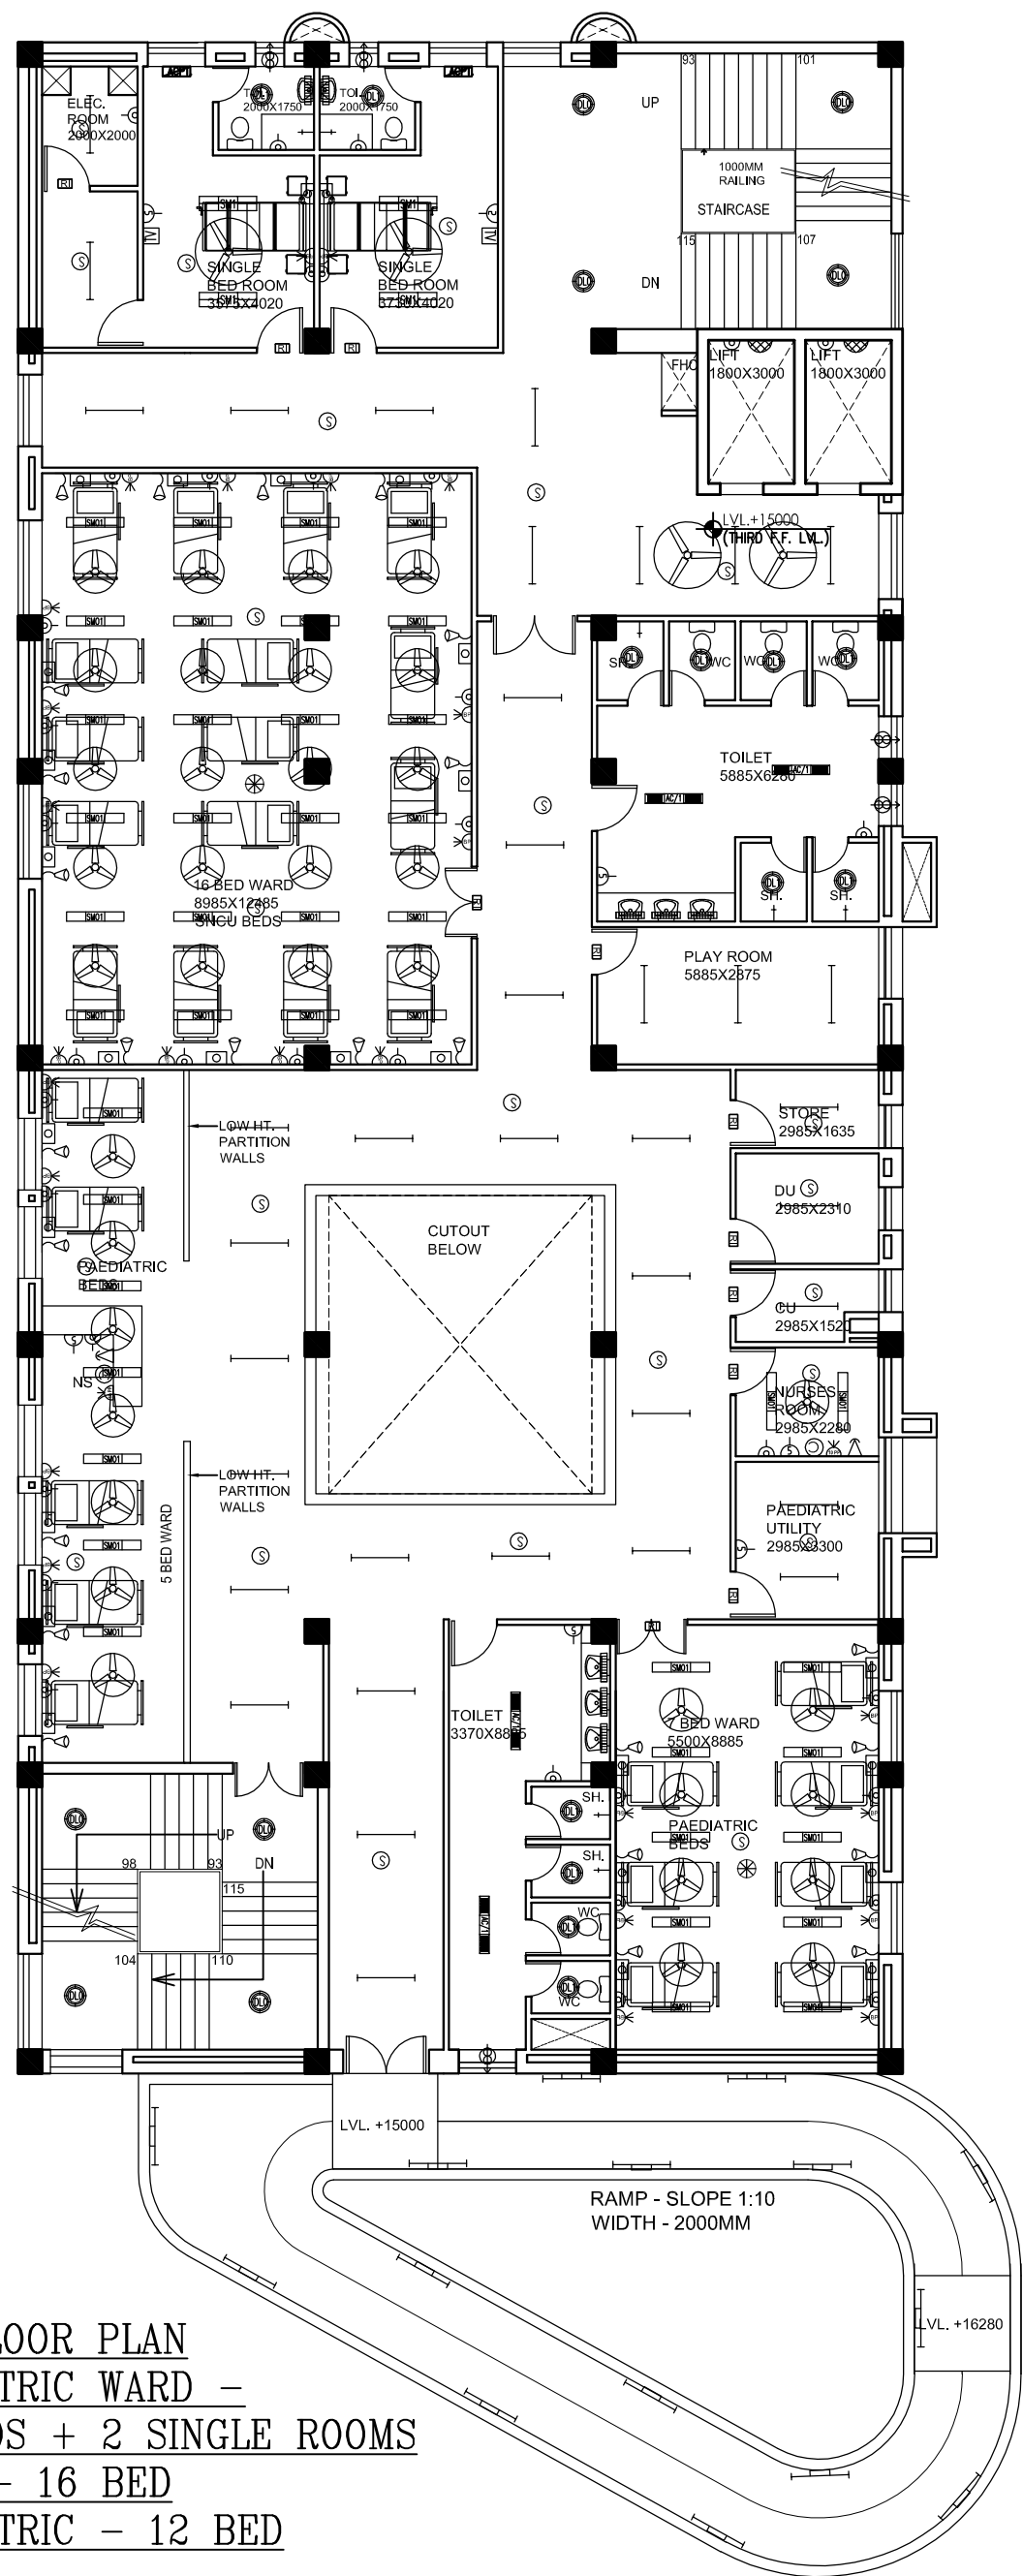

4TH FLOOR PLAN
PAEDIATRIC WARD -
28 BEDS + 2 SINGLE ROOMS
SNCU - 16 BED
PAEDIATRIC - 12 BED

This drawing with all its contents is the sole intellectual property of the Hospital Services Consultancy Corporation (India) Ltd. Copying of this drawing or part thereof or its use in any form whatsoever without the written permission of HSCC is prohibited.

NOTES

1. DRAWINGS TO BE READ NOT MEASURED
2. PARTITION WALL IN TOILETS UP TO LINTEL HEIGHT

REVISION		DESCRIPTION

PROJECT

PROPOSED
100 BEDDED HOSPITAL
JAUNPUR

TITLE

TENDER DRAWING

FOURTH
FLOOR PLAN

ELECTRICAL LAYOUT

HSCC/D&E/ID/JUP(JAUNPUR)/EL-206		
Drawing No.	NTS	Rev.
Job No.	Scale	MARCH-2013 Date
App by	Rev. by	Prep. by

HSCC (INDIA) LIMITED
(A GOVERNMENT OF INDIA ENTERPRISES)
HSCC
NEW DELHI INDIA