

A B C D

1

2

3

4


5

6

7

8

9

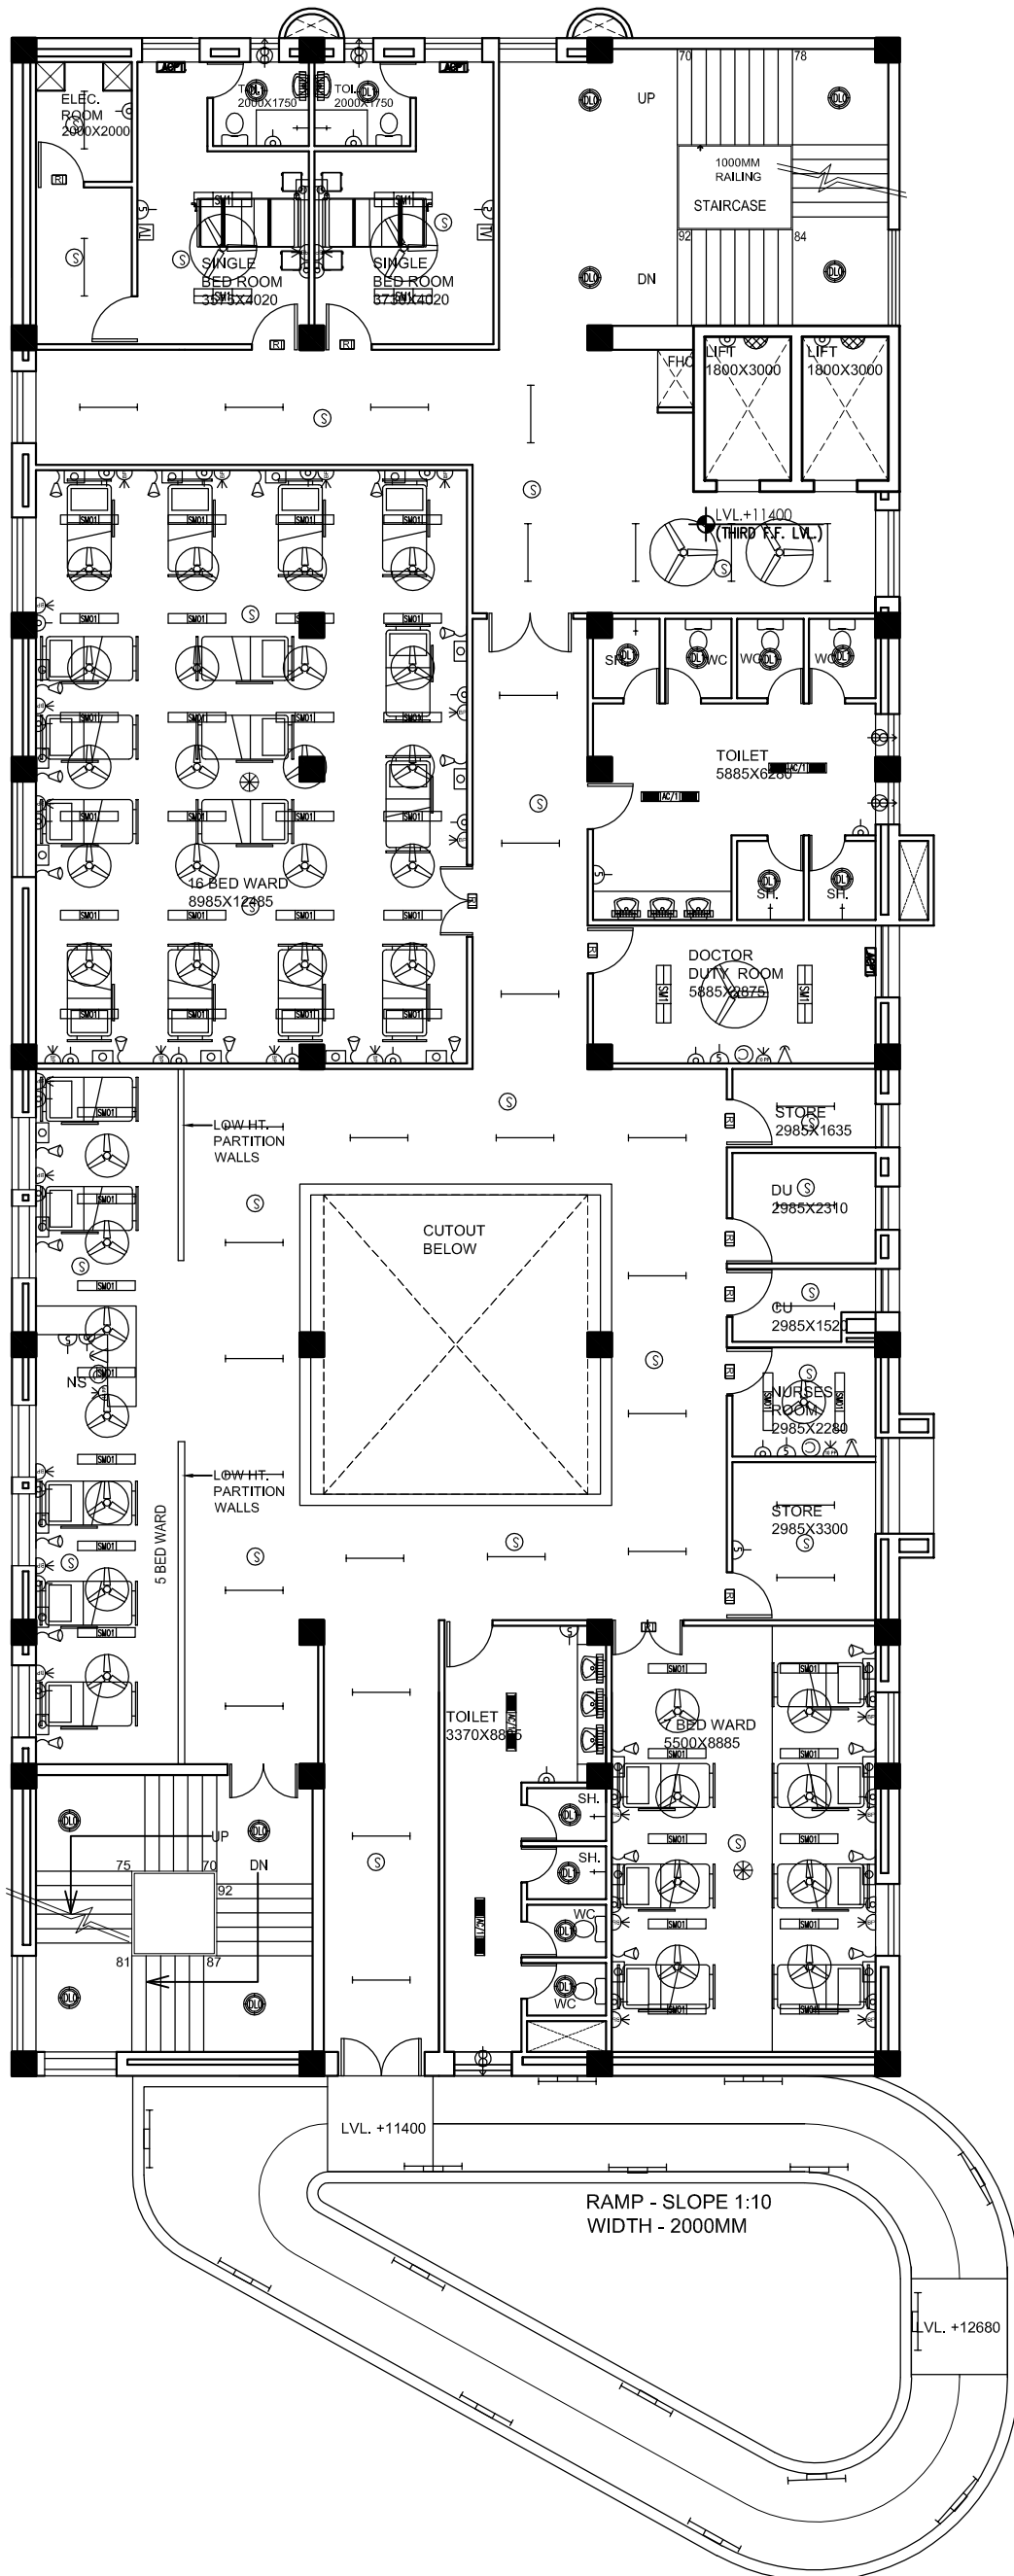

3RD FLOOR PLAN
POST NATAL – 28 BED
MATERNITY WARD +
2 SINGLE ROOMS

This drawing with all its contents is the sole intellectual property of the Hospital Services Consultancy Corporation (India) Ltd. Copying of this drawing or part thereof or its use in any form whatsoever without the written permission of HSCC is prohibited.

- NOTES
1. DRAWINGS TO BE READ NOT MEASURED
 2. PARTITION WALL IN TOILETS UP TO LINTEL HEIGHT

REVISION		DESCRIPTION

PROJECT

PROPOSED
100 BEDDED HOSPITAL
JAUNPUR

TITLE

TENDER DRAWING

THIRD
FLOOR PLAN
ELECTRICAL LAYOUT

HSCC/D&E/ID/JUP(JAUNPUR)/EL-205		
Drawing No.	NTS	Rev.
Job No.	Scale	MARCH-2013 Date
App by	Rev. by	Prep. by

HSCC (INDIA) LIMITED
(A GOVERNMENT OF INDIA ENTERPRISES)
HSCC
NEW DELHI INDIA