


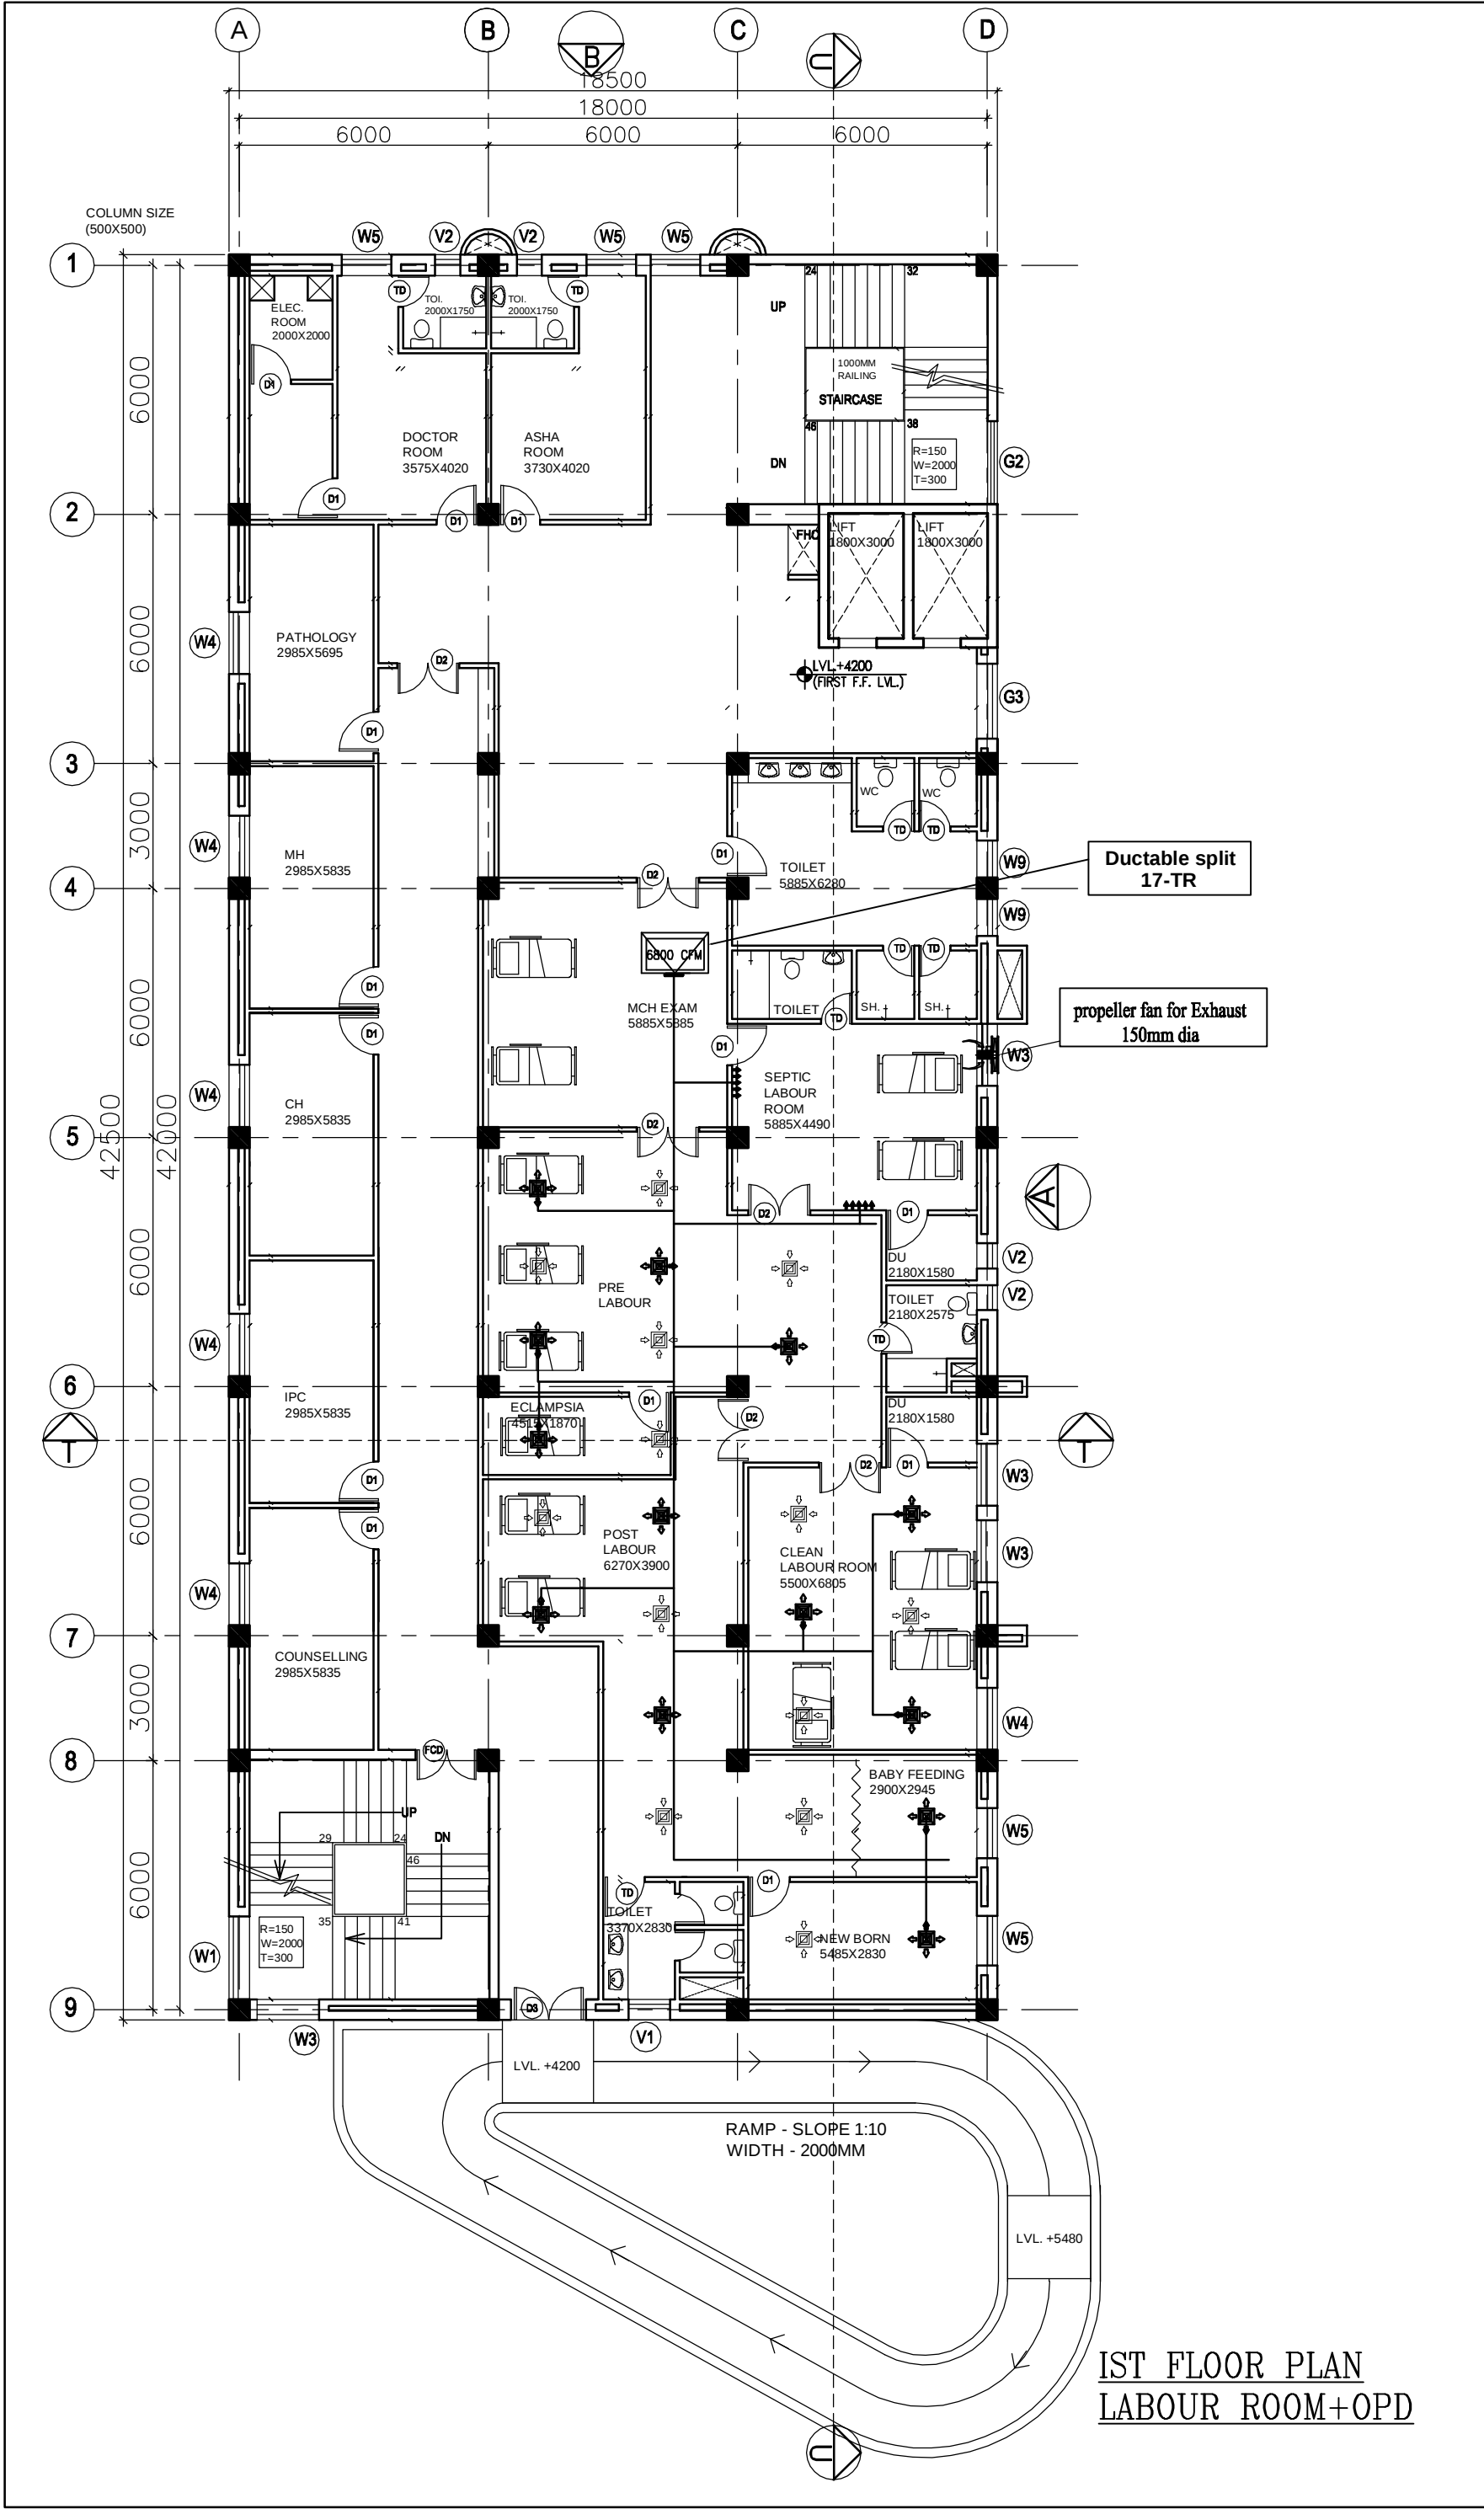

This drawing with all its contents is the sole intellectual property of the Hospital Services Consultancy Corporation (India) Ltd. Copying of this drawing or part thereof or its use in any form whatsoever without the written permission of HSCC is prohibited.

NOTES

1. DRAWINGS TO BE READ NOT MEASURED

2. PARTITION WALL IN TOILETS UP TO LINTEL HEIGHT

REVISION	
NO.	DESCRIPTION

PROJECT

PROPOSED
100 BEDDED HOSPITAL
JAUNPUR

TITLE

TENDER DRAWING

FIRST FLOOR PLAN

HVAC LAYOUT

HSCC/D&E/HVAC/UP-JAUNPUR/AC-02		
Drawing No.		Rev.
Job No.	1:150 Scale	MARCH-2013 Date
App by	Rev. by	Prep. by

HSCC (INDIA) LIMITED
(A GOVERNMENT OF INDIA ENTERPRISES)

HSCC

NEW DELHI INDIA