

NOTES

1. DRAWINGS TO BE READ NOT MEASURED
2. PARTITION WALL IN TOILETS UP TO LINTEL
HEIGHT

NOTES

ON THIS DRAWING EXECUTING AGENCY WILL PREPARE SHOP DRAWING AFTER INCORPORATING THE CHANGES AS PER SITE CONDITION FOR THE APPROVAL OF HSEC BEFORE START OF WORK.

THE NUMBER & LOCATION OF FIXTURES & WET POINT TO BE FINALIZED BEFORE EXECUTION WITH CLINT OFFICER'S INCHARGE..

1	100 Ø CI SOIL & VENT PIPE
2	100Ø CI.WASTE & VENT PIPE
3	100Ø CI. SOIL PIPE
4	100Ø CI. WASTE PIPE
5	50Ø uPVC SOIL PIPE
6	40Ø UPVC WASTE PIPE
7	32Ø uPVC WASTE PIPE
8	Ø UTW DN.TAKE
9	Ø TW DN.TAKE
10	100 Ø S.W. PIPE
11	100 Ø R.W. PIPE
12	100 Ø HDPE.LAB WASTE PIPE
13	50 Ø HDPE.LAB WASTE PIPE
F.T	FLOOR TRAP 100x100
F.D	FLOOR DRAIN 50Ø
FOO	FLOOR CLEAN OUT
COP	CLEAN OUT PLUG
∇	VALVE
MH	MANHOLE (900x800)mm
GT	GULLY TRAP(300x300)mm

		DESCRIPTION		
REVISION				

**PROPOSED
100 BEDDED HOSPITAL
PILIBHIT**

TENDER DRAWING


THIRD FLOOR PLAN

HSCC/D&E/TD/PILBHIT/PL-05
Drawing No.

Job No.	1:150 Scale	MARCH-2013 Date
---------	----------------	--------------------

App by	Rev. by	Prep. by
--------	---------	----------

HSCC (INDIA) LIMITED
(A GOVERNMENT OF INDIA ENTERPRISES)
HSCC
NEW DELHI INDIA

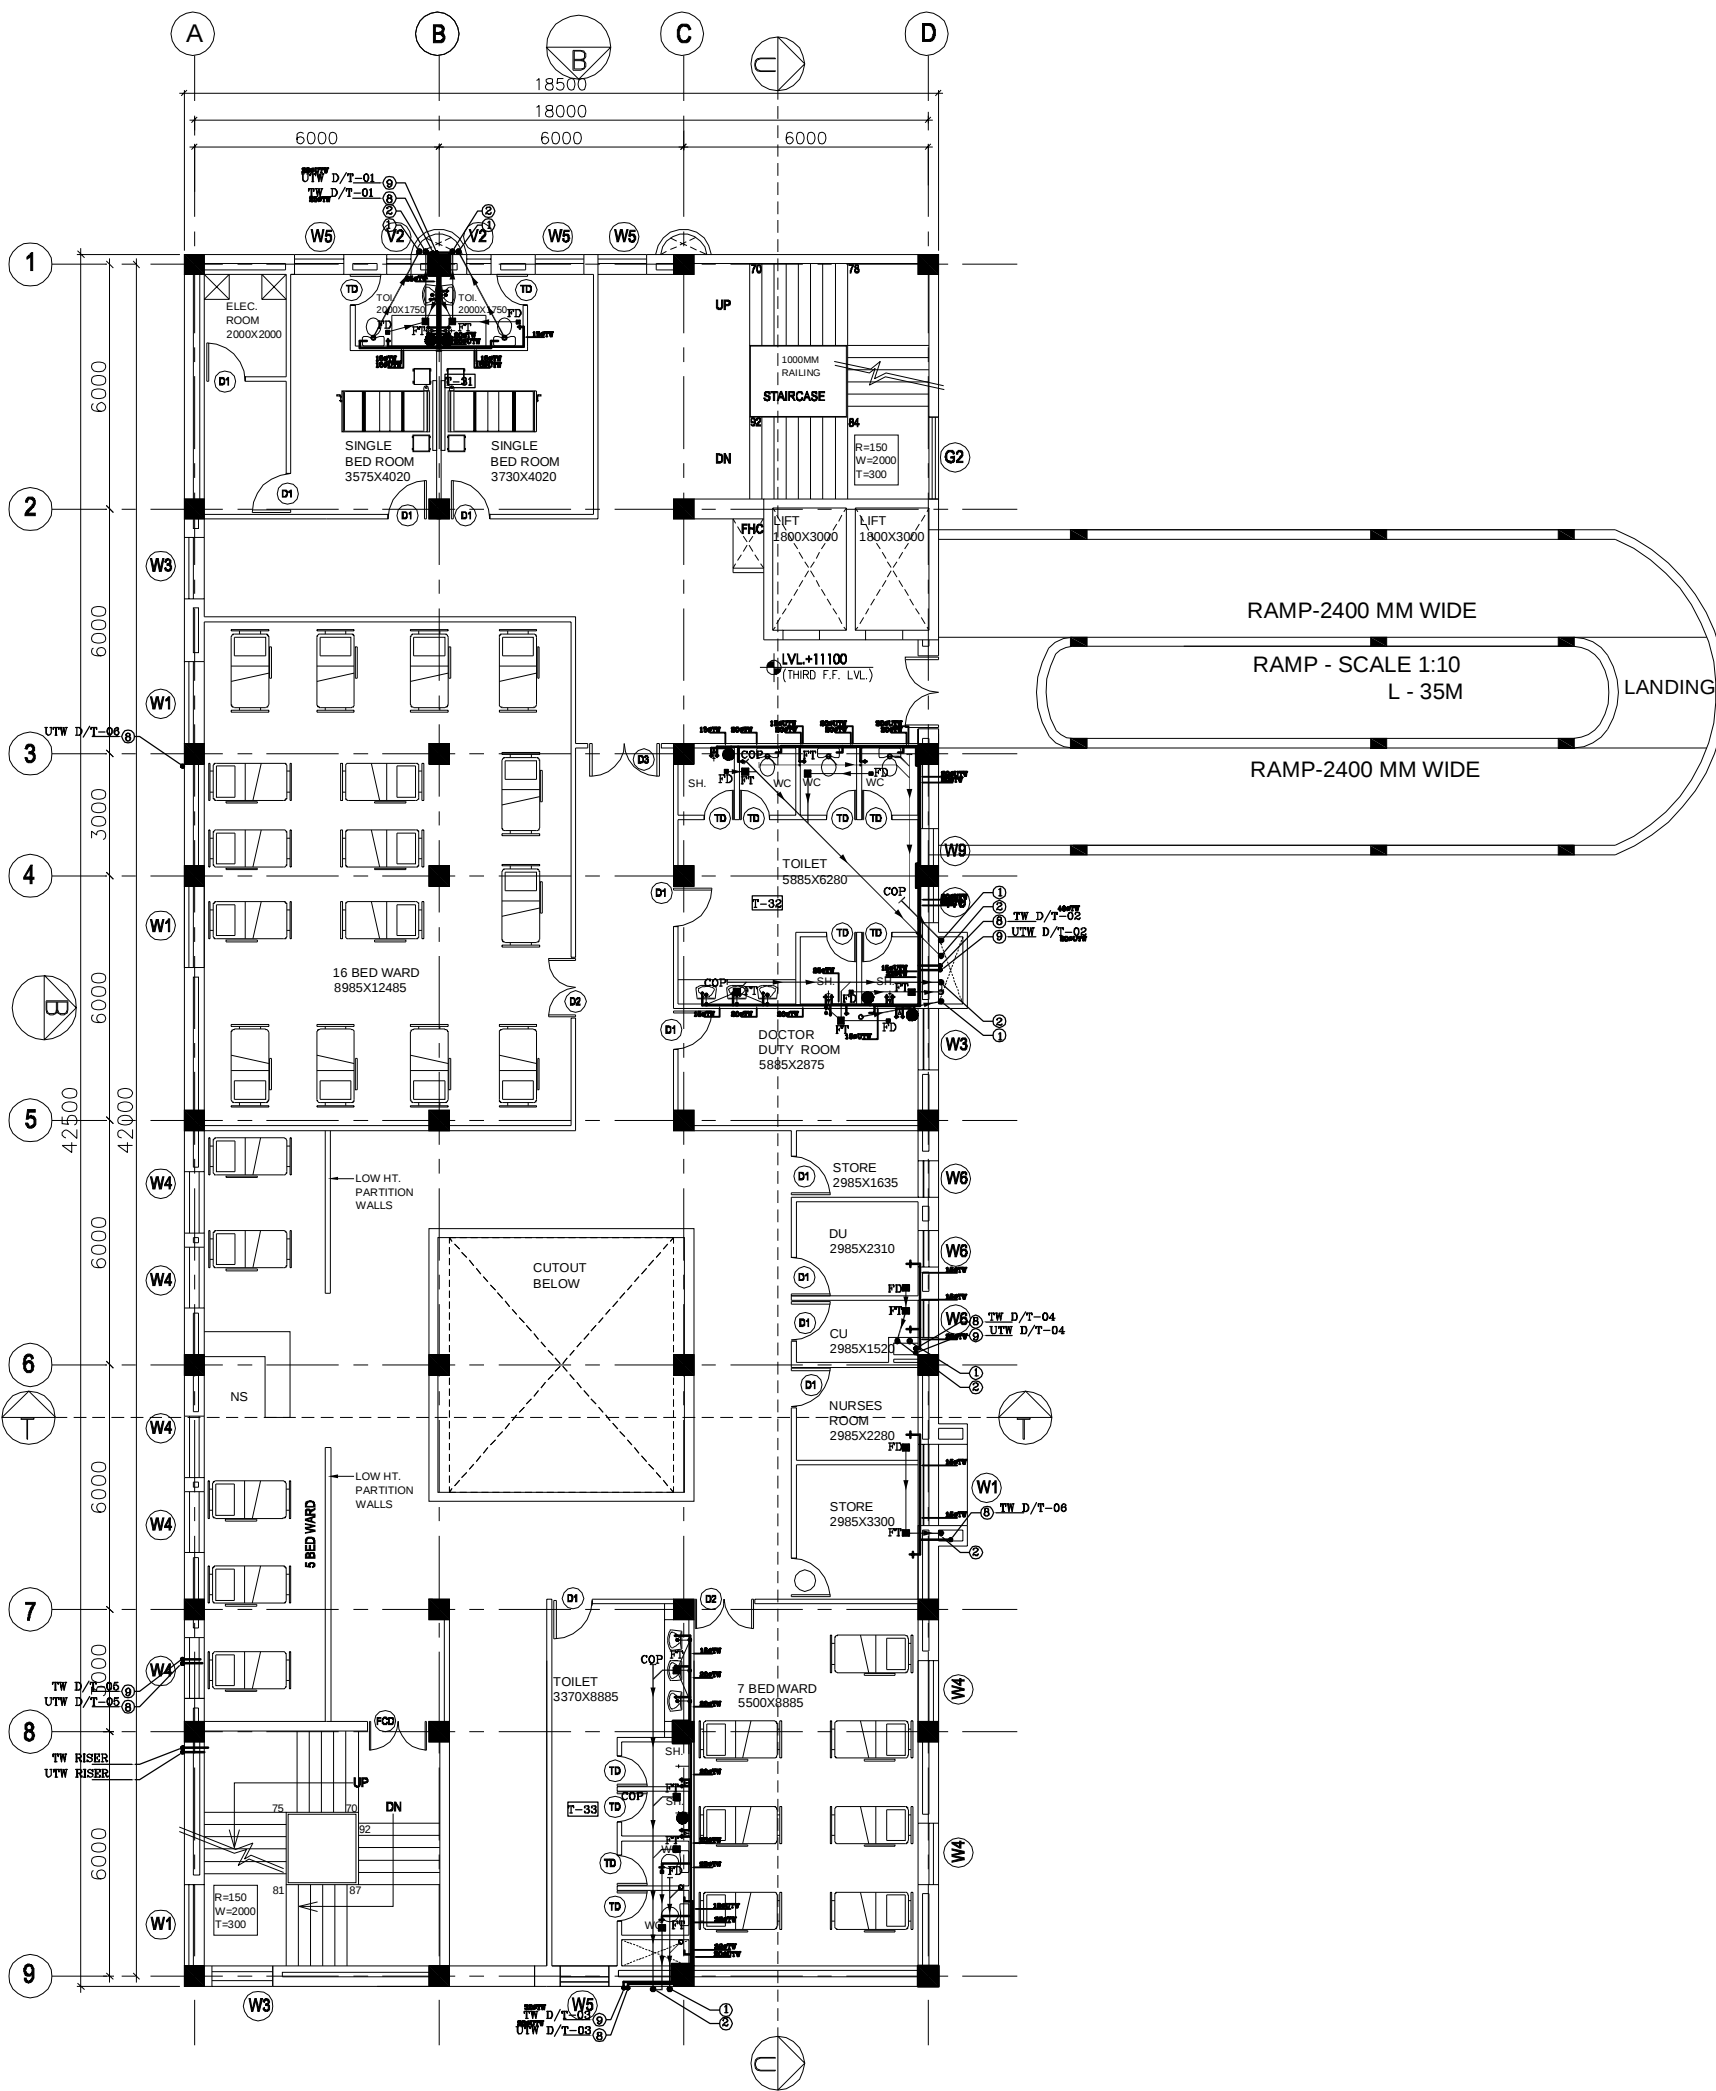

3RD FLOOR PLAN
POST NATAL – 28 BED
MATERNITY WARD +
2 SINGLE ROOMS