

This drawing with all its contents is the sole intellectual property of the Hospital Services Consultancy Corporation (India) Ltd. Copying of this drawing or part thereof or its use in any form whatsoever without the written permission of HSCC is prohibited.

NOTES


- DRAWINGS TO BE READ NOT MEASURED
- PARTITION WALL IN TOILETS UP TO LINTEL HEIGHT

NOTES

- BASED ON THIS DRAWING EXECUTING AGENCY WILL PREPARE SHOP DRAWING AFTER INCORPORATING THE CHANGES AS PER SITE CONDITION FOR THE APPROVAL OF HSCC BEFORE START OF WORK.
- THE NUMBER & LOCATION OF FIXTURES & SET POINT TO BE FINALIZED BEFORE EXECUTION WITH CLIENT OFFICIALS INDICATED.

LEGEND:

1	100 Ø CI SOIL & VENT PIPE
2	100Ø CI.WASTE & VENT PIPE
3	100Ø CI. SOIL PIPE
4	100Ø CI. WASTE PIPE
5	50Ø uPVC SOIL PIPE
6	40Ø uPVC WASTE PIPE
7	32Ø uPVC WASTE PIPE
8	Ø UTW DN.TAKE
9	Ø TW DN.TAKE
10	100 Ø S.W. PIPE
11	100 Ø R.W. PIPE
12	100 Ø HDPE LAB WASTE PIPE
13	50 Ø HDPE LAB WASTE PIPE
F.T	FLOOR TRAP 100x100
F.D	FLOOR DRAIN 50Ø
FOO	FLOOR CLEAN OUT
COP	CLEAN OUT PLUG
✕	VALVE
MH	MANHOLE (900x800)mm
GT	GULLY TRAP(300X300)mm

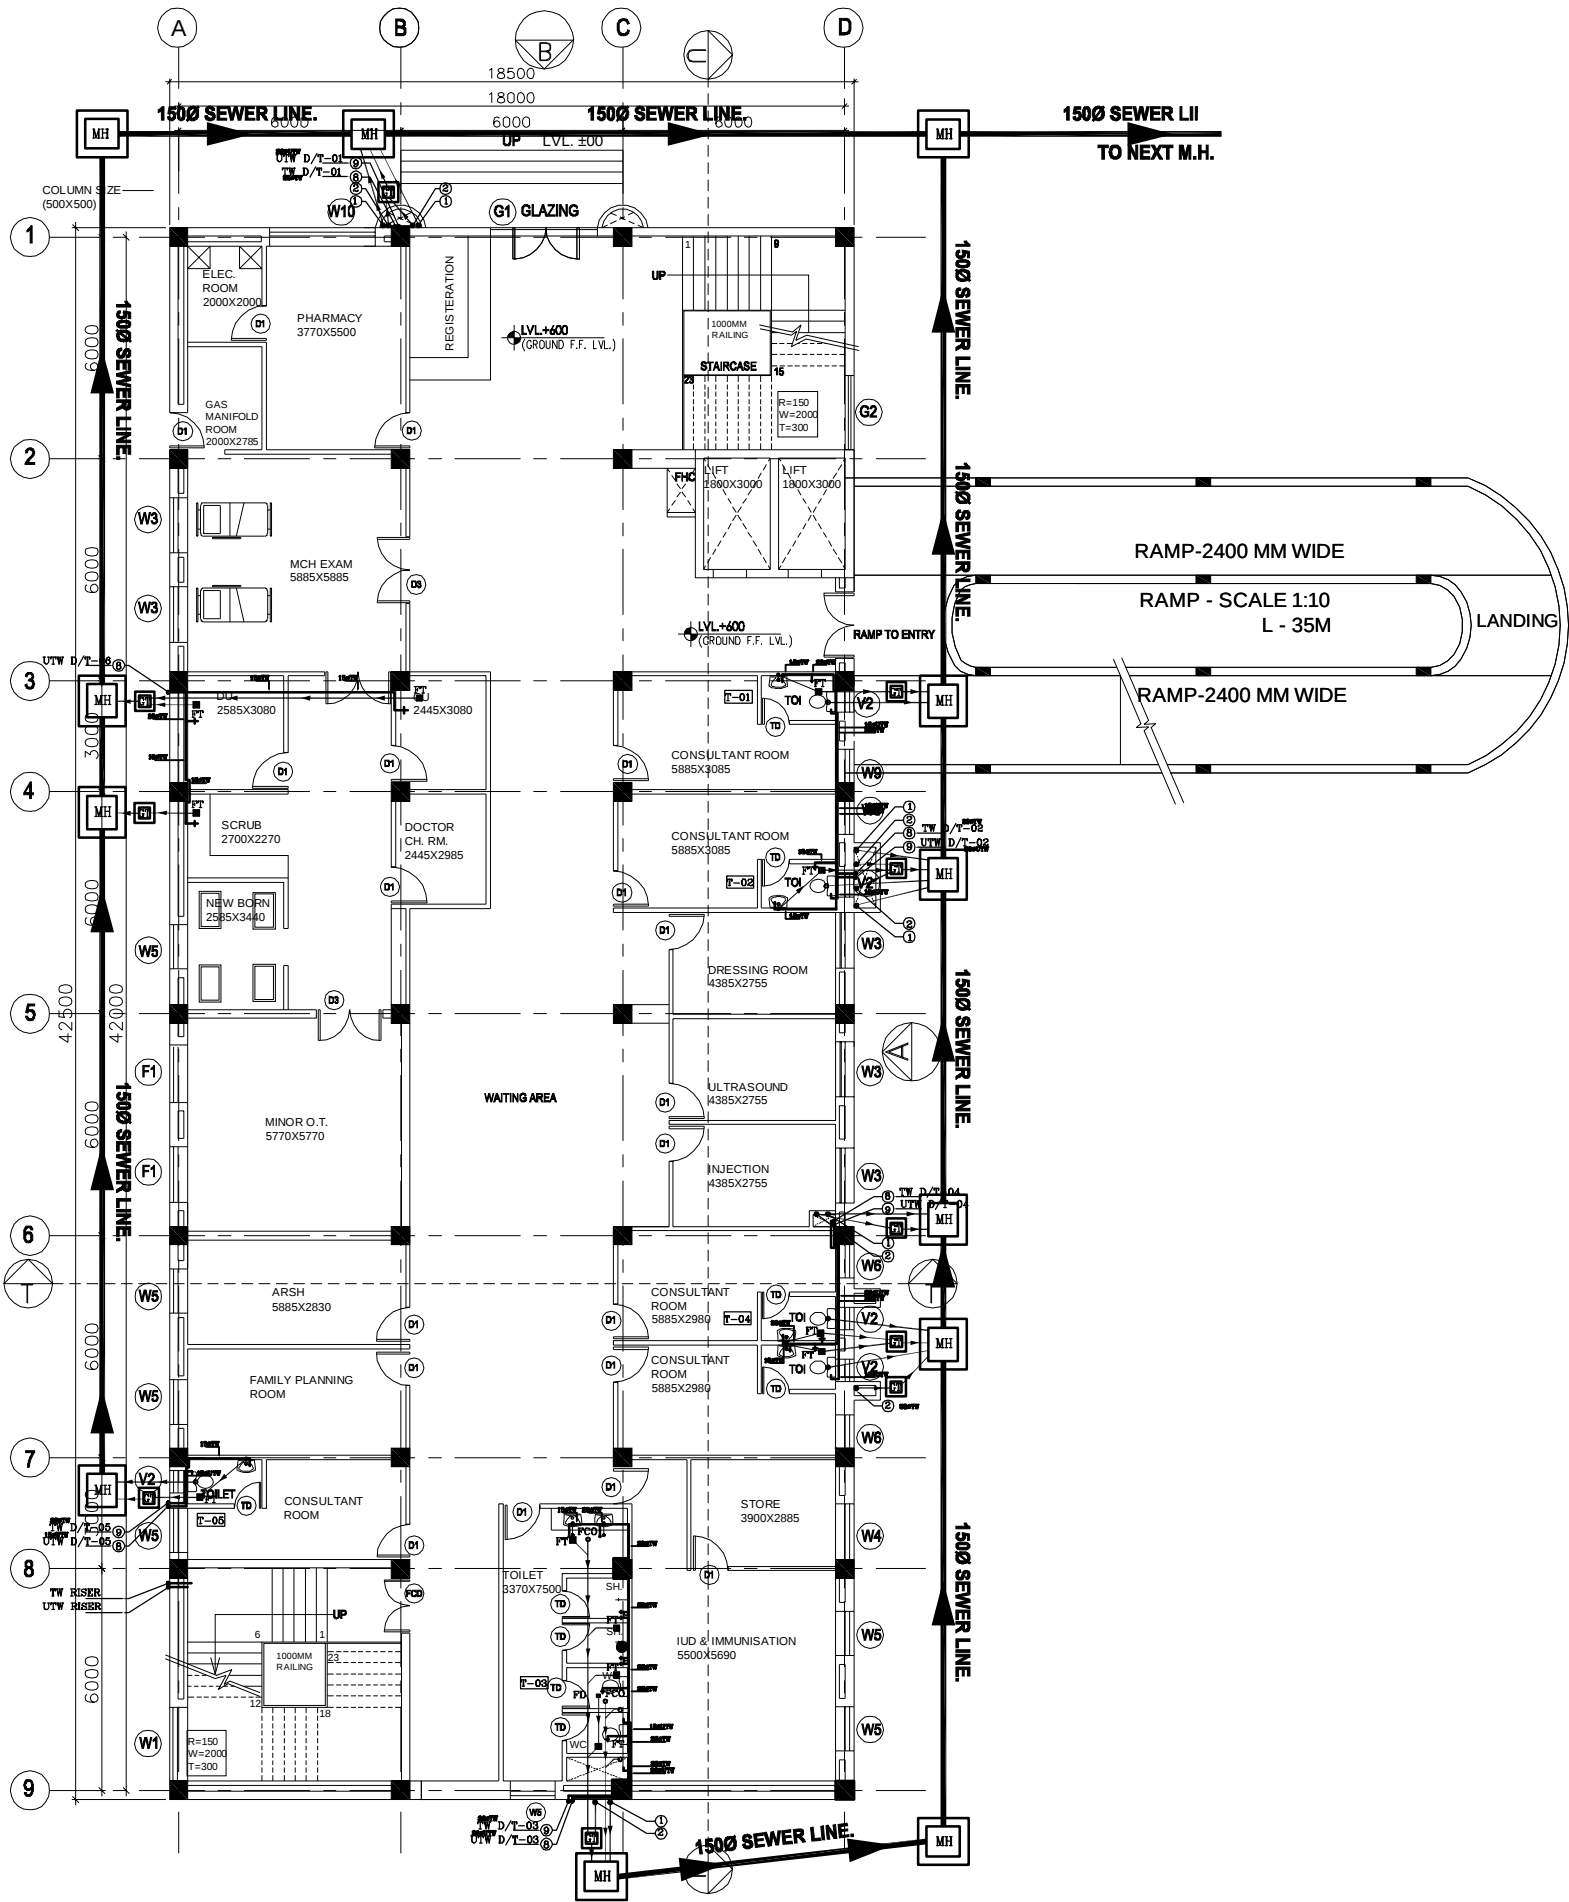

GROUND FLOOR PLAN
EMERGENCY + OPD

REVISION

PROJECT

PROPOSED
100 BEDDED HOSPITAL
PILIBHIT

TITLE PLUMBING

TENDER DRAWING

GROUND
FLOOR PLAN

HSCC/D&E/TD/PILIBHIT/PL-02

Drawing No.

Rev.

Job No.

Scale

March-2013
Date

R.TYAGI

App by

R.SUR

Rev. by

S.BHATT

Prep. by

HSCC (INDIA) LIMITED
(A GOVERNMENT OF INDIA ENTERPRISE)

HSCC

NEW DELHI

INDIA