


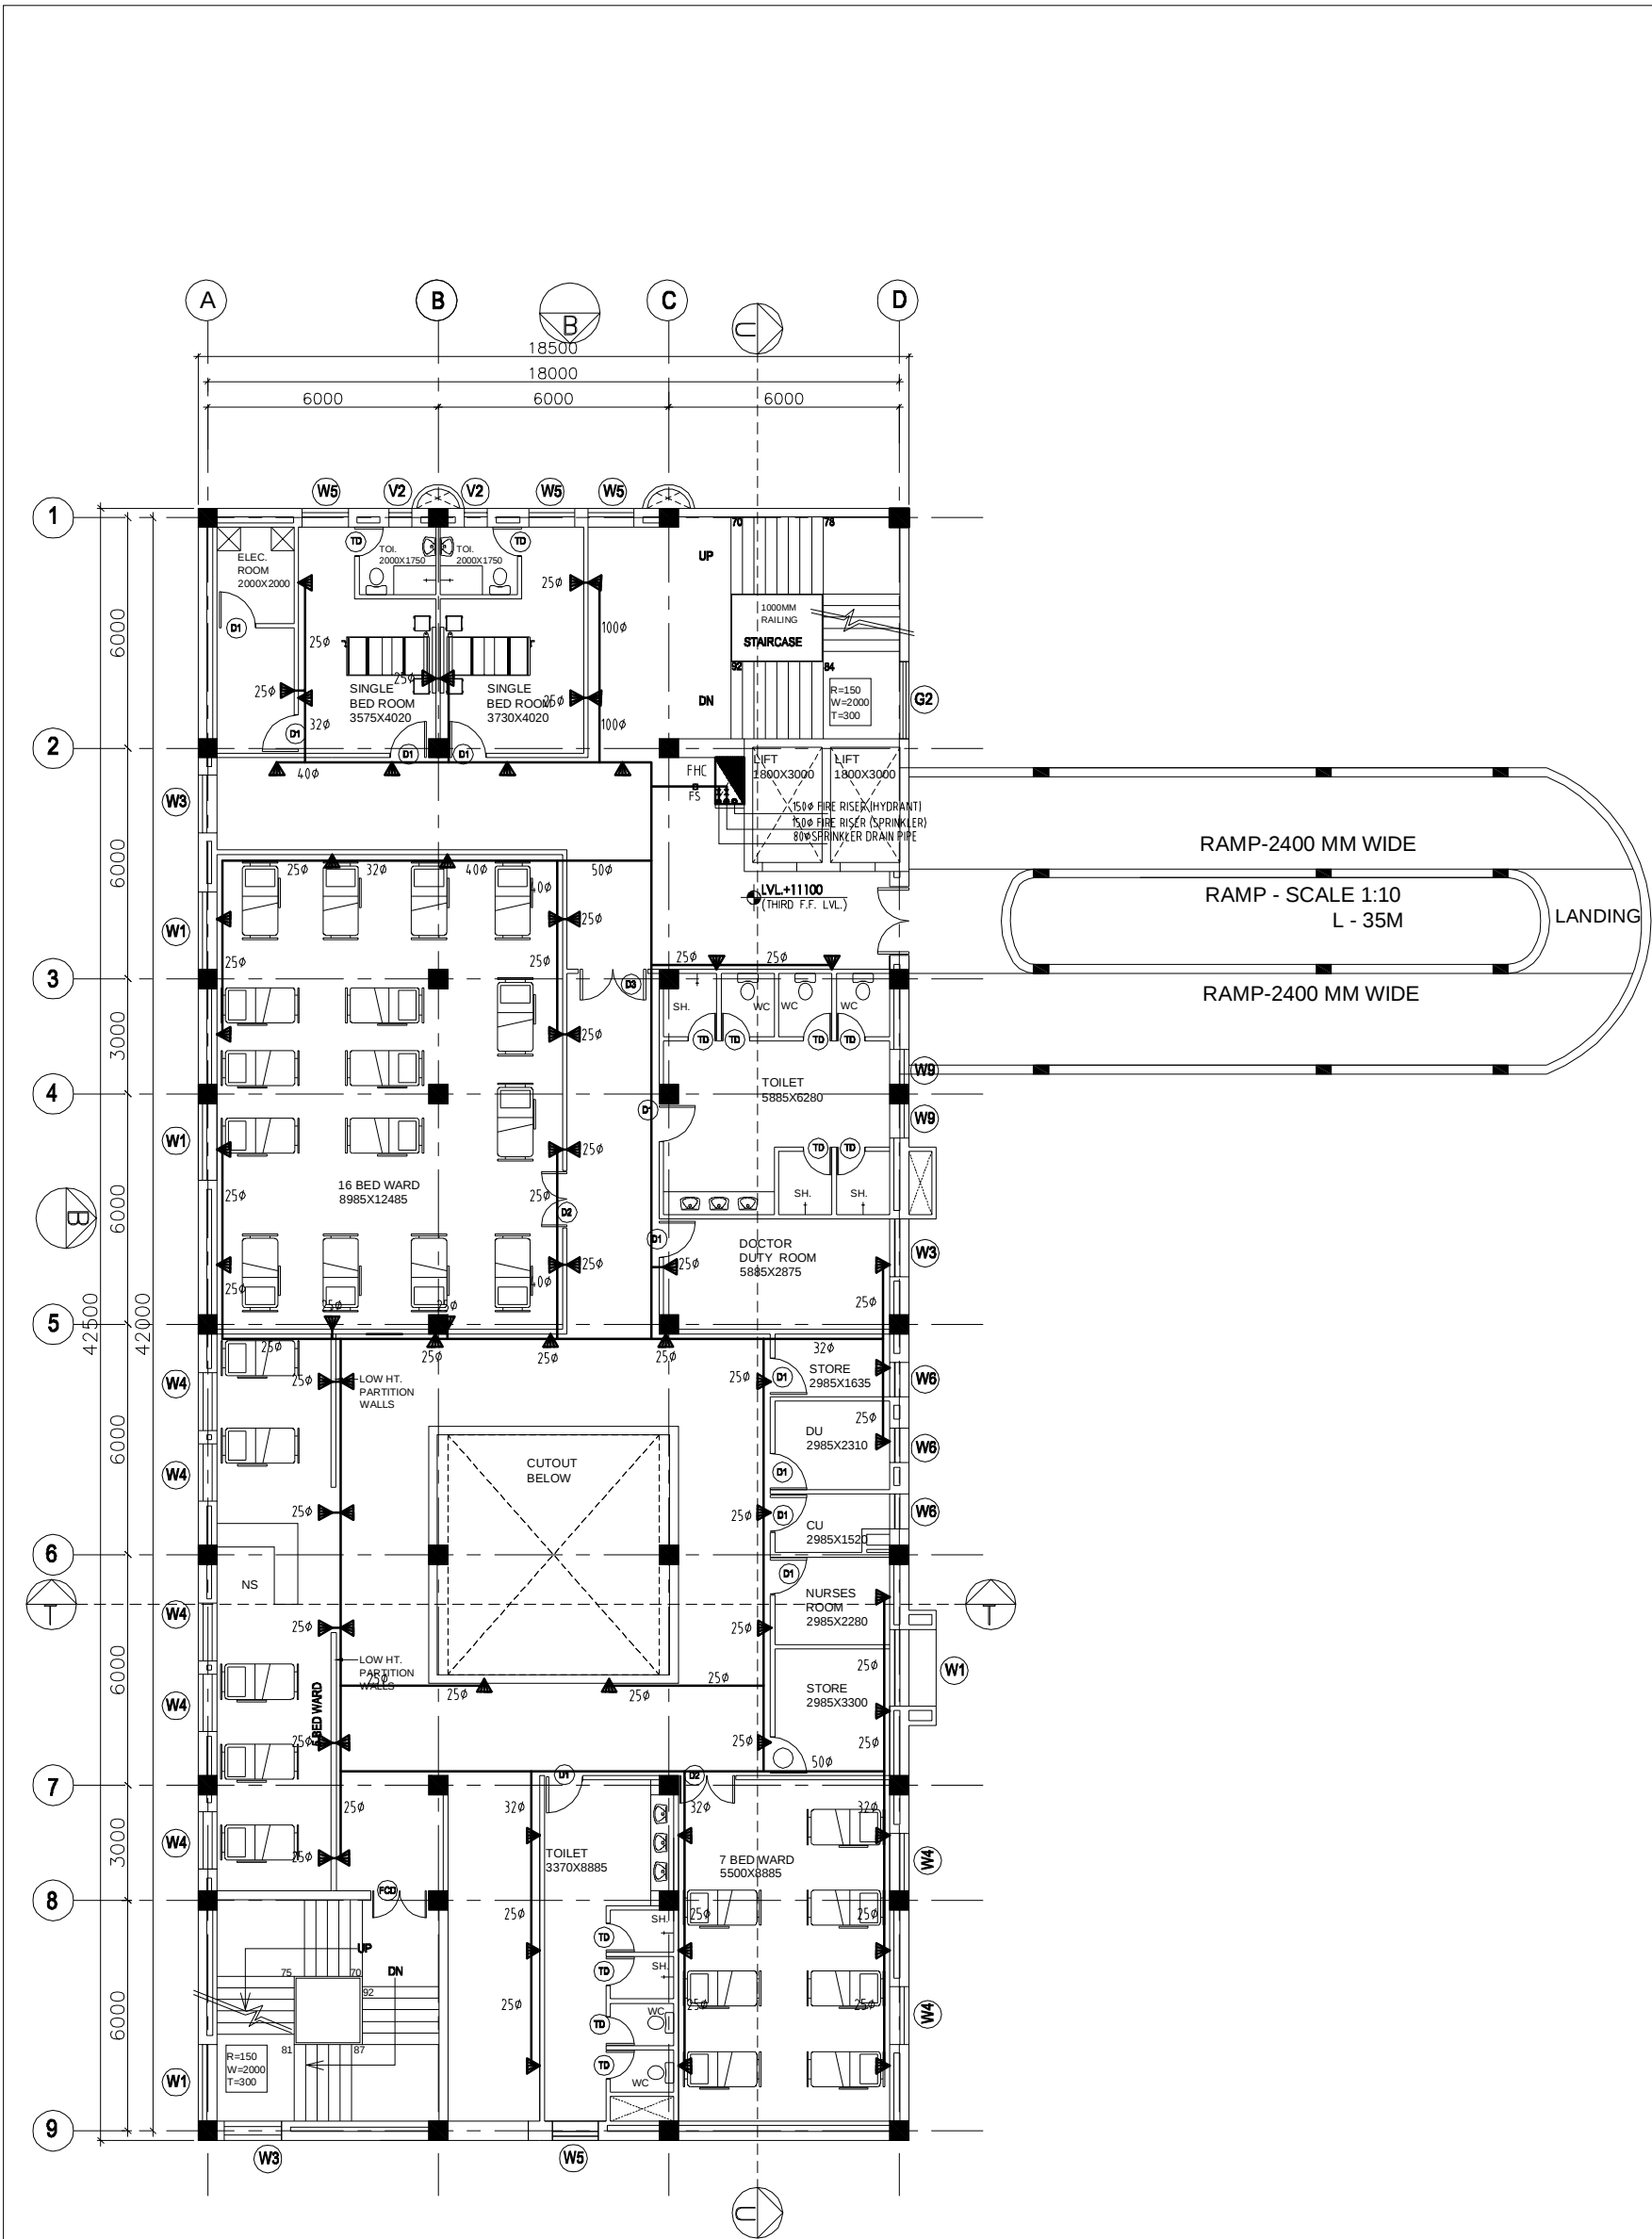

3RD FLOOR PLAN
POST NATAL - 28 BED
MATERNITY WARD +
2 SINGLE ROOMS

This drawing with all its contents is the sole intellectual property of the Hospital Services Consultancy Corporation (India) Ltd. Copying of this drawing or part thereof or its use in any form whatsoever without the written permission of HSCC is prohibited.

NOTES

1. DRAWINGS TO BE READ NOT MEASURED

2. PARTITION WALL IN TOILETS UP TO LINTEL HEIGHT

NOTES

1. BASED ON THIS DRAWING EXECUTING AGENCY WILL PREPARE SHOP DRAWING AFTER INCORPORATING THE CHANGES AS PER SITE CONDITION FOR THE APPROVAL OF HSCC BEFORE START OF WORK.

2. THE NUMBER & LOCATION OF FIXTURES & FIT POINT TO BE FINALIZED BEFORE EXECUTION WITH CLIENT OFFICIALS INCHARGE..

LEGEND:

S.NO.	DESCRIPTION	SIMBAL
1.	FIRE HOSE CABINET (FHC) size 1.2Mx0.6Mx2.1M(H)	
2.	SPRINKLER (PENDENT TYPE) SPRINKLER (SIDE WALL)	
3.	SPRINKLER PIPE	
4.	INSPECTION TEST VALVE ASSEMBLY	
5.	NON RETURN VALVE	
6.	SLUICE VALVE	
7.	FIRE LINE	

FIRE EXTINGNISHER

WATER TYPE FIRE EXTINGNISHER	
CARBON DIOXIDE TYPE FIRE EXTINGNISHER	
MANUAL CALL BOX	

NOTES ON FIRE FIGHTING

1. Every FHC shall be consisting of as per IS the following.

(a) 63mm dia. single headed Hydrant Valve.

(b) 2nos. 63mm dia. 15mts long RRL Hose reel.

(c) 20mm dia 36.5mt first aid hose reel with 5mm bore nozzle.

(d) 63mm dia.male and female INST type coupling.

(e) 20mm dia branch pipe with 20mm nozzle.

(f) 2 NOS FIRE EXTINGUISHERS

LEGEND FOR VERTICAL PIPE.

① 1500 MS FIRE RISER

② SPRINKLER RISER

③ 500 SPRINKLER DRAIN PIPE

REVISION

NO.	DESCRIPTION

PROJECT

PROPOSED
100 BEDDED HOSPITAL
PILIBHIT

TITLE

FIRE-FIGHTING

TENDER DRAWING

THIRD
FLOOR PLAN

HSCC/D&E/TD/PILIBHIT/FIRE-05

Drawing No.

Rev.

Job No.

1:150
Scale

MARCH-2013
Date

R.TYAGI
App by

R.SUR
Rev. by

S.BHATT
Prep. by

HSCC (INDIA) LIMITED
(A GOVERNMENT OF INDIA ENTERPRISES)

HSCC

NEW DELHI

INDIA