


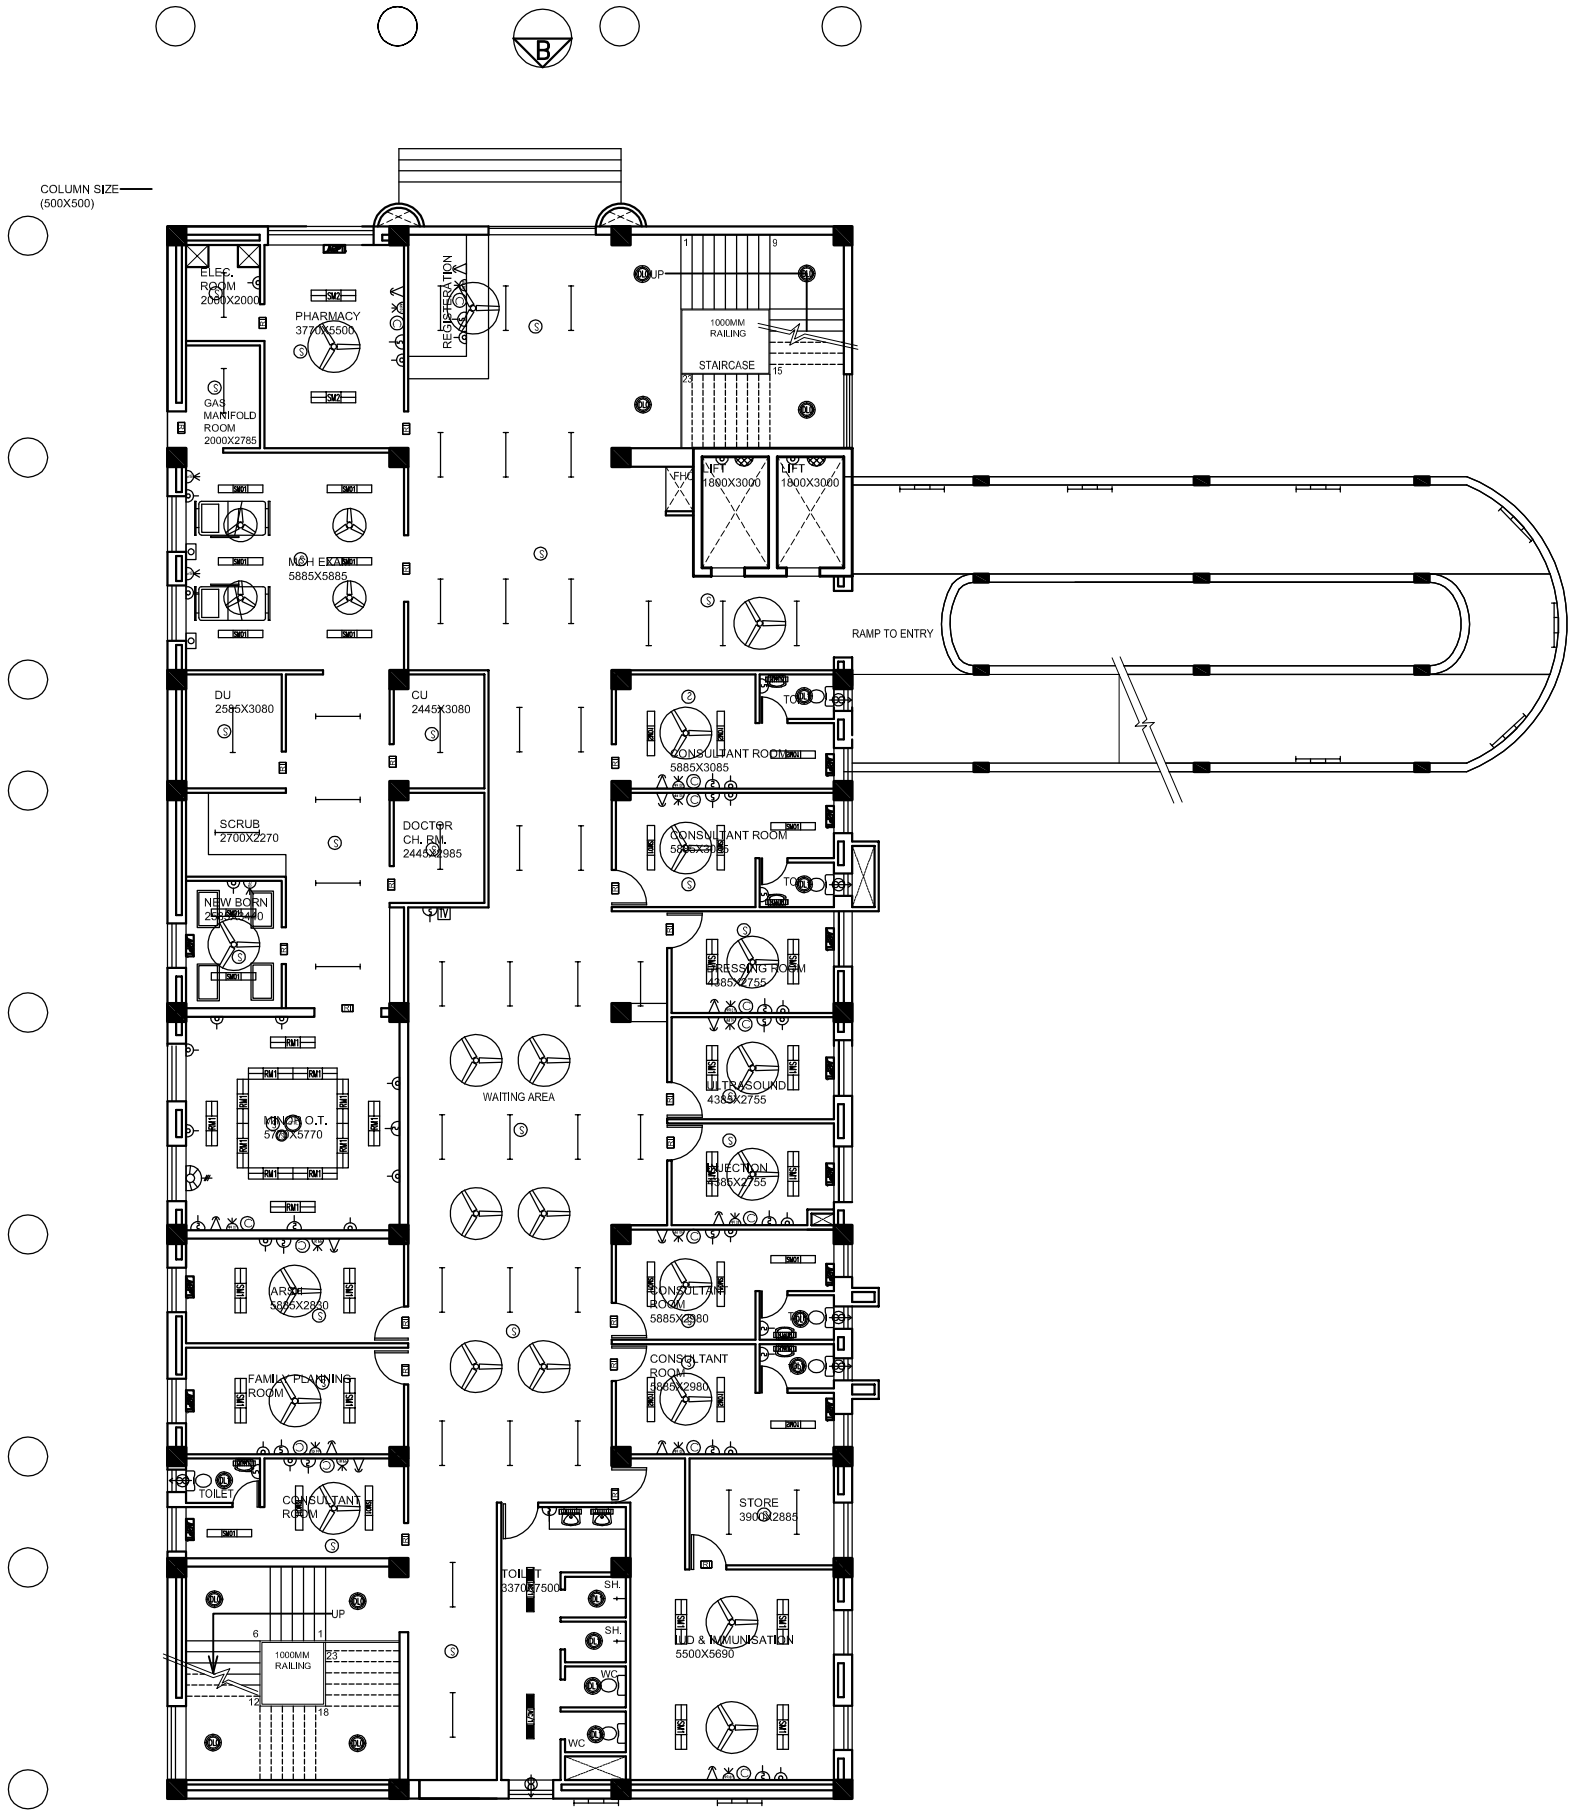

GROUND FLOOR PLAN
EMERGENCY + OPD

This drawing with all its contents is the sole intellectual property of the Hospital Services Consultancy Corporation (India) Ltd. Copying of this drawing or part thereof or its use in any form whatsoever without the written permission of HSCC is prohibited.

- NOTES
1. DRAWINGS TO BE READ NOT MEASURED
 2. PARTITION WALL IN TOILETS UP TO LINTEL HEIGHT

REVISION	DESCRIPTION

PROJECT

PROPOSED
100 BEDDED HOSPITAL
PILIBHIT

TITLE

TENDER DRAWING

GROUND
FLOOR PLAN
ELECTRICAL LAYOUT

HSCC/D&E/ID/UP(PILIBHIT)/EL-101		
Drawing No.	Rev.	
Job No.	NTS Scale	MARCH-2013 Date
App by	Rev. by	Prep. by