


This drawing with all its contents is the sole intellectual property of the Hospital Services Consultancy Corporation (India) Ltd. Copying of this drawing or part thereof or its use in any form whatsoever without the written permission of HSCC is prohibited.

NOTES

1. DRAWINGS TO BE READ NOT MEASURED
2. PARTITION WALL IN TOILETS UP TO LINTEL HEIGHT

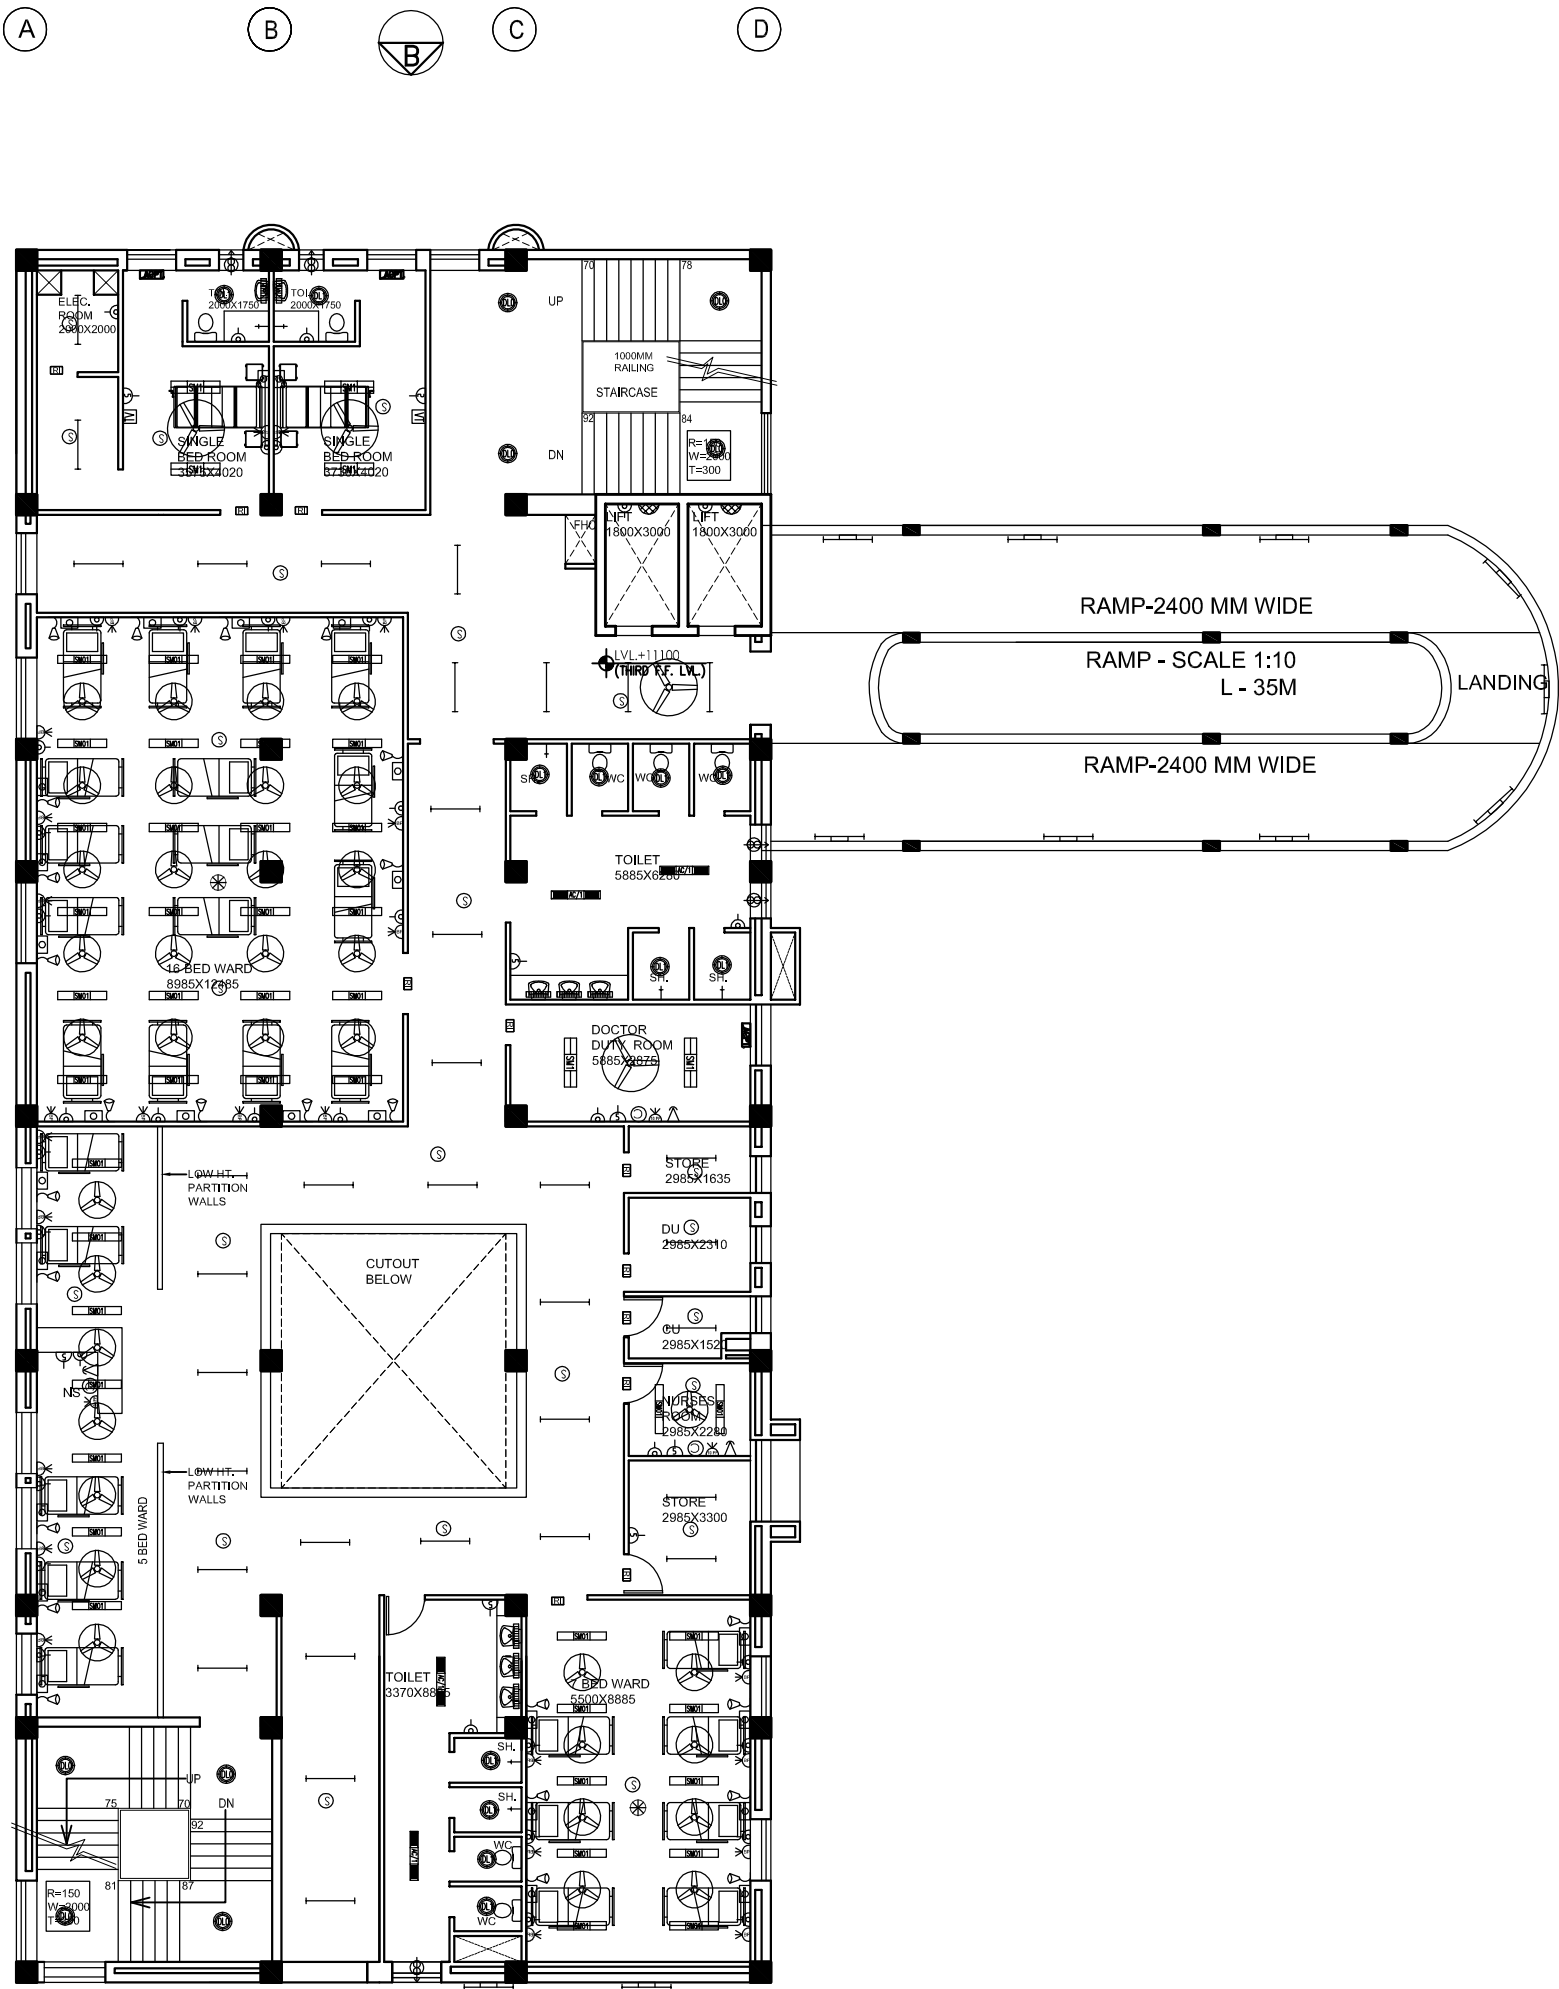

3RD FLOOR PLAN
POST NATAL – 28 BED
MATERNITY WARD +
2 SINGLE ROOMS

REVISION

PROJECT

PROPOSED
100 BEDDED HOSPITAL
PILIBHIT

TITLE

TENDER DRAWING

THIRD
FLOOR PLAN
ELECTRICAL LAYOUT

HSCC/D&E/ID/UP(PILIBHIT)/EL-104
Drawing No.

Rev. NTS MARCH-2013
Scale Date

Job No. App by Rev. by Prep. by

HSCC (INDIA) LIMITED
(A GOVERNMENT OF INDIA ENTERPRISES)

HSCC
NEW DELHI INDIA