


This drawing with all its contents is the sole intellectual property of the Hospital Services Consultancy Corporation (India) Ltd. Copying of this drawing or part thereof or its use in any form whatsoever without the written permission of HSCC is prohibited.

NOTES

- DRAWINGS TO BE READ NOT MEASURED
- PARTITION WALL IN TOILETS UP TO LINTEL HEIGHT

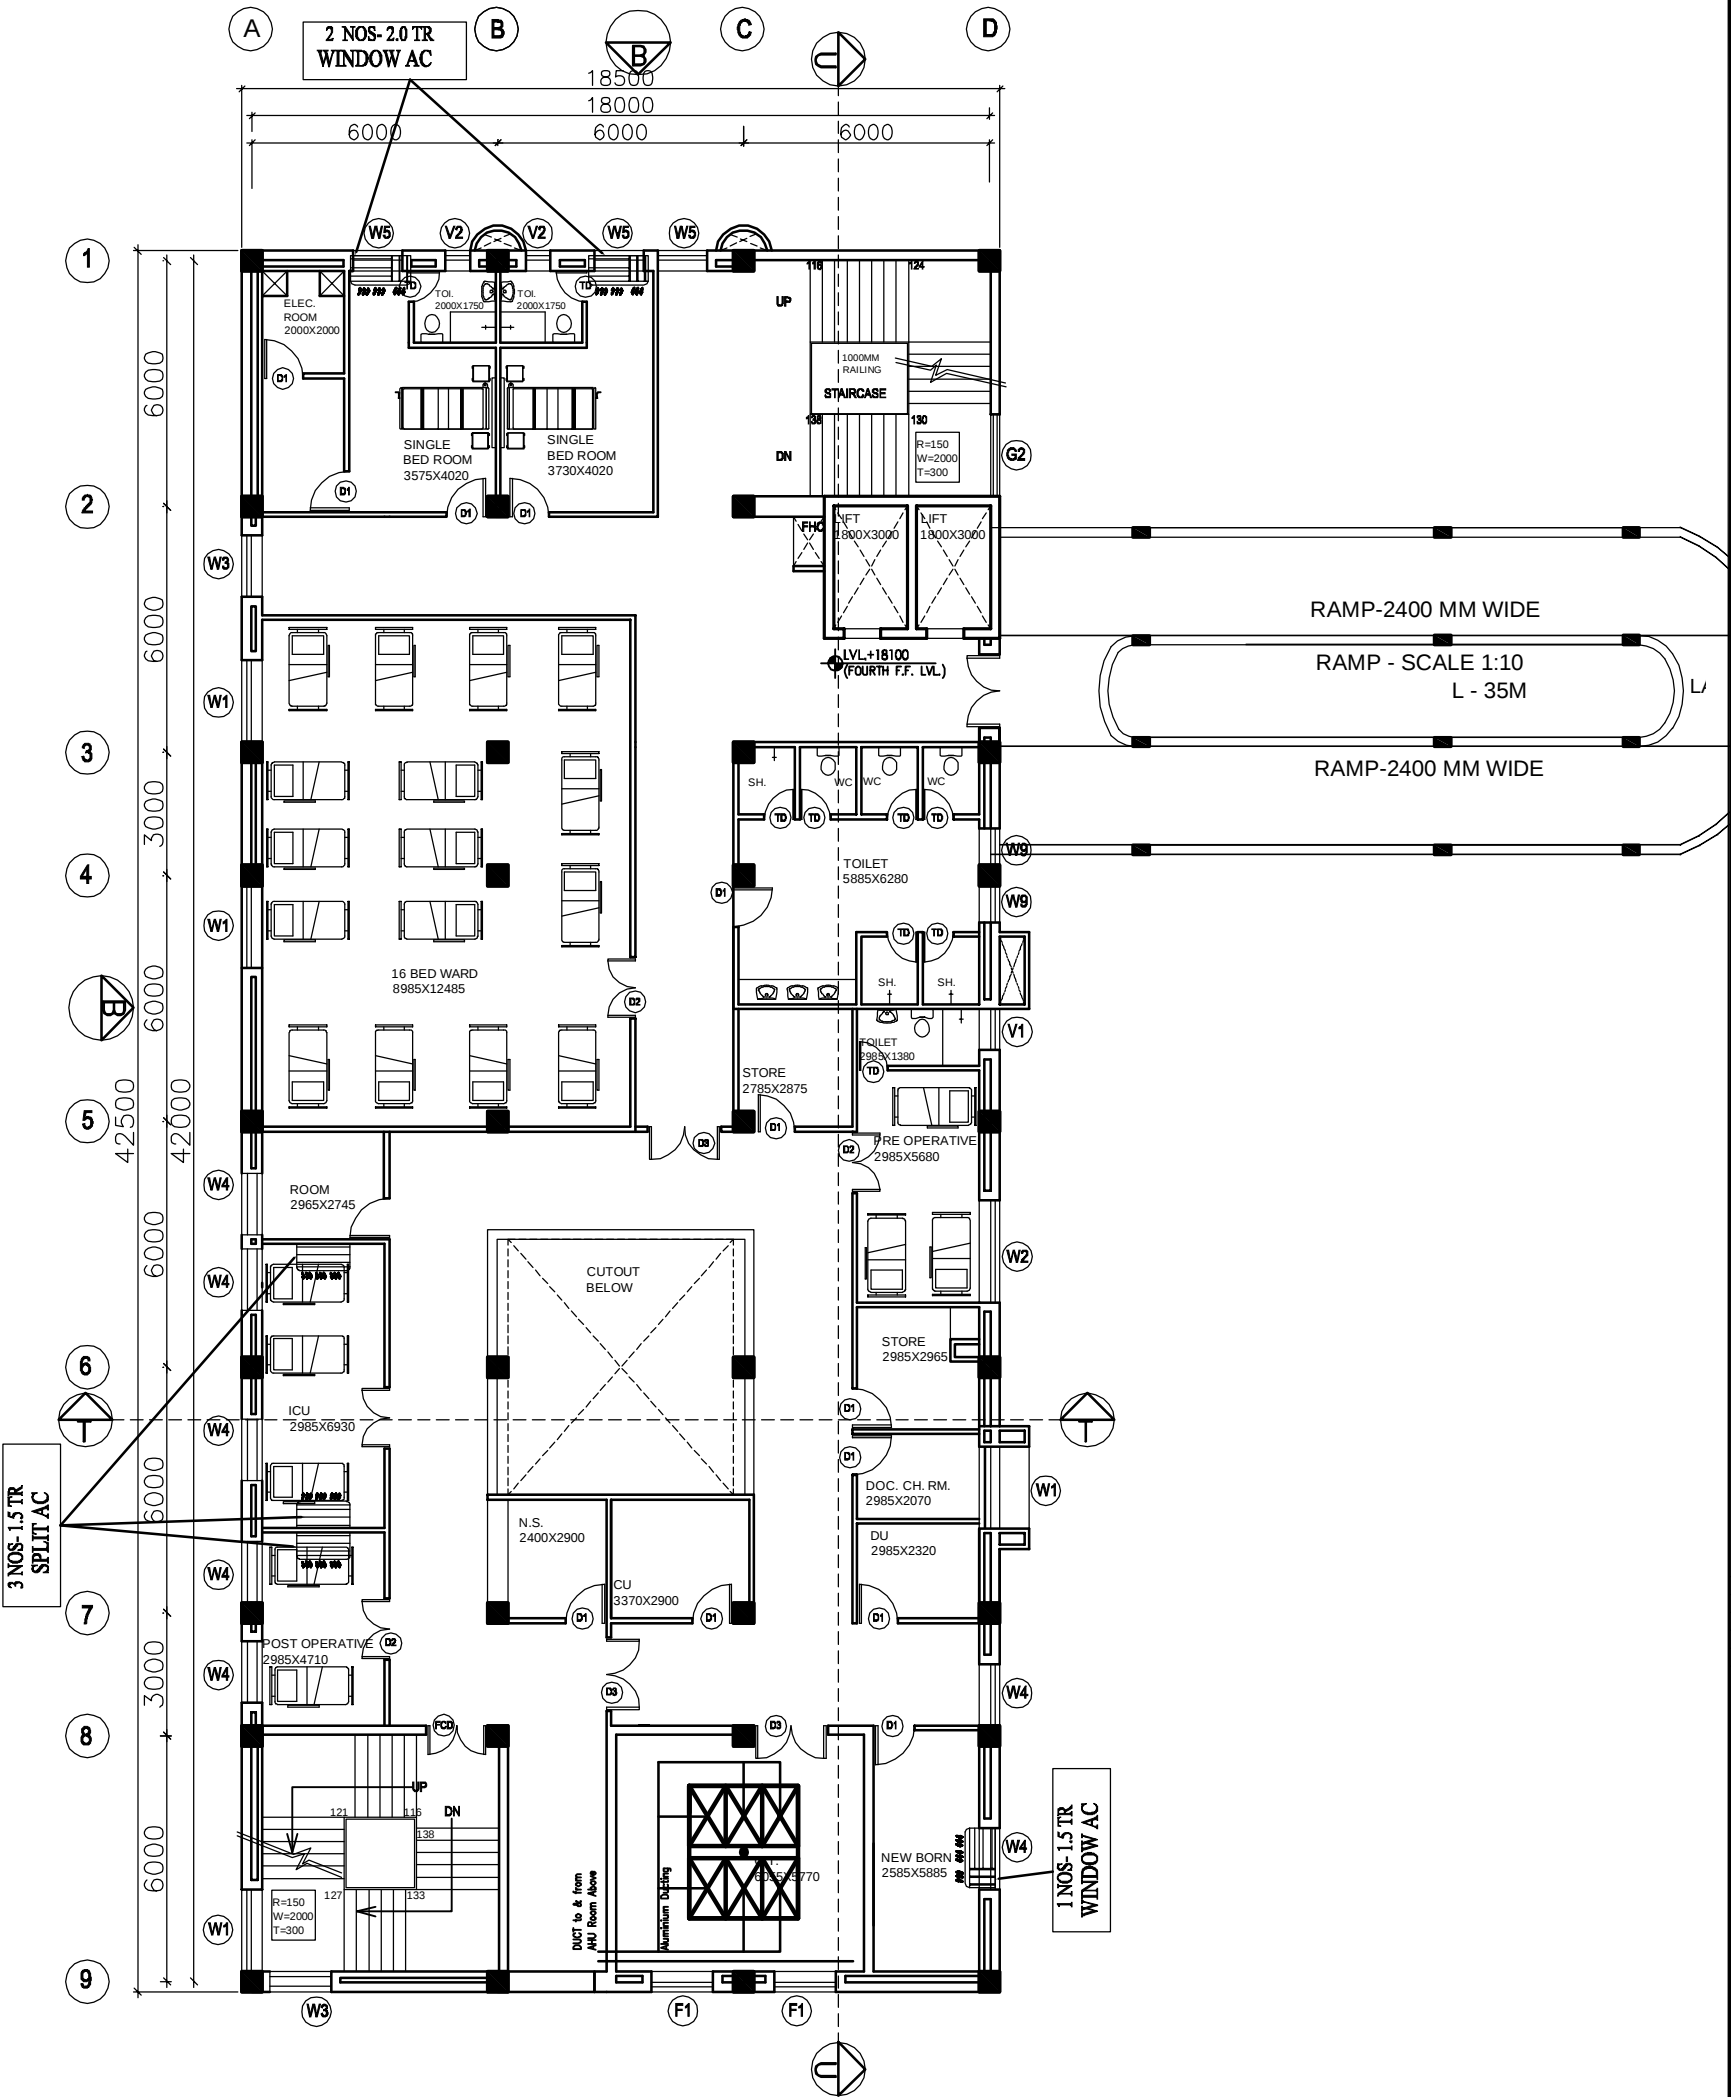

5TH FLOOR PLAN
O.T. + WARD (16 BED)
+ 2 SINGLE ROOMS

REVISION	
NO.	DESCRIPTION

PROJECT
PROPOSED
100 BEDDED HOSPITAL
PILIBHIT

TITLE
TENDER DRAWING
FIFTH FLOOR PLAN
HVAC LAYOUT

HSCC/D&E/HVAC/UP-PILIBHIT/AC-03	
Drawing No.	Rev.
Job No.	1:150 Scale
App by	MARCH-2013 Date
Rev. by	Prep. by