


This drawing with all its contents is the sole intellectual property of the Hospital Services Consultancy Corporation (India) Ltd. Copying of this drawing or part thereof or its use in any form whatsoever without the written permission of HSCC is prohibited.

NOTES

1. DRAWINGS TO BE READ NOT MEASURED
2. PARTITION WALL IN TOILETS UP TO LINTEL HEIGHT

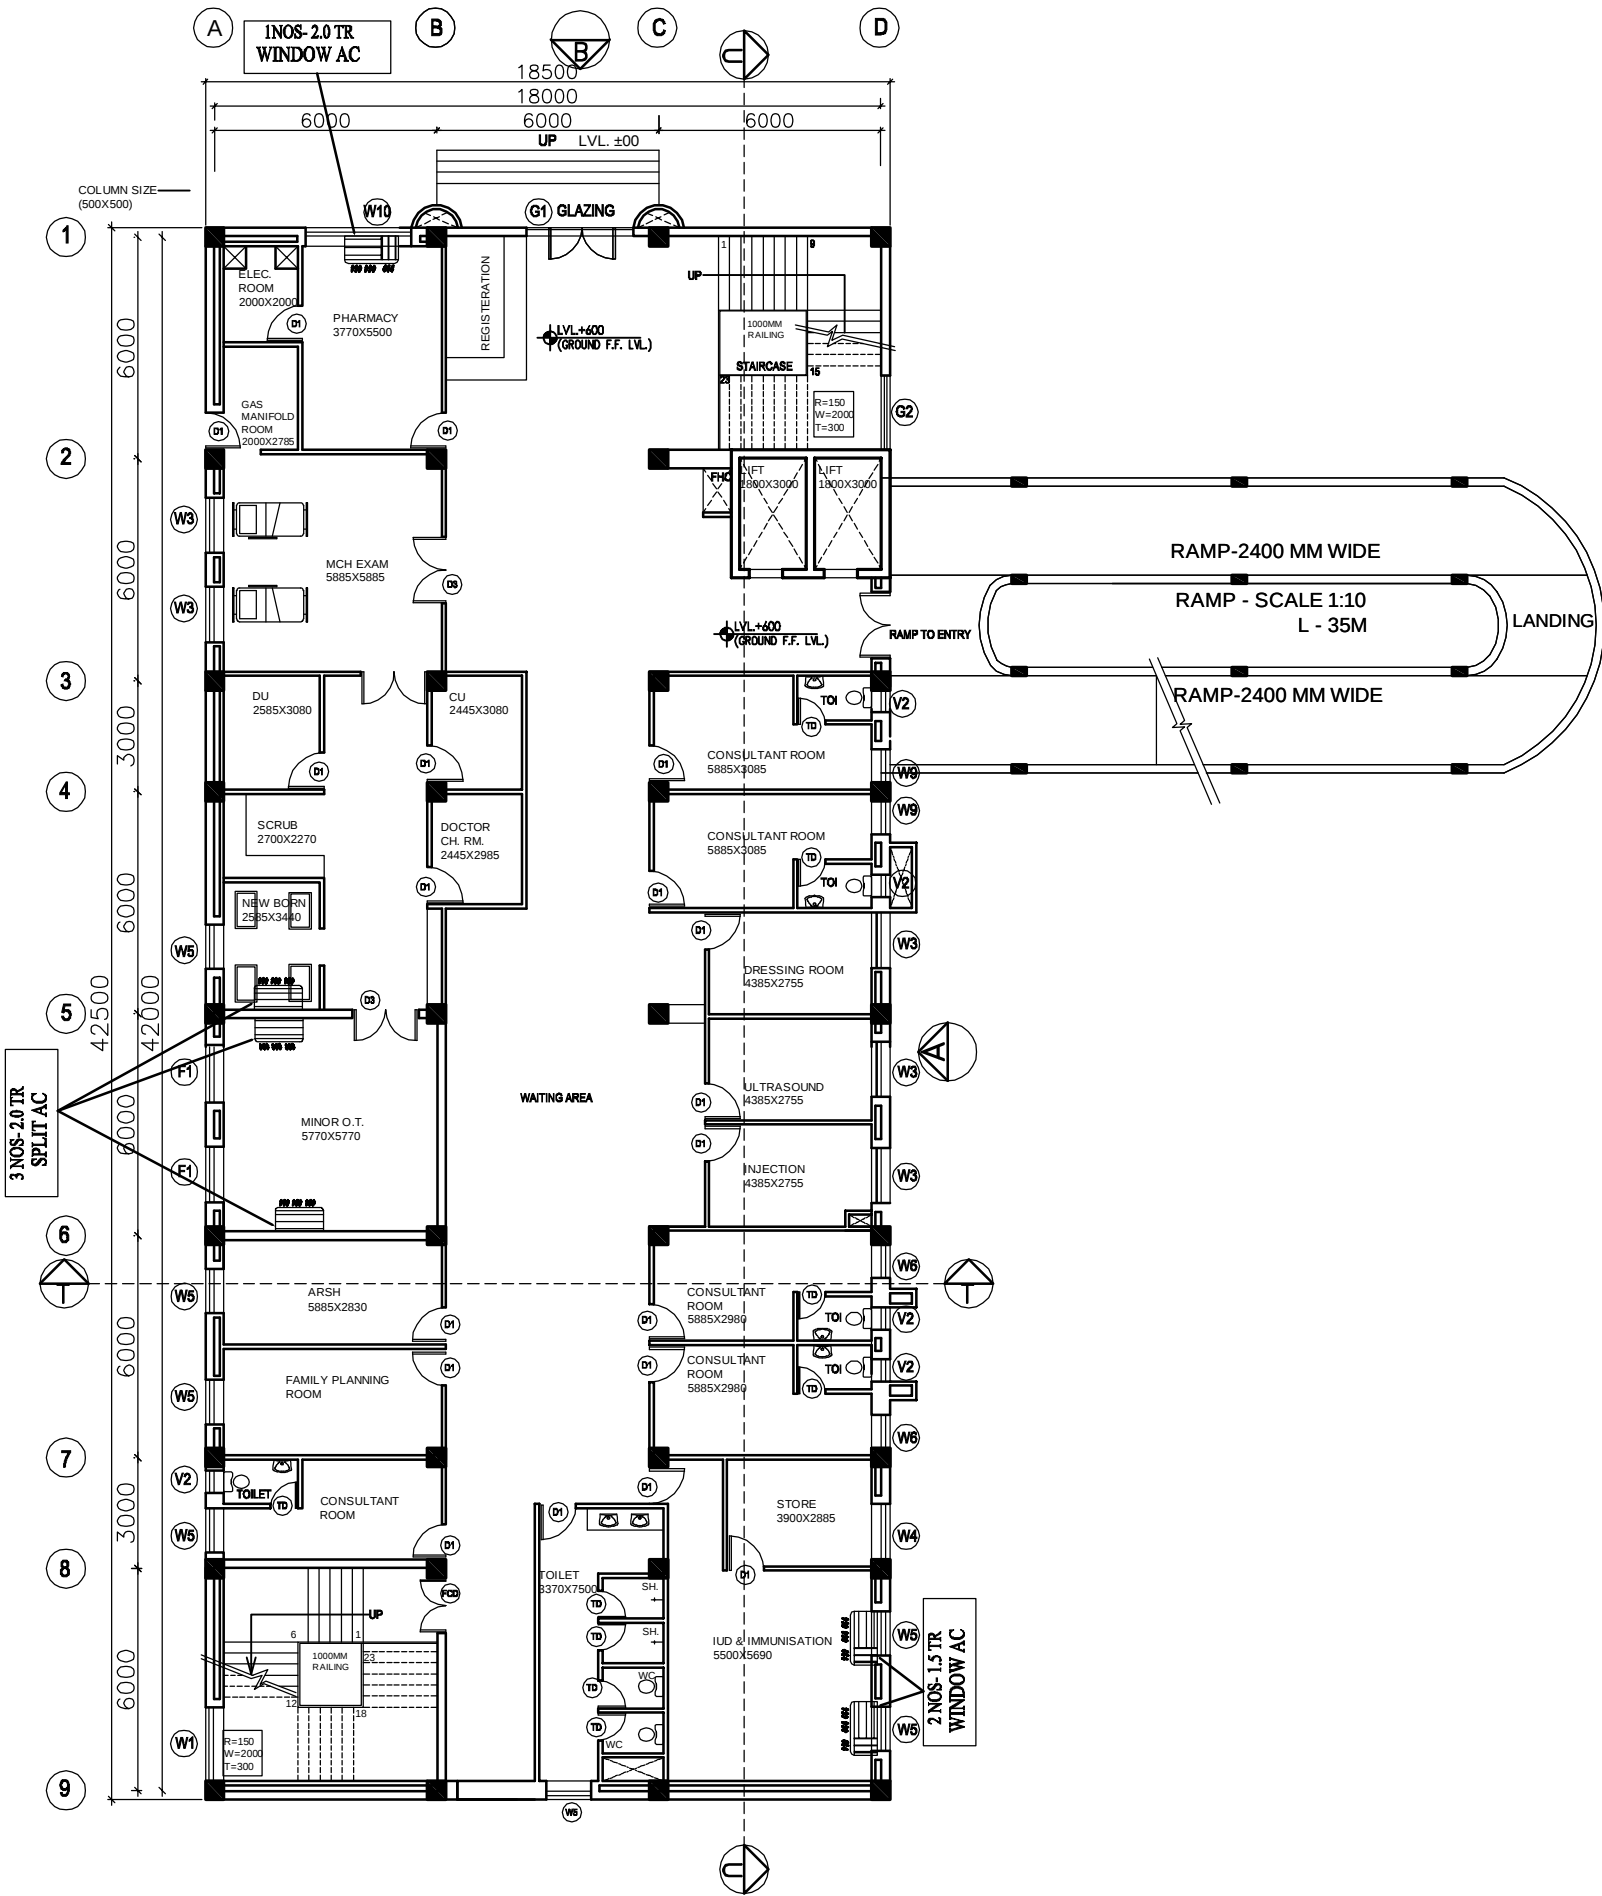

GROUND FLOOR PLAN
EMERGENCY + OPD

REVISION

PROJECT

PROPOSED
100 BEDDED HOSPITAL
PILIBHIT

TITLE

TENDER DRAWING
GROUND FLOOR PLAN
HVAC LAYOUT

HSCC/D&E/HVAC/UP-PILIBHIT/AC-01
Drawing No. Rev.

Job No. 1:150 Scale MARCH-2013 Date

App by Rev. by Prep. by

HSCC (INDIA) LIMITED
(A GOVERNMENT OF INDIA ENTERPRISES)
HSCC
NEW DELHI INDIA